

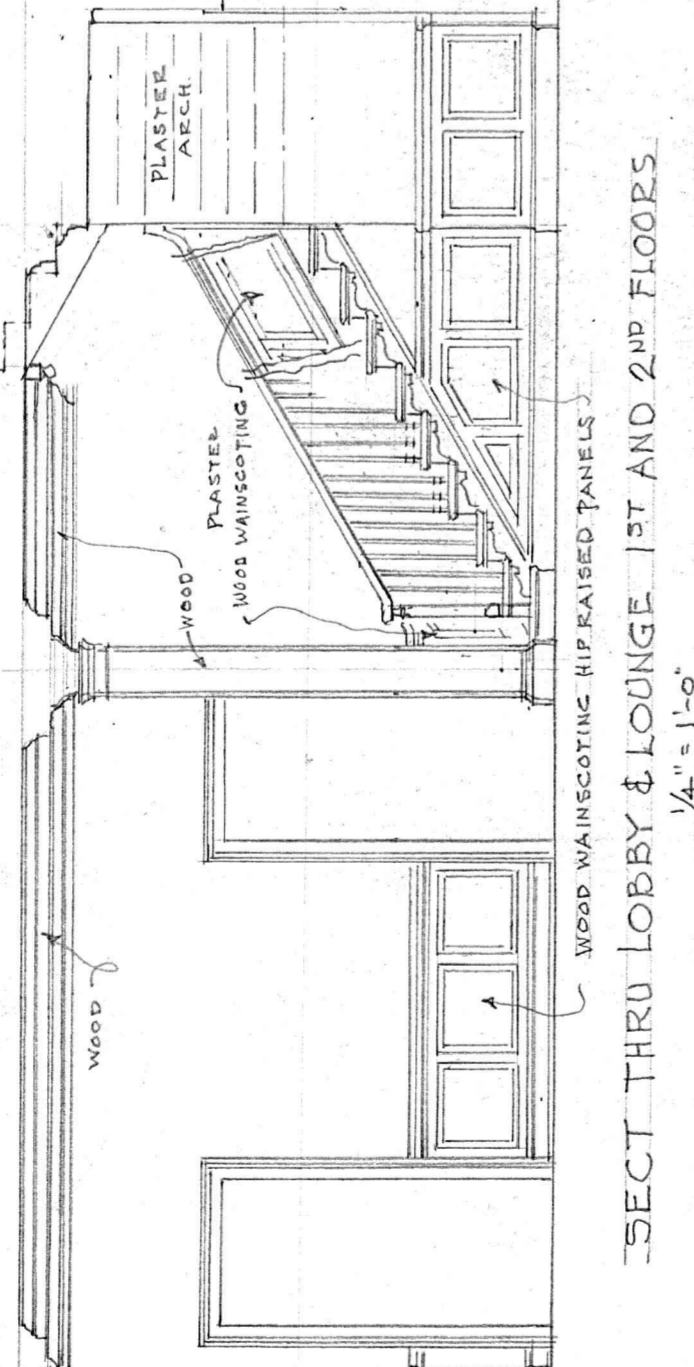
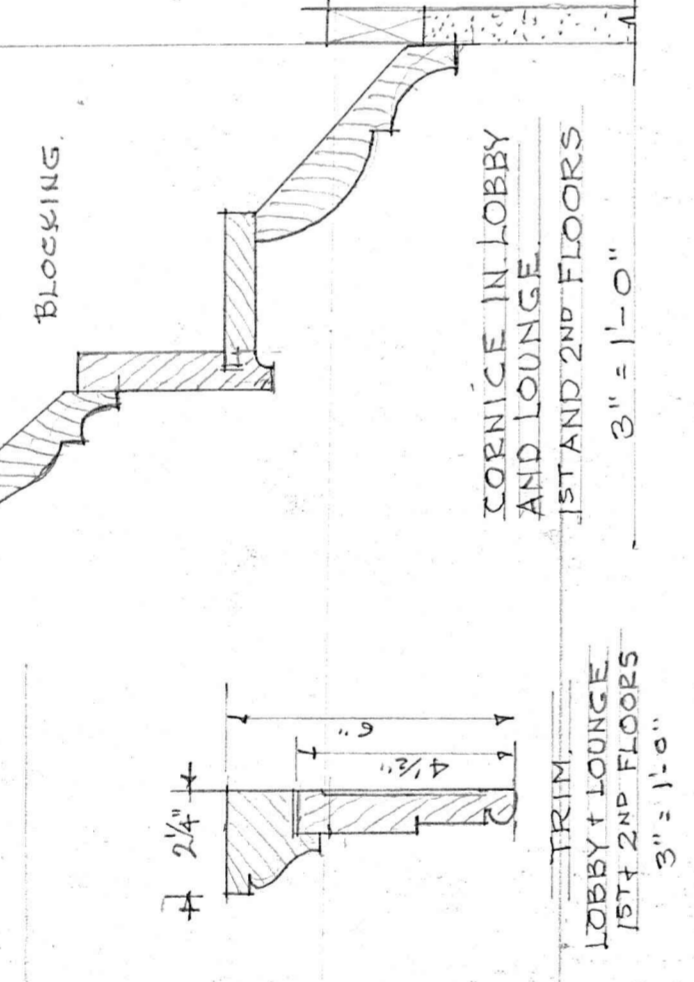
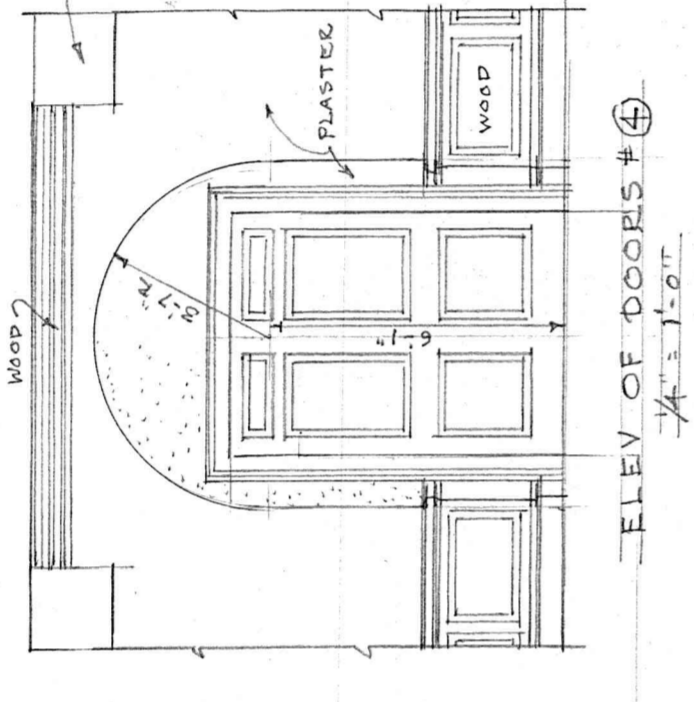


DOOR SCHEDULE				
MARK	SIZES	MATERIAL	TRIM	REMARKS
1	2'-6" x 7'-0" x 1 3/8"	WOOD	WOOD	
2	2'-6" x 7'-0" x 1 3/8"	WOOD	WOOD	
3	3'-0" x 7'-0" x 1 3/8"	WOOD	WOOD	
4	2'-6" x 7'-0" x 1 3/8"	WOOD	WOOD	
5	2'-6" x 8'-0" x 1 3/8"	WOOD	WOOD	
6	2'-2" x 5'-0" x 1 3/8"	WOOD	WOOD	



NOTE:
 CHAIR RAIL TO BE SAME AS EXISTING CHAIR RAIL.
 PUT IN ALL FIRST FLOOR ROOMS EXCEPT TOILET.
 CHAIR RAIL FROM FLOOR TO BE SAME AS
 EXISTING CHAIR RAIL HEIGHT.

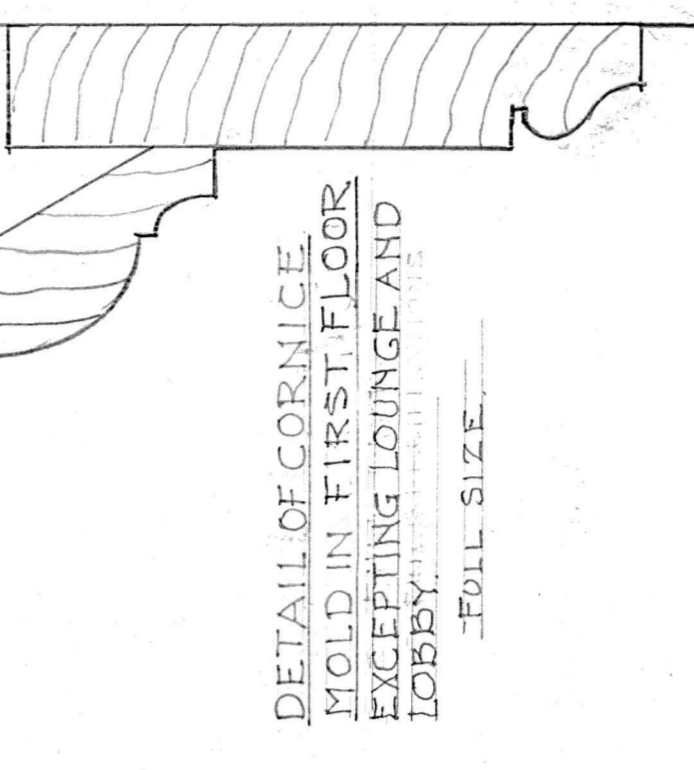

SCHEDULE OF FINISHES				
LOCATION	WALLS	CEILING	FLOORS	REMARKS
VESTIBULE #12	PLASTER	CONCRETE	CONCRETE	
CHapel	REPLASTER & PAINT	REPLASTER & PAINT	WOOD FINISH	SEE SH. 3 & 4 FOR DETAILS
LOBBY & LOUNGE	PATCH PLASTER & PAINT	PATCH PLASTER & PAINT	NEW OAK CERAMIC	MANUFACTURING
BOARD ROOM	DO.	DO.	DO.	
STAIRS	DO.	DO.	DO.	
BUSINESS OFFICE	DO.	DO.	DO.	
MEN & WOMEN TOILETS	DO.	DO.	DO.	
STORAGE 1, 2 & 3	PATCH & PAINT	DO.	REFINISH	
LOUNGE	PLASTER & PAINT	DO.	REFINISH	
STAIRS	DO.	PATCH & PAINT	DO.	MANUFACTURING
DINING ROOM	DO.	EXISTING	NO WORK IN THIS AREA	

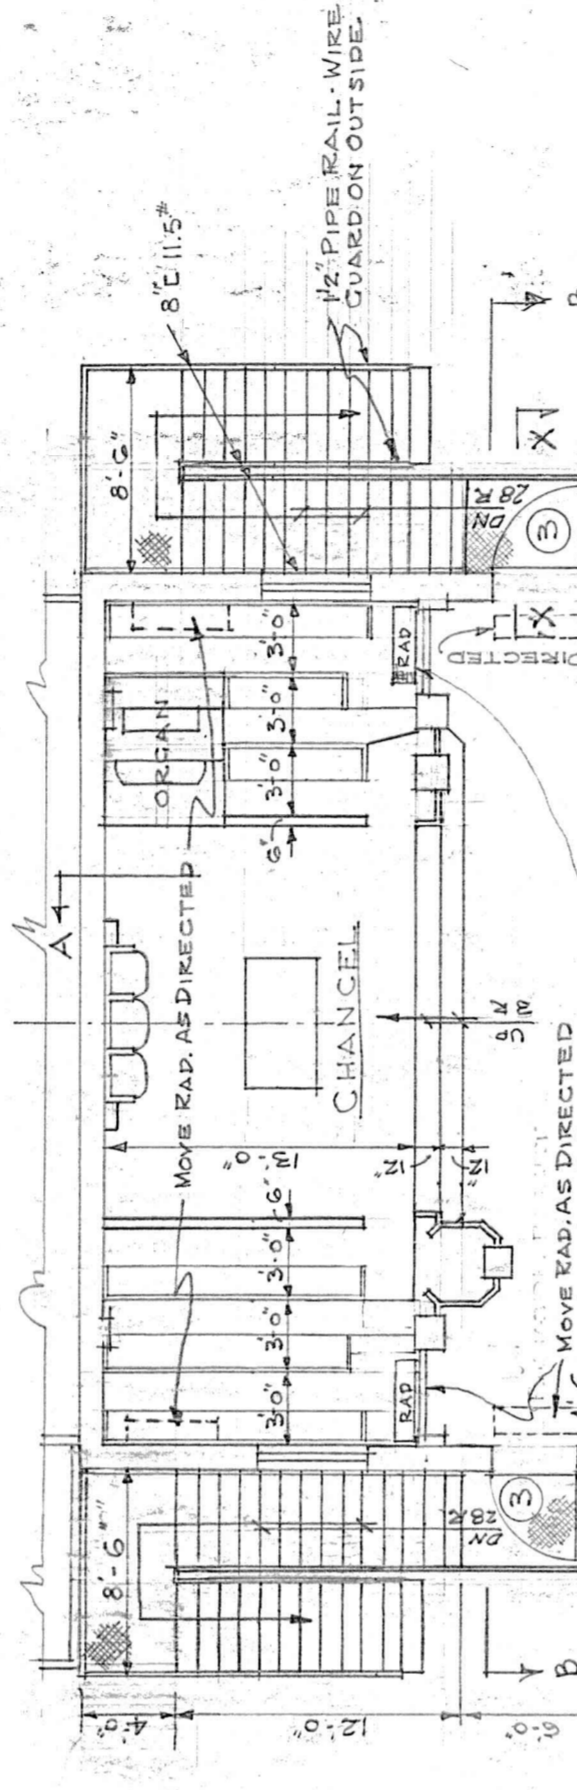

- GENERAL NOTES:
1. ALL NEW PARTITIONS TO BE SET IN CONCRETE UNDER EACH COLUMN AT FOUNDATION.
 2. COVER EXPOSED PIPES.
 3. DOORS #2 TO BE REMOVED WHEN SCREEN DOORS ARE USED.
 4. WHEN SCREEN DOORS ARE USED.

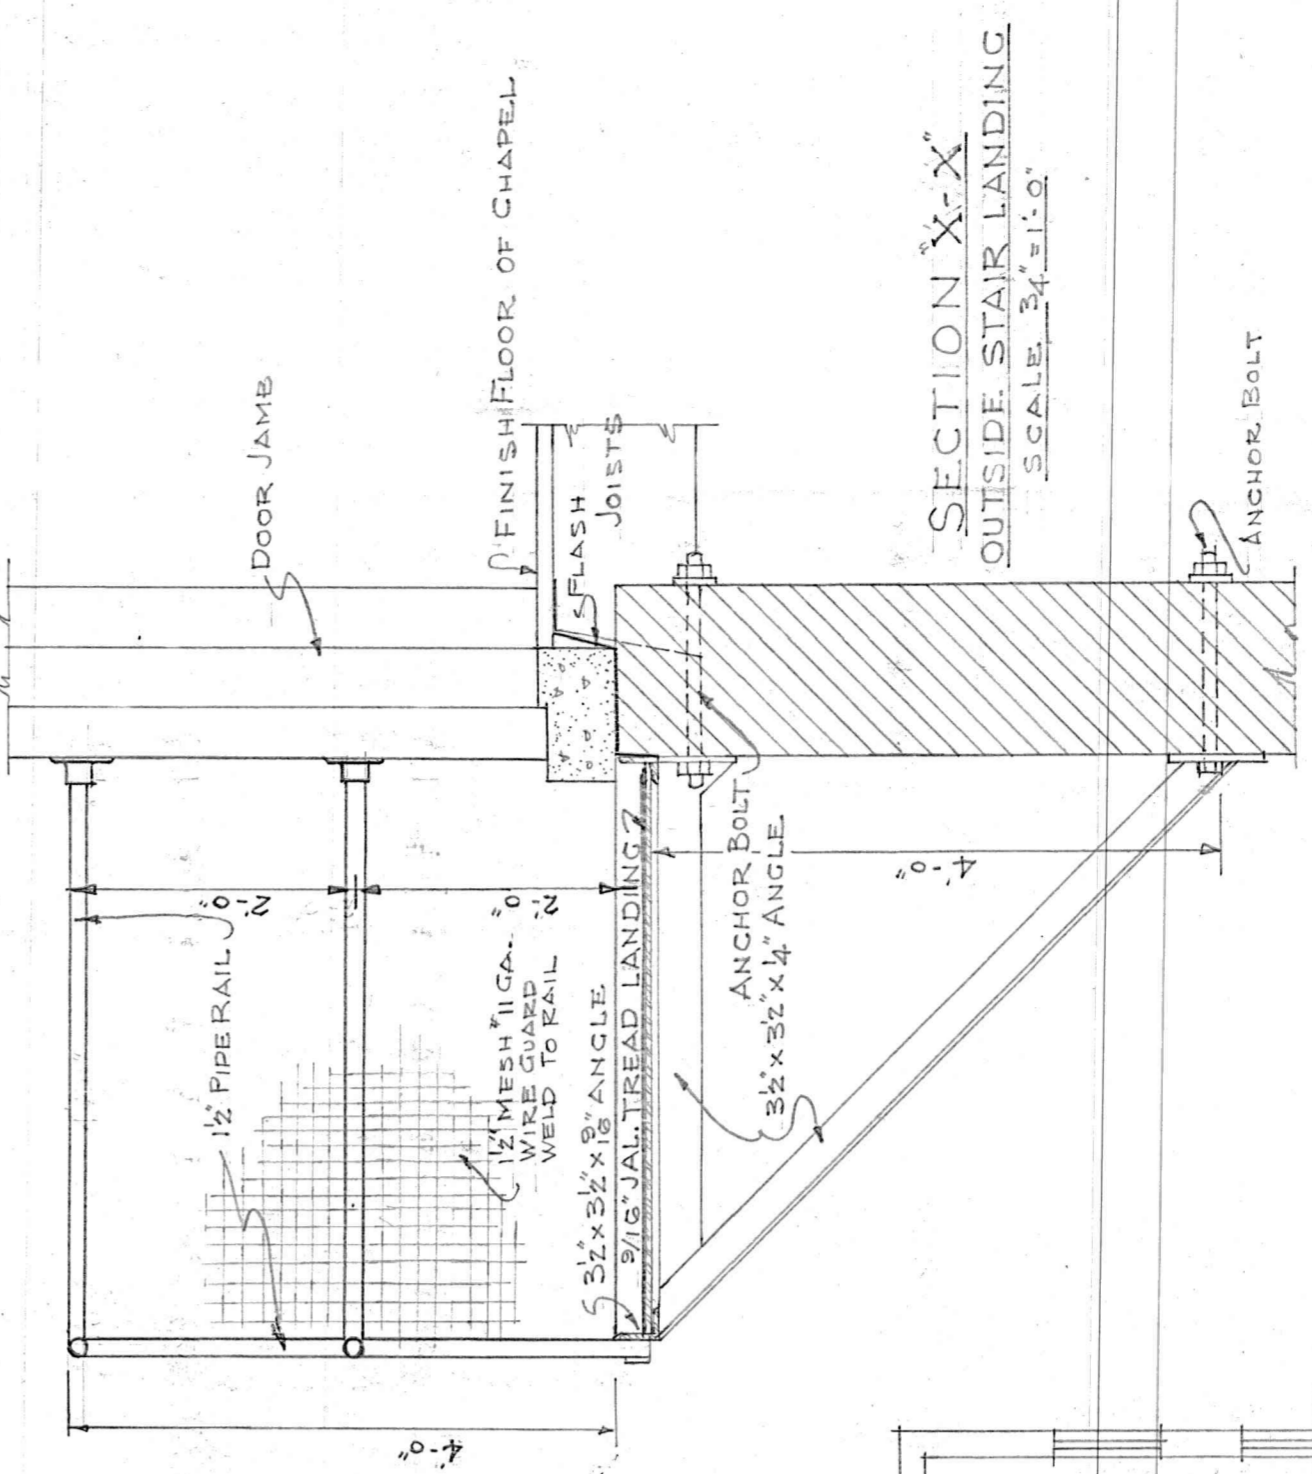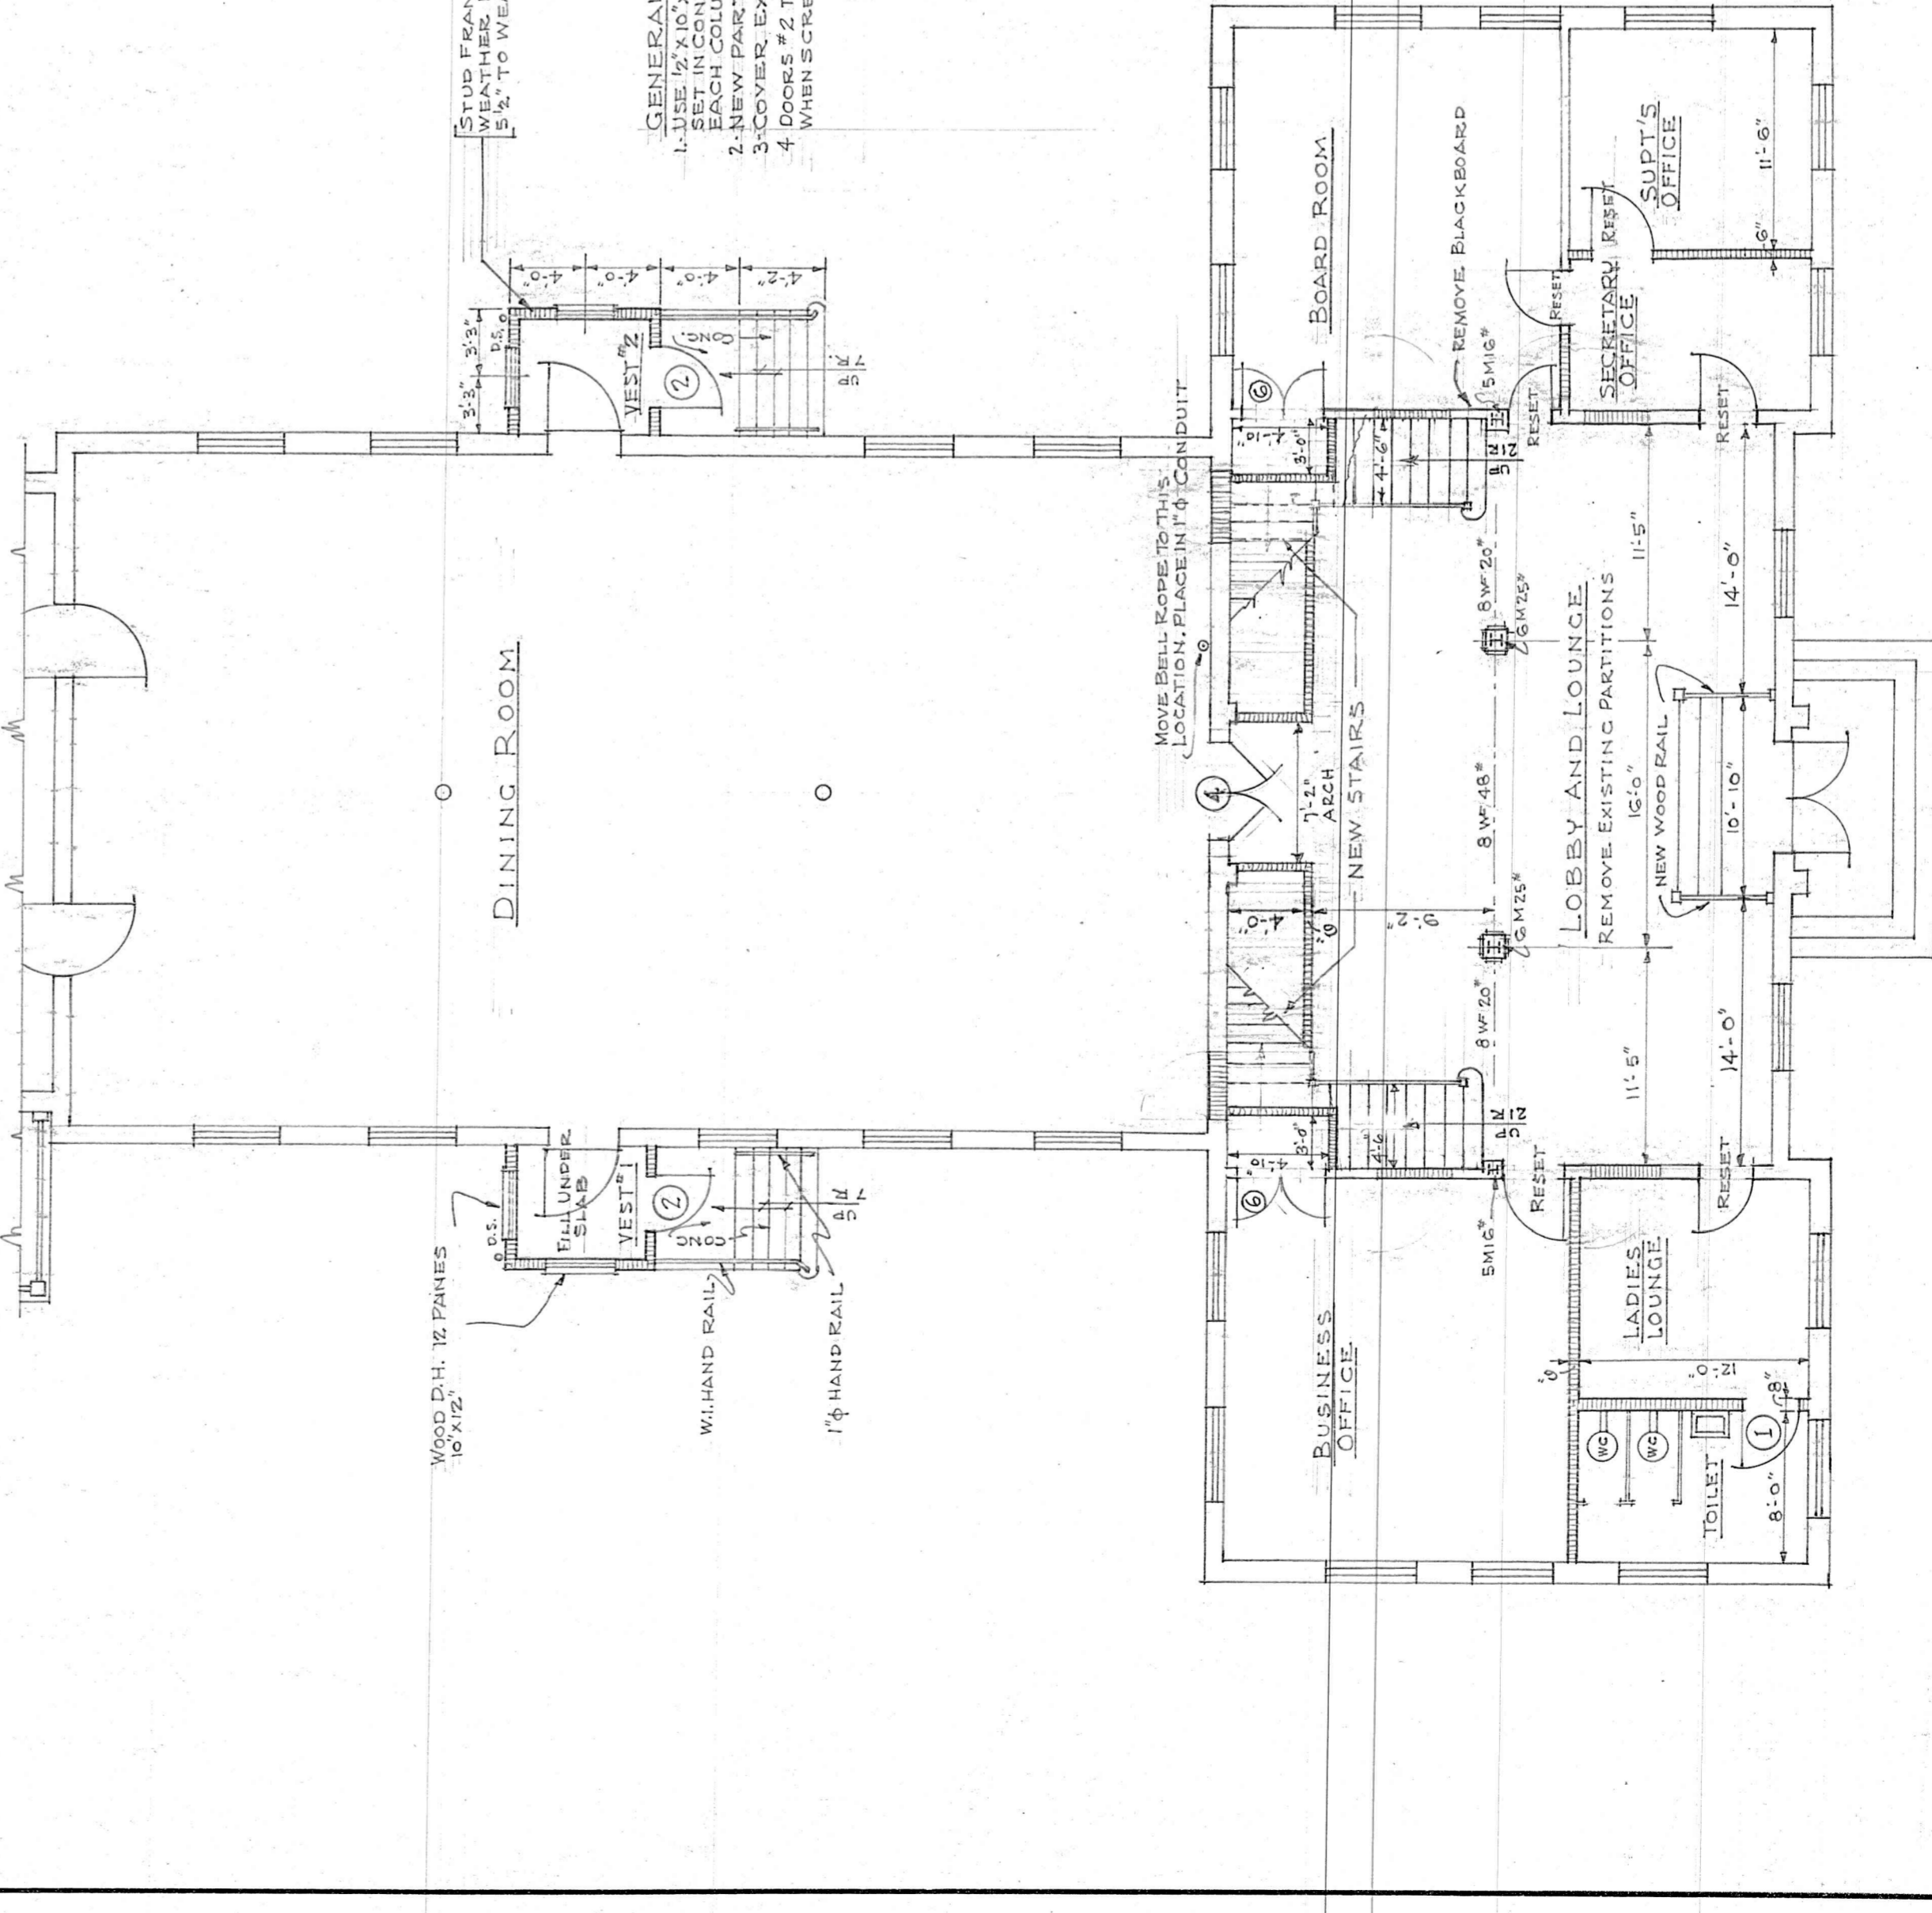

SEATING
 CHAPEL 168
 CHOIR 52
 TOTAL 200

LEGEND OF MATERIALS
 EXISTING WORK UNCHANGED I STEEL
 NEW PARTITIONS
 BRICK
 CONCRETE

FIRST FLOOR PLAN SCALE 1/8" = 1'-0"


SECOND FLOOR PLAN SCALE 1/8" = 1'-0"

ALTERATIONS TO ADMINISTRATION BUILDING & CHAPEL PRESBYTERIAN ORPHAN'S HOME LYNCHBURG, VIRGINIA

PENDLETON S. CLARK, ARCHITECT LYNCHBURG, VA.

FIRST & SECOND FLOOR PLANS

DATE: 1915
 REVISIONS: 1
 DRAWN BY: C.A.V.
 SCALE: 1/8" = 1'-0"
 CHECKED: W.R.N.

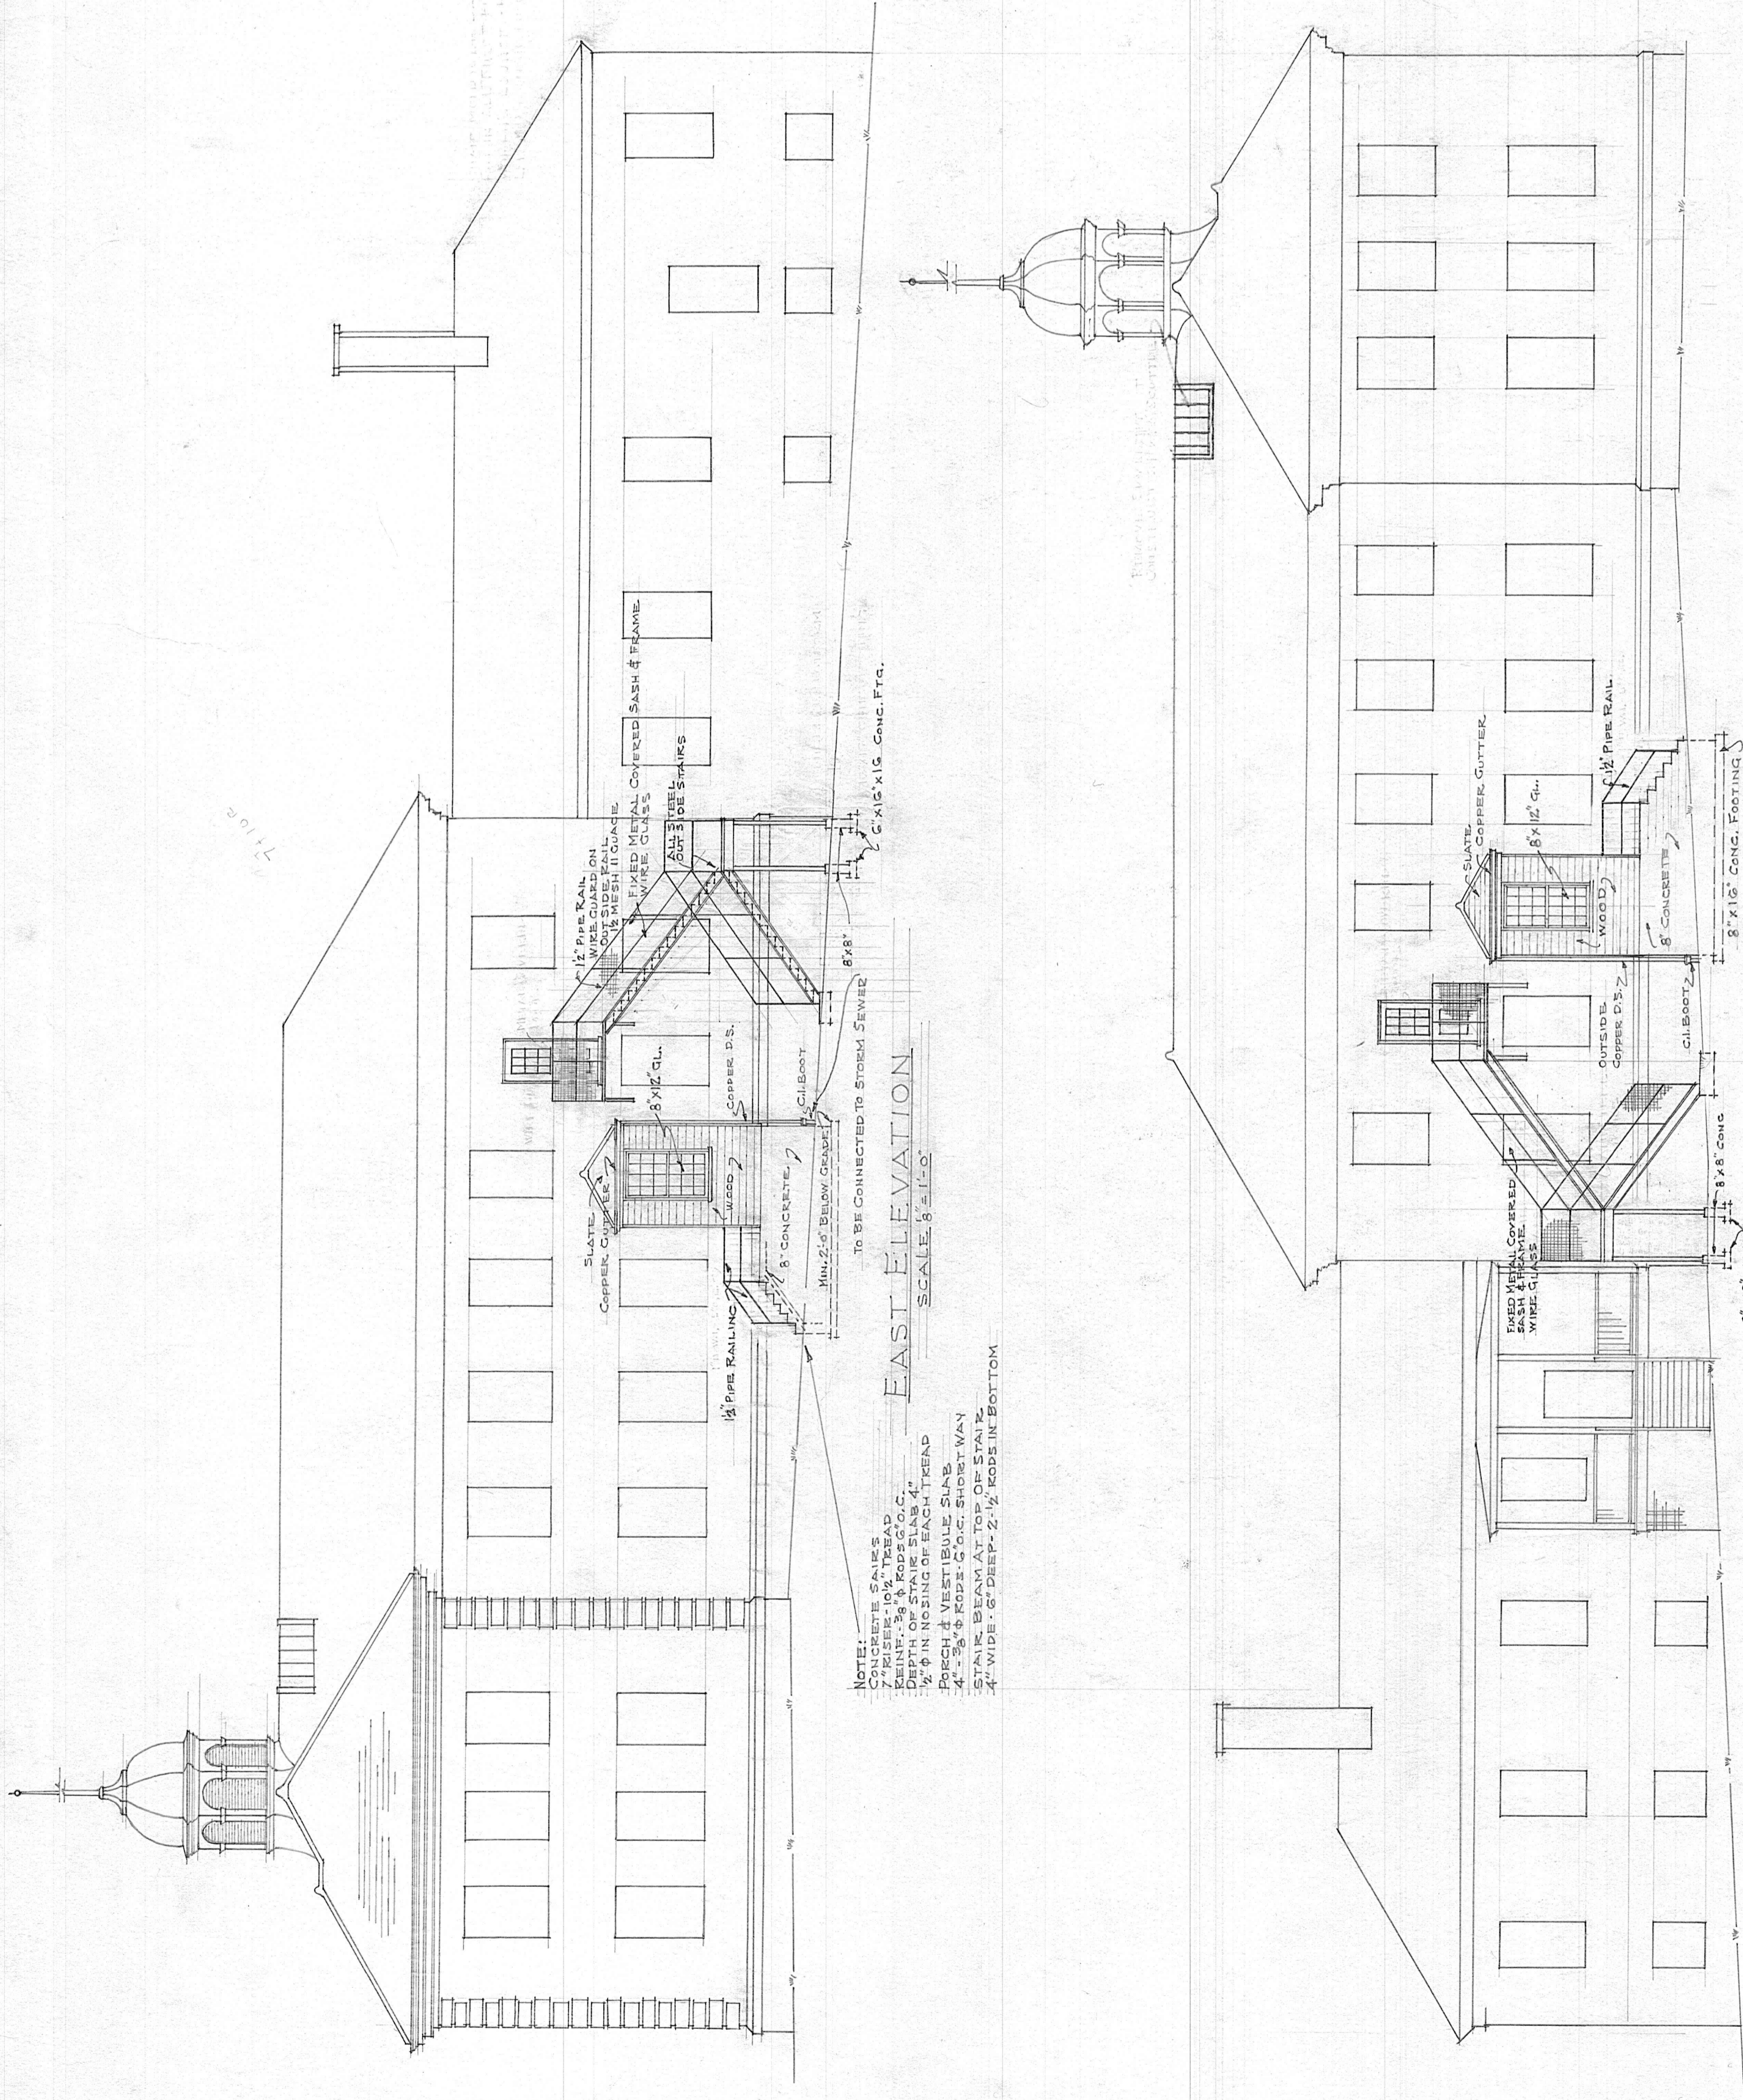


NOTE: ALL SCALES
 7" PIPES: 10" TREAD
 2" RISER: 8" ROPS C.O.C.
 1" DIA. NO. 10 WIRE GALV.
 1/2" DIA. NO. 10 WIRE GALV.
 PORCH & VESTIBULE SLABS
 4" x 8" ROPS C.O.C. SHORT WAY
 STAIR BEAM AT TOP OF STAIR
 4" WIDE x 6" DEEP x 2 1/2" ROPS IN BOTTOM

TO BE CONNECTED TO STORM SEWER


EAST ELEVATION
 SCALE: 3/4" = 1'-0"

WEST ELEVATION
 SCALE: 3/4" = 1'-0"

ALTERATIONS TO ADMINISTRATION	
BUILDING OF CHAPEL	
PRESBYTERIAN ORPHANS HOME	
LYNCHBURG, VIRGINIA	
PENDLETON S. CLARK, ARCHITECT	
LYNCHBURG, VA.	
ELEVATIONS	
DATE PREPARED	SCALE
APR 1910	3/4" = 1'-0"
DRAWN BY	CHECKED
C.L.V.	W.E.C.N.
2	

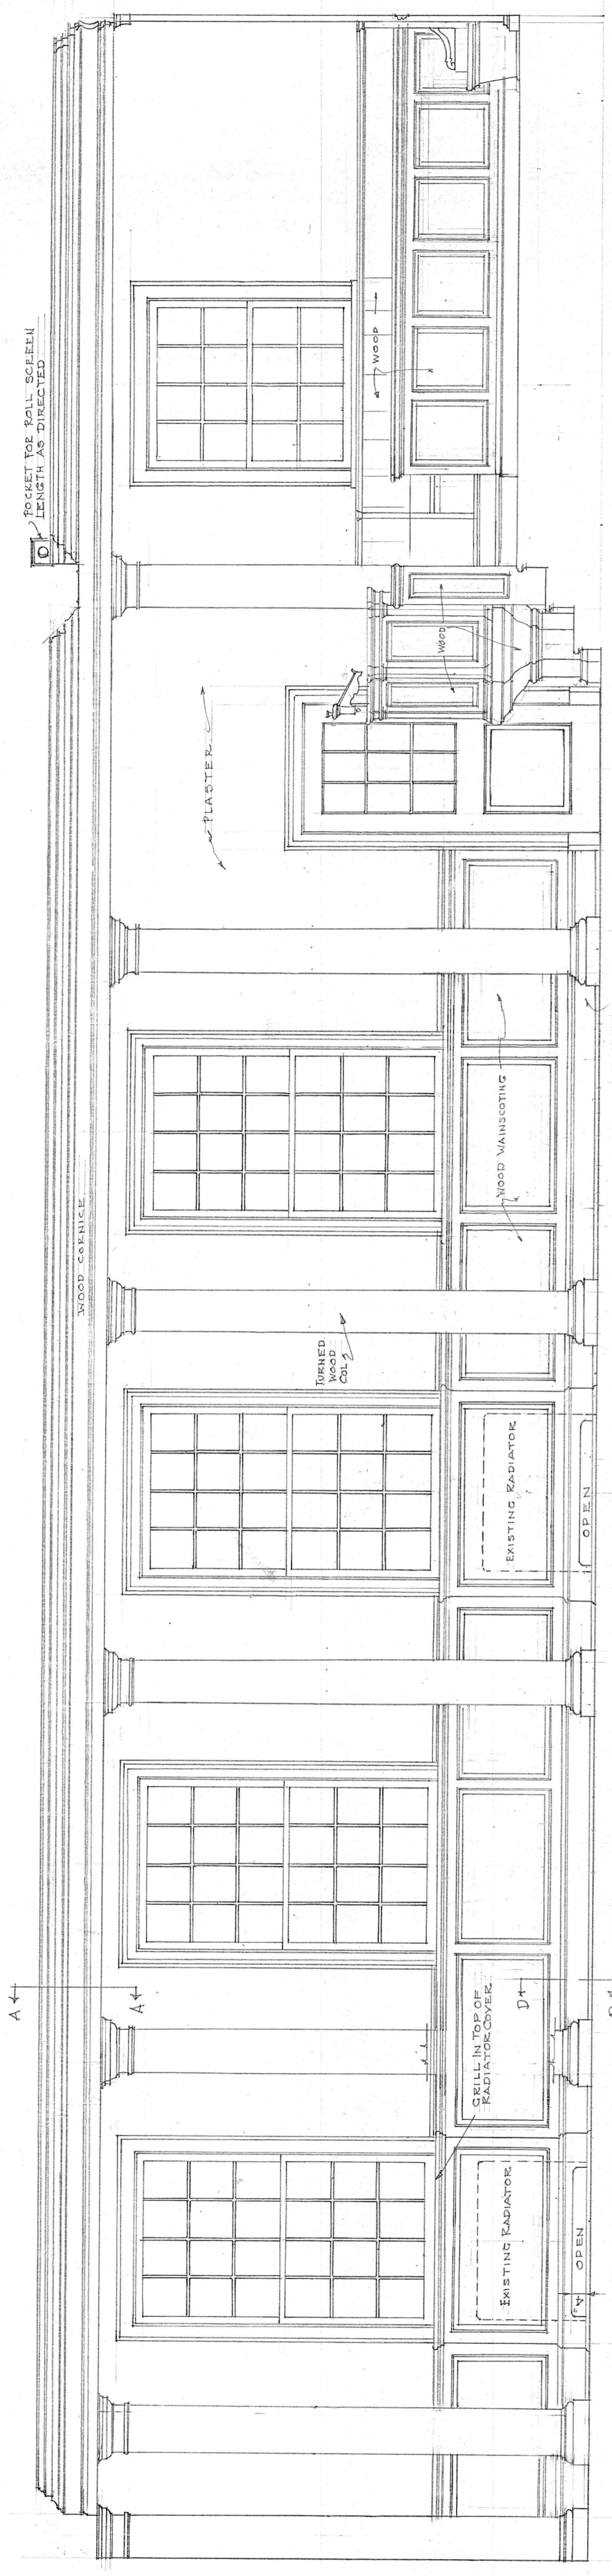

SECTION A-A OF CHAPEL
SCALE 1/2" = 1'-0"

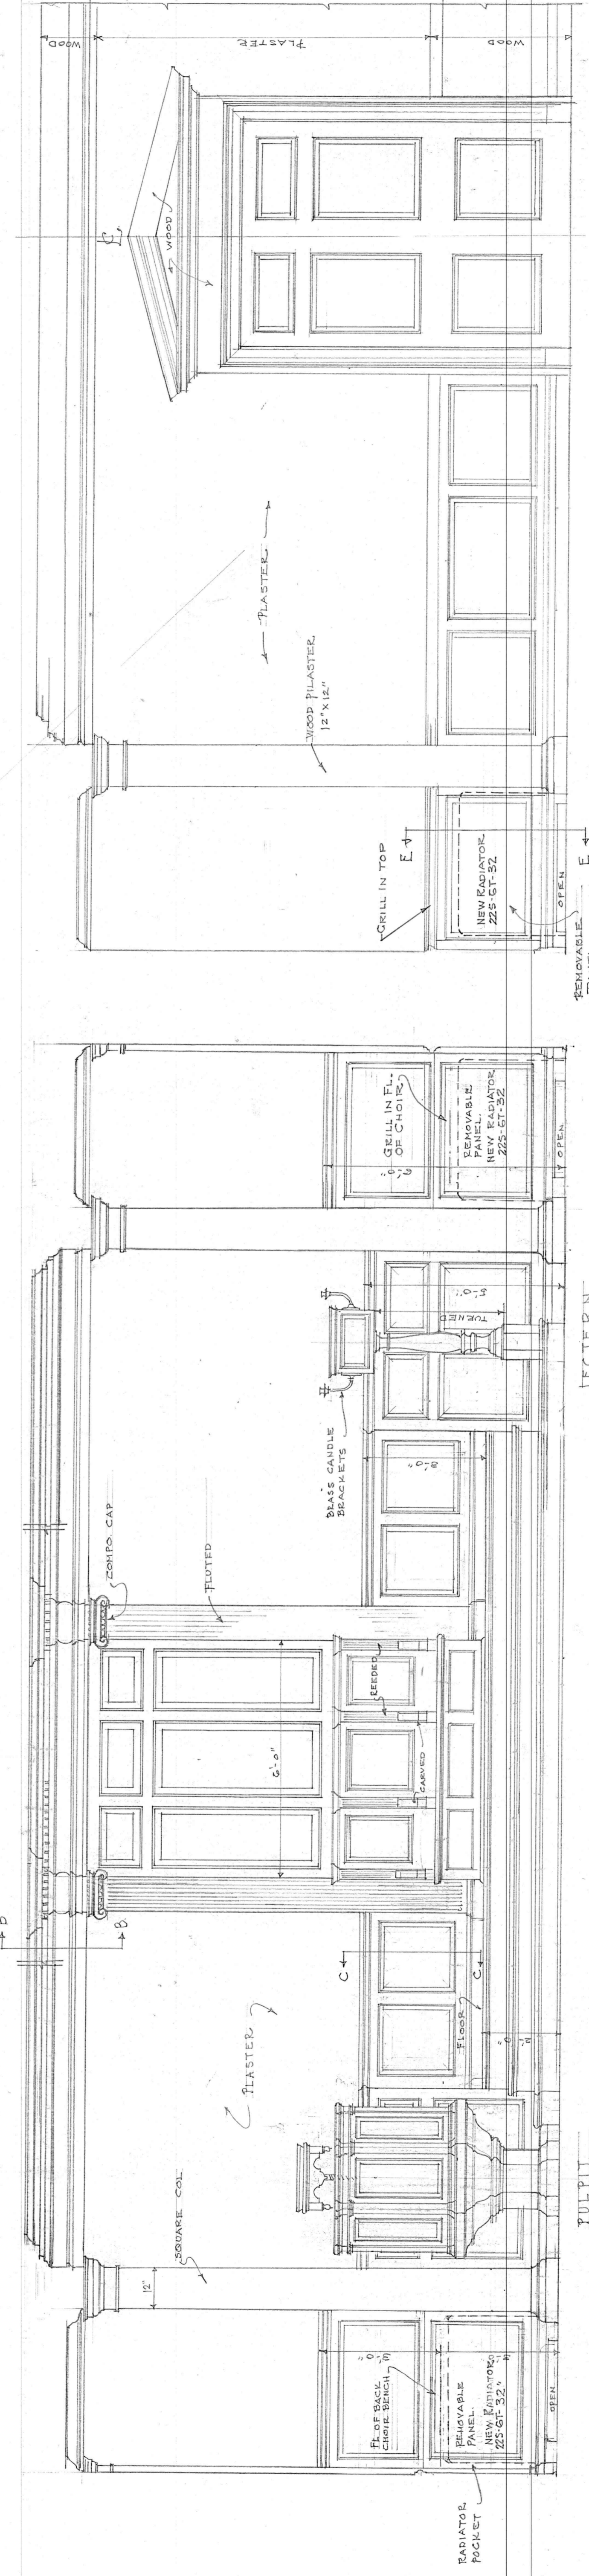

SECTION B-B OF CHAPEL
SCALE 1/2" = 1'-0"


SECTION C-C CHAPEL
SCALE 1/2" = 1'-0"

ALTERATIONS TO ADMINISTRATION
BUILDING & CHAPEL
PRESBYTERIAN ORPHANS' HOME
LYNCHBURG, VIRGINIA


PENDLETON S. CLARK, ARCHITECT
LYNCHBURG, VA.

SECTIONS


DATE: AUG. 1950	SCALE 1/2" = 1'-0"	CHECKED W.F.N.	3
REVISED 7	DRWN BY: C.L.V.	W.F.N.	

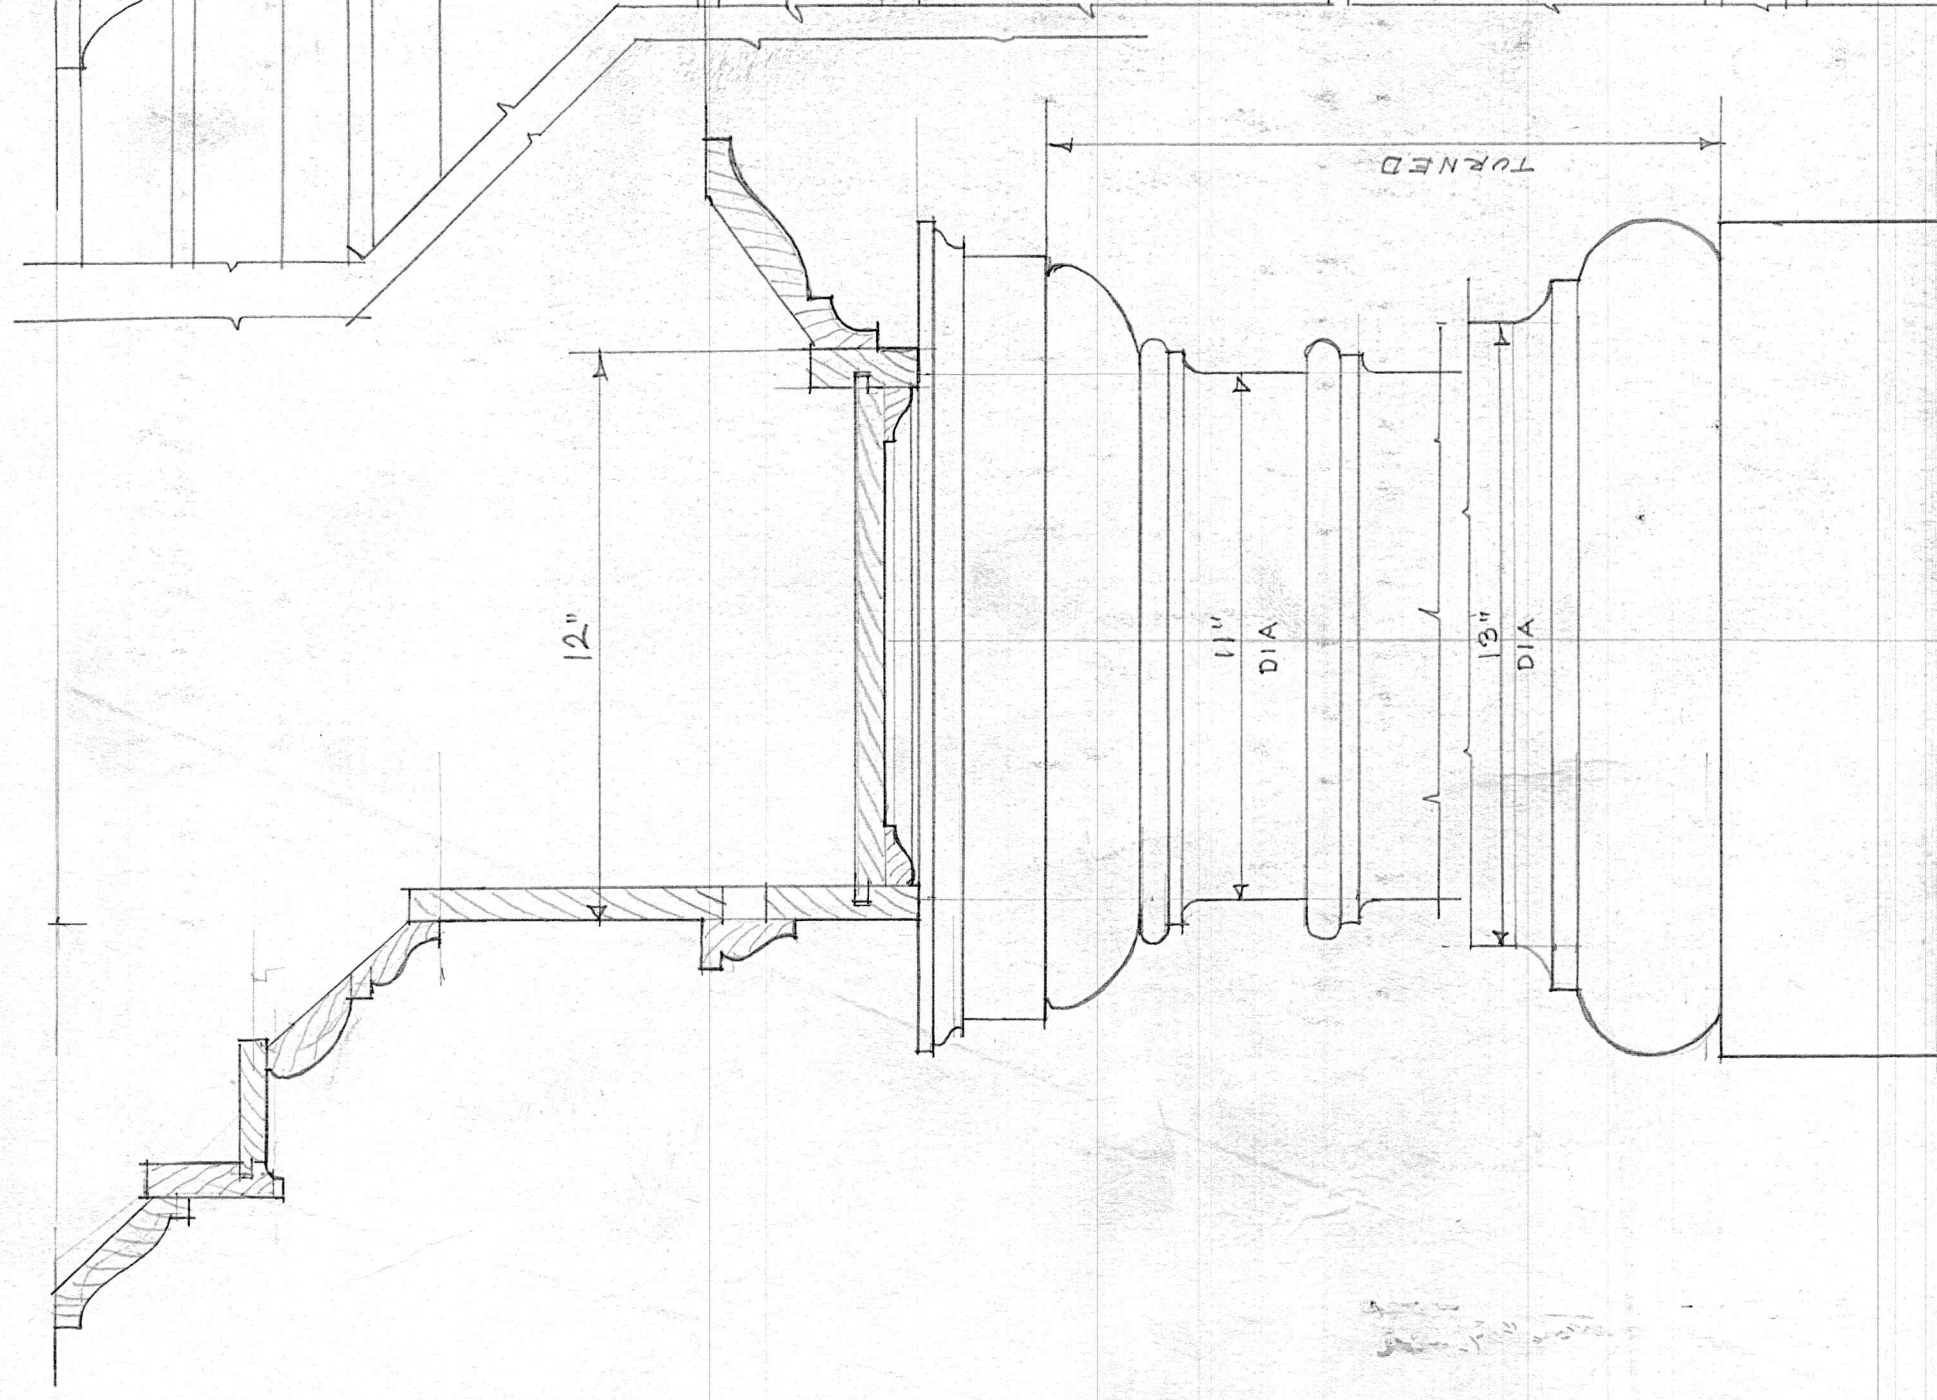


SECTION A-A

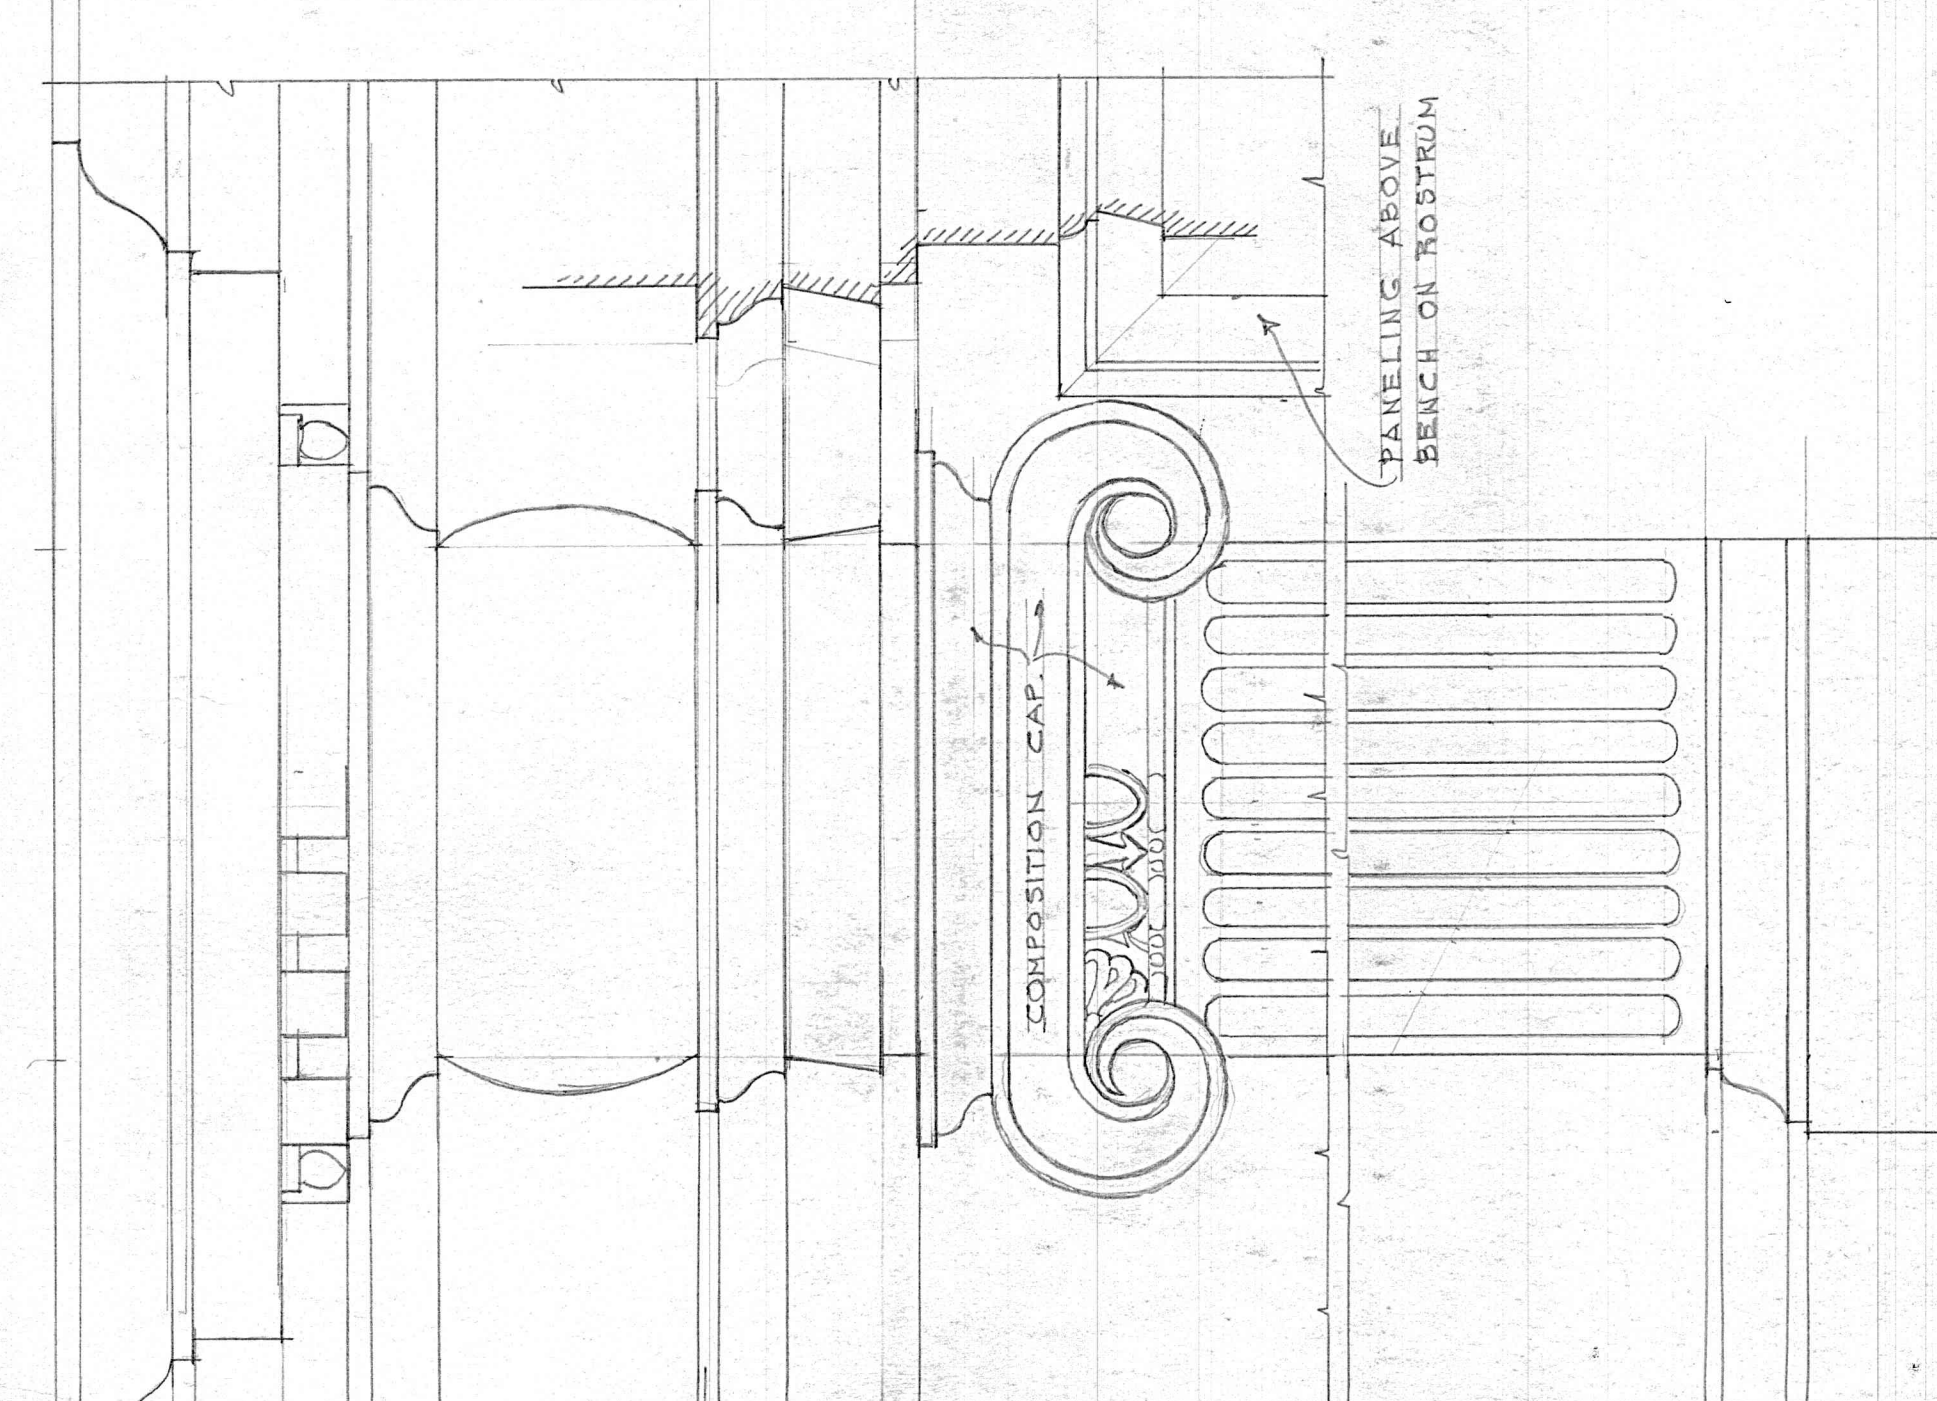


ELEV. DETAIL, PILASTER AND CORNICE IN ROSTRUM

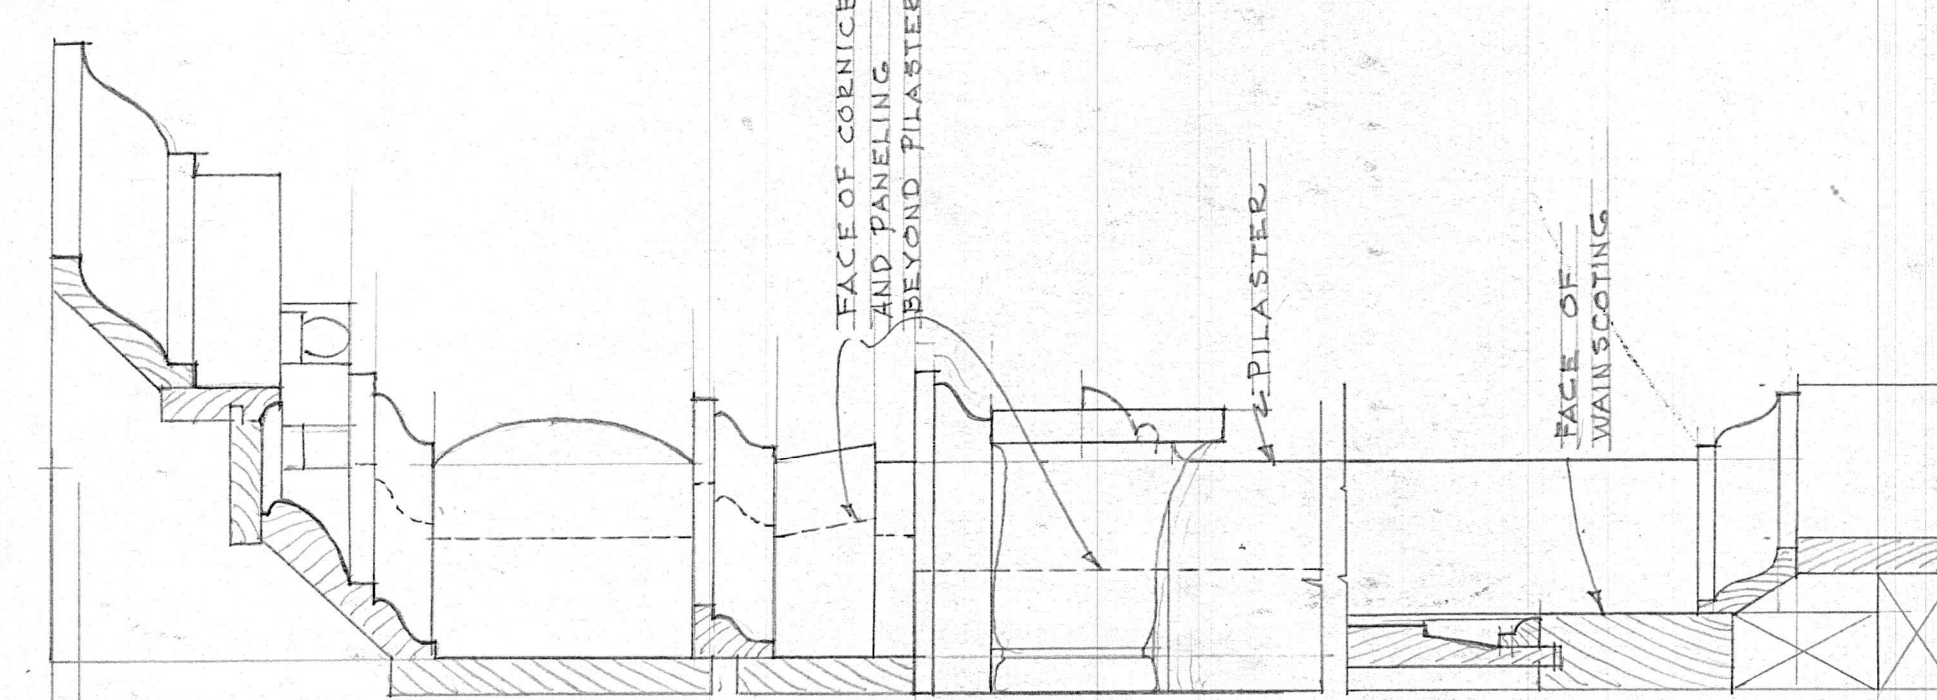

SECTION B-B

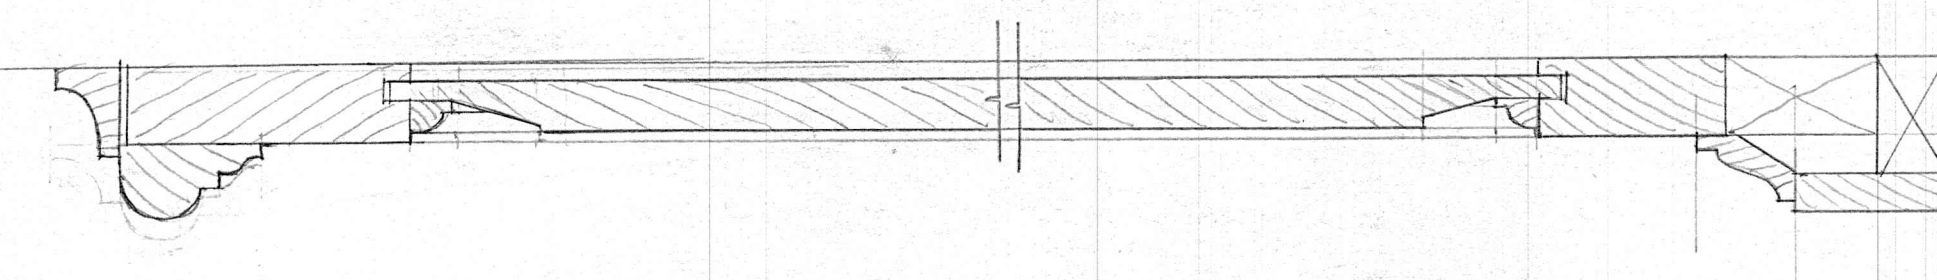

SECTION C-C
WAINSCOTING IN ROSTRUM

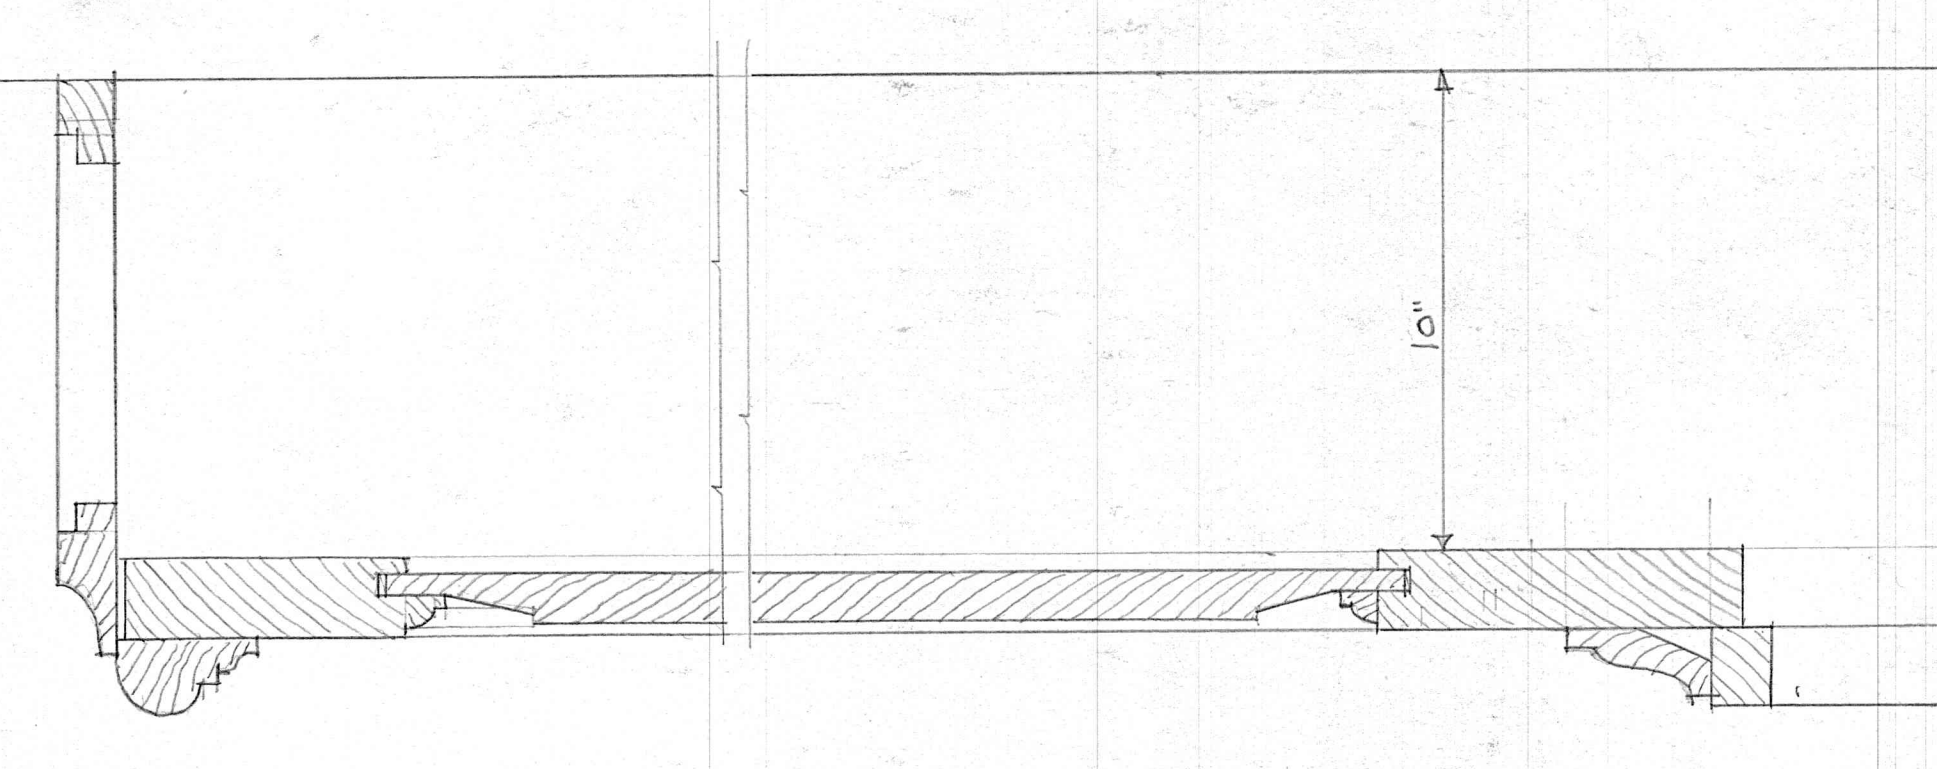

SECTION E-E
CONNECTOR SOCKET

DETAILS OF WOODWORK IN CHAPEL
SCALE 3/8" = 1'-0"


ALTERATIONS TO ADMINISTRATION BUILDING & CHAPEL, PRESBYTERIAN ORPHANS HOME, LYNCHBURG, VIRGINIA

PENDLETON S. CLARK, ARCHITECT
LYNCHBURG, VA.


DATE: AUG. 1950
REVISED: 1

DRWN BY: W.A.S. SCALE: 3/8" = 1'-0" CHECKED: W.P.N.

DETAILS

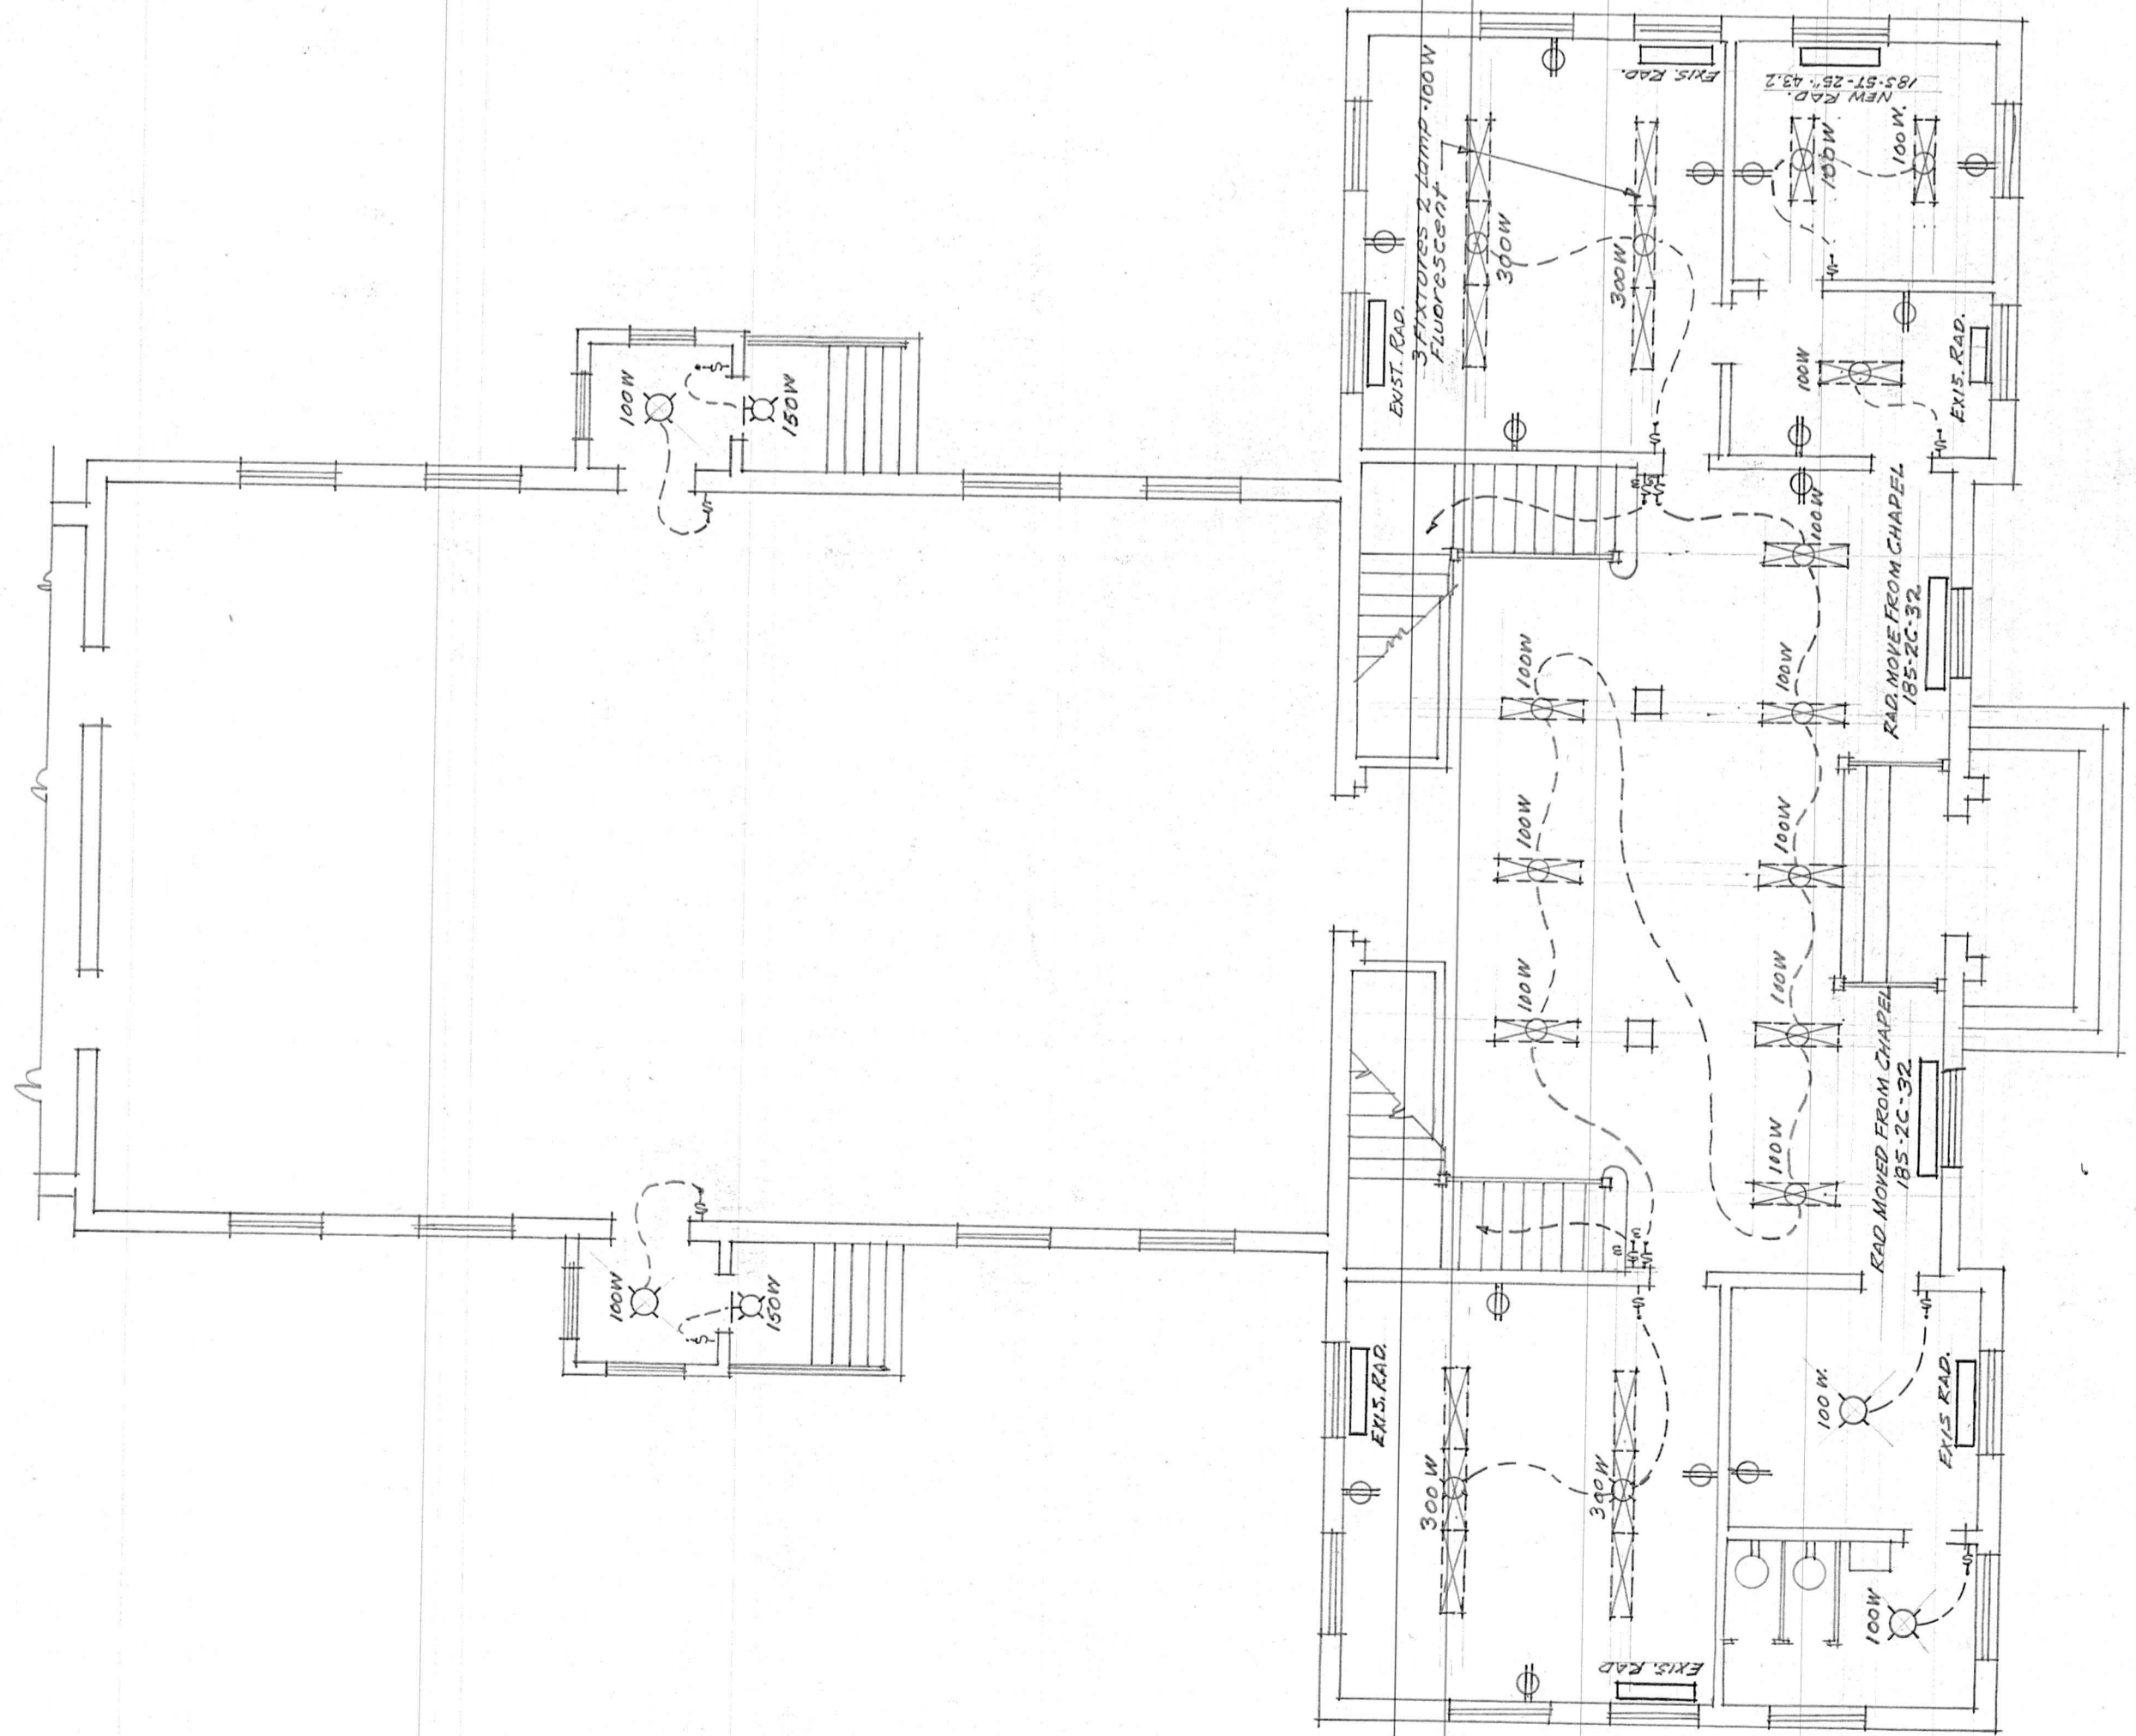

FIRST FLOOR PLAN

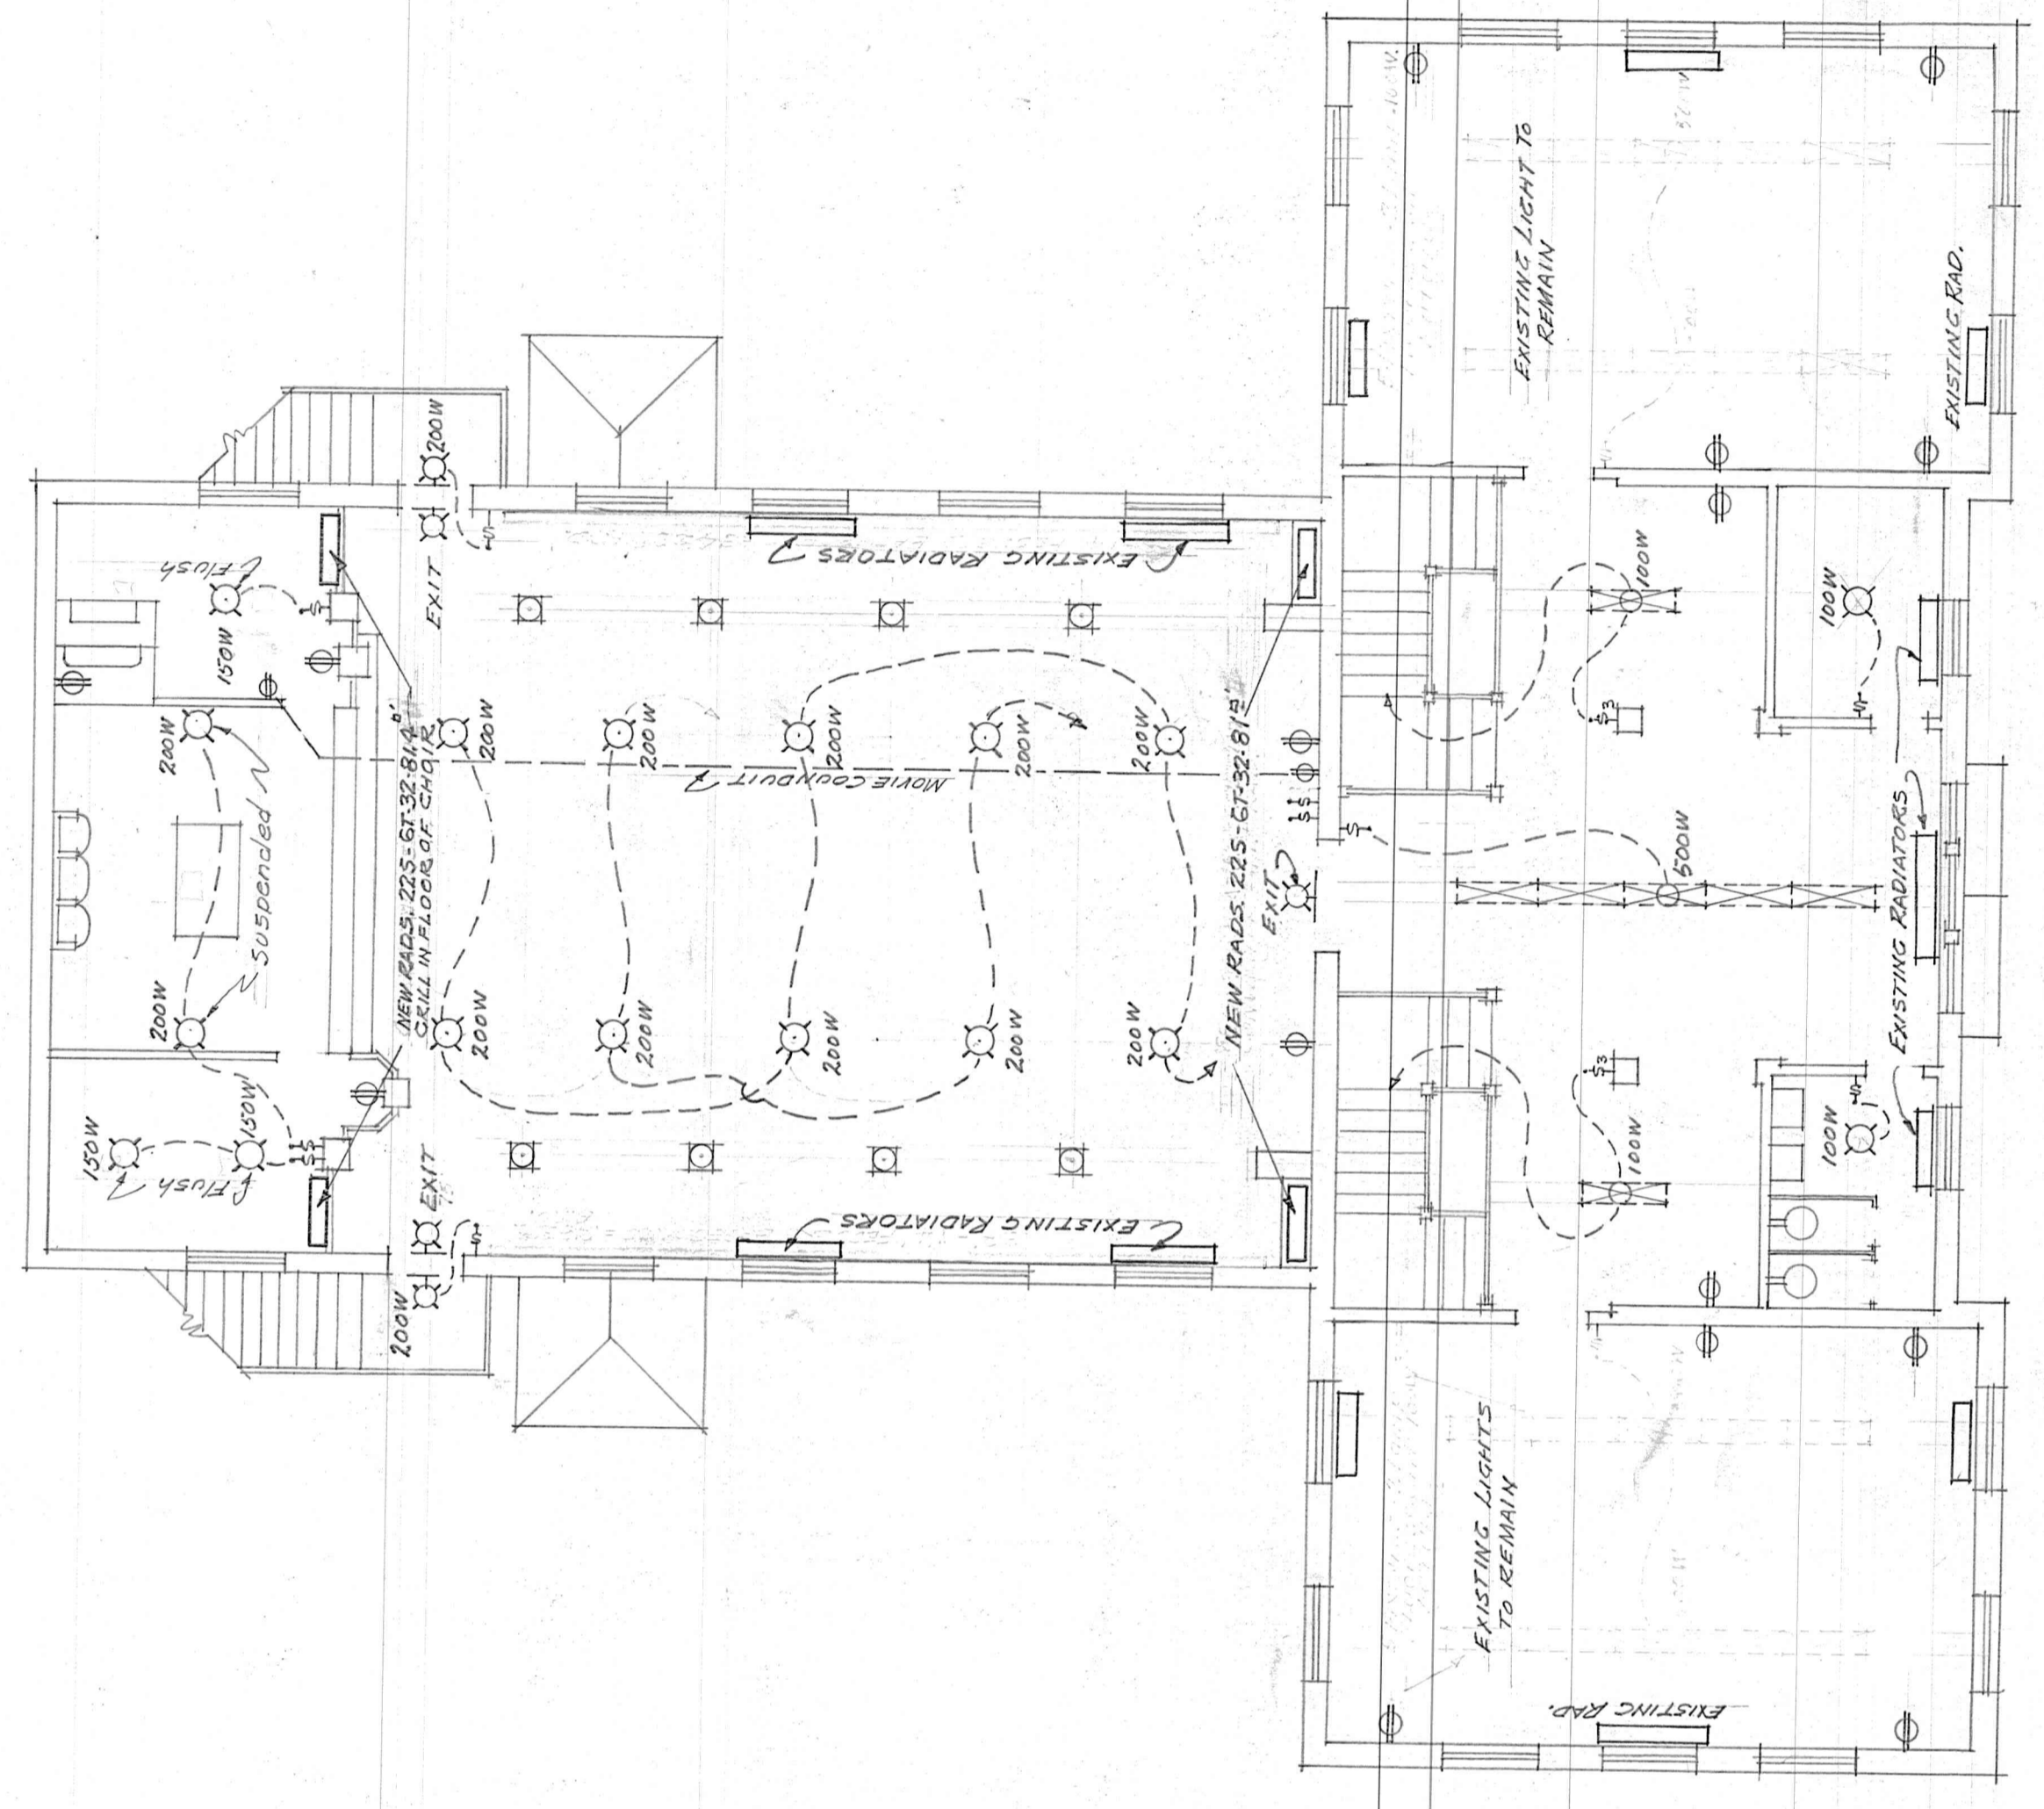

SECOND FLOOR PLAN


- SYMBOLS**
- ⊙ 2 Lamp Fluorescent Fixture 100WATTS
 - Ceiling outlet
 - Wall outlet
 - ⊕ Duplex Convenience outlet 200WATTS
 - ⊖ Single Pole Switch
 - ⊗ Three Way Switch
 - MOVIE CONDUIT

ALTERATIONS TO ADMINISTRATION BUILDING & CHAPEL PRESBYTERIAN ORPHANS HOME LYNCHBURG, VIRGINIA

PENDLETON S. CLARK, ARCHITECT LYNCHBURG, VA.

FIRST & SECOND FLOOR PLAN

DATE: SEP 18 1960	ELECTRICAL PLAN	5
REVISED: 11/17/60	BY: W.F.C.N.	CHECKED: W.F.C.N.
DRAWN BY: J.S.C.	SCALE: 1/8" = 1'-0"	

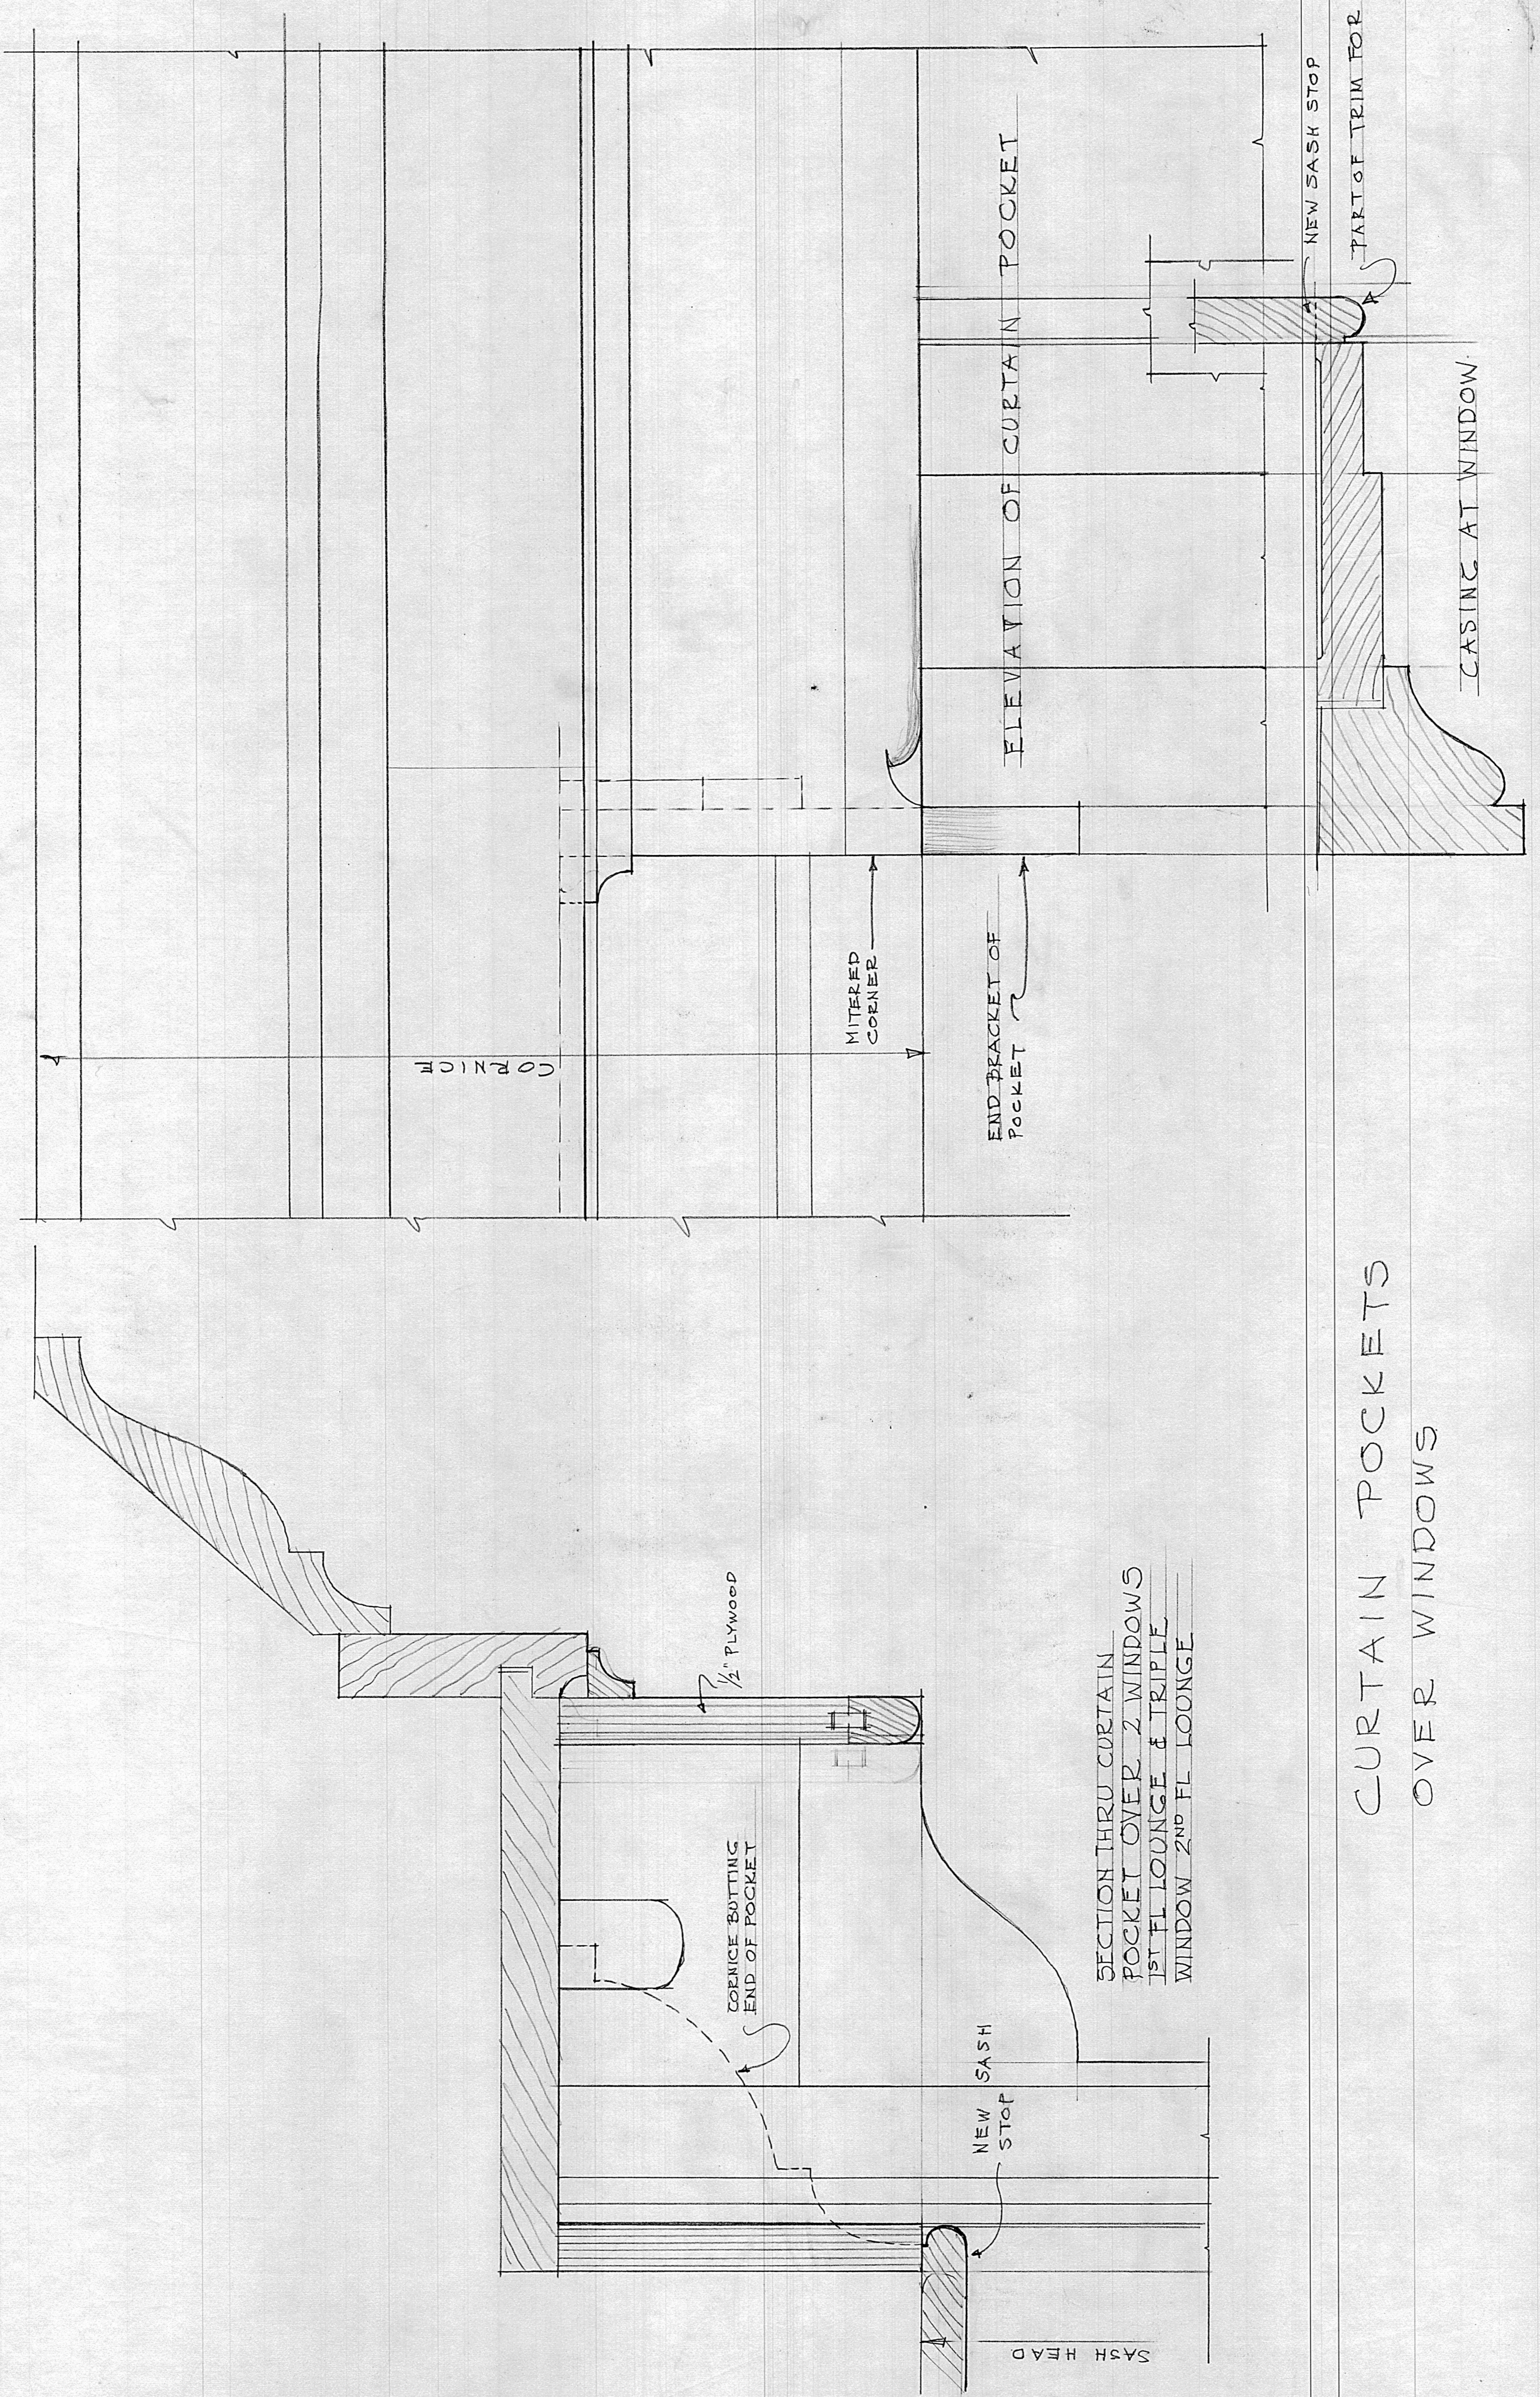

CURTAIN POCKETS
OVER WINDOWS


ALTERATIONS TO ADMINISTRATION
AND CHAPEL
PREBYTERIAN ORPHANS HOME.

PENDLETON S. CLARK, ARCHITECT
LYNCHBURG, VA.

DATE: 7-3-51
REVISED

DRAWN BY: SCALE: FULL SIZE
CHECKED:

M-2

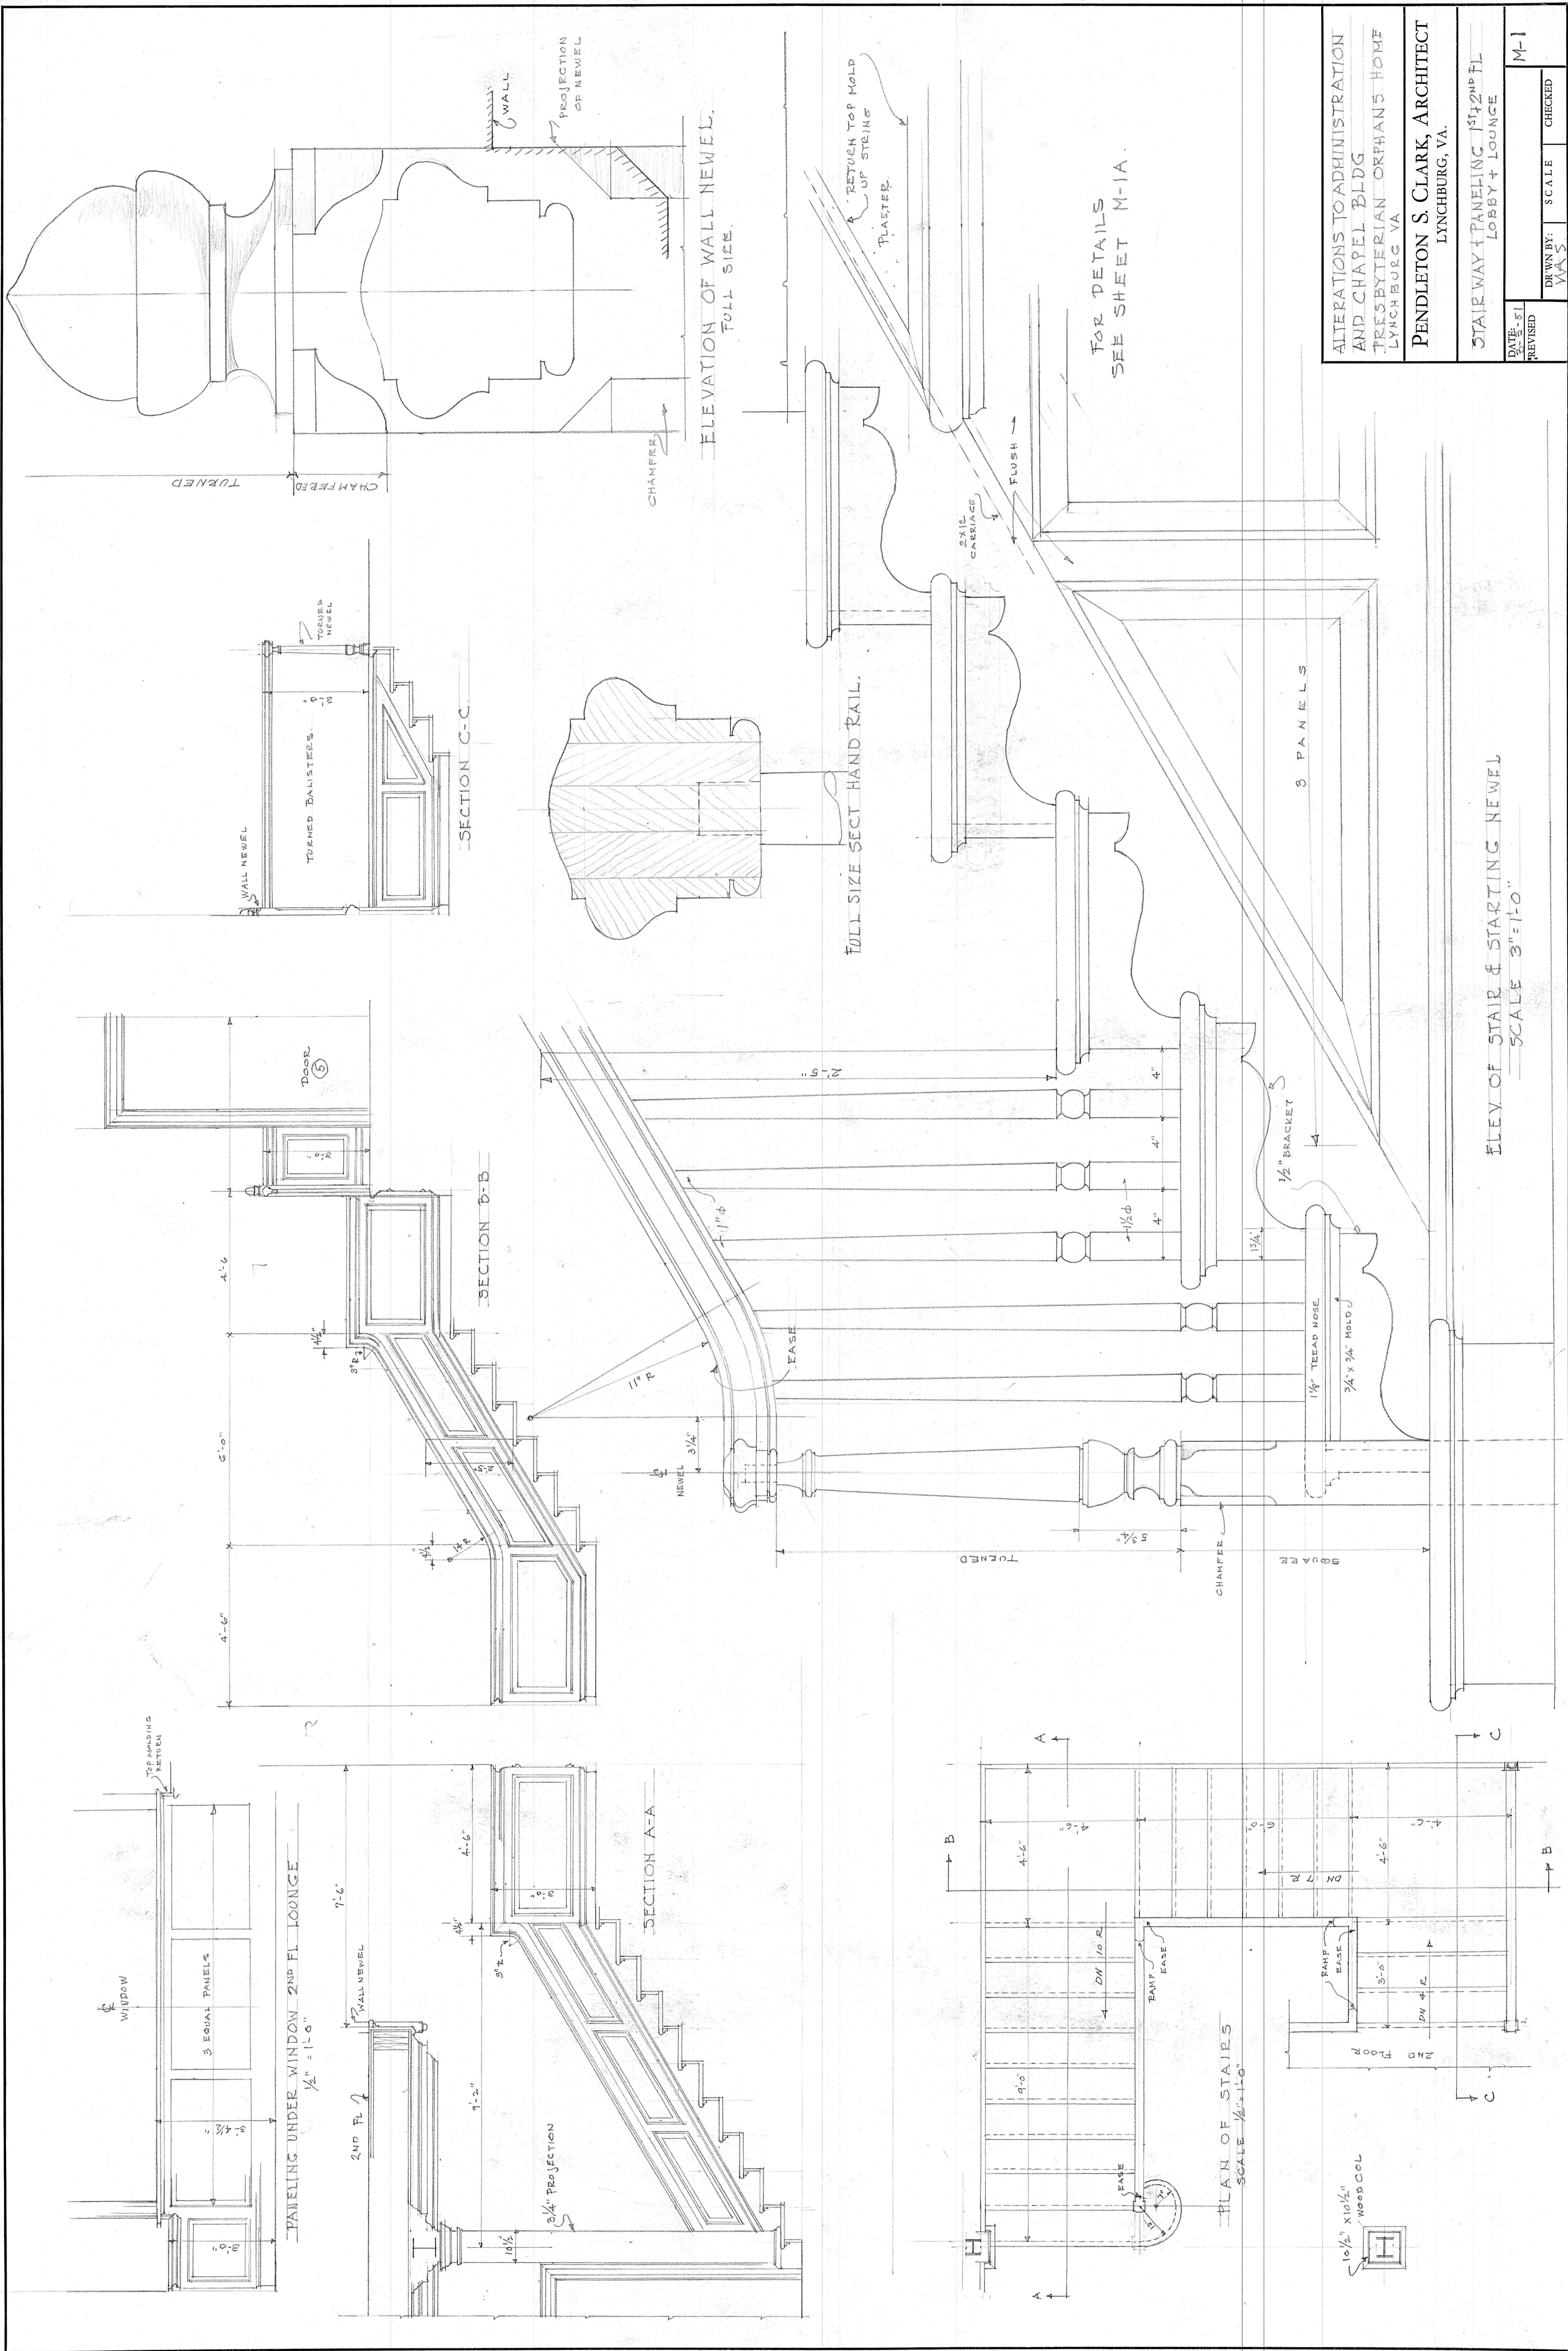

FOR DETAILS
SEE SHEET M-1A.

ALTERATIONS TO ADMINISTRATION AND CHAPEL BLDG PRESBYTERIAN ORPHANS HOME LYNCHBURG VA	
PENDLETON S. CLARK, ARCHITECT LYNCHBURG, VA.	
DATE: 3-2-51	REVISIONS
STAIRWAY PANELING 1st & 2nd FL LOBBY + LOUNGE	SCALE
M-1	CHECKED
DRWN BY: V.A.S.	SCALE

ELEV OF STAIR & STARTING NEWEL
SCALE 3" = 1'-0"

PLAN OF STAIRS
SCALE 1/2" = 1'-0"

ELEVATION OF WALL NEWEL,
FULL SIZE.

SECTION C-C

SECTION B-B

SECTION A-A

PANELING UNDER WINDOW 2ND FL LOUNGE
1/2" = 1'-0"

WINDOW

3 EQUAL PANELS

2ND FL

WALL NEWEL

3/4" PROJECTION

1'-2"

4'-6"

3"

1/2"

1/2"


1/2"

1/2"

1/2"

1/2"

1/2"

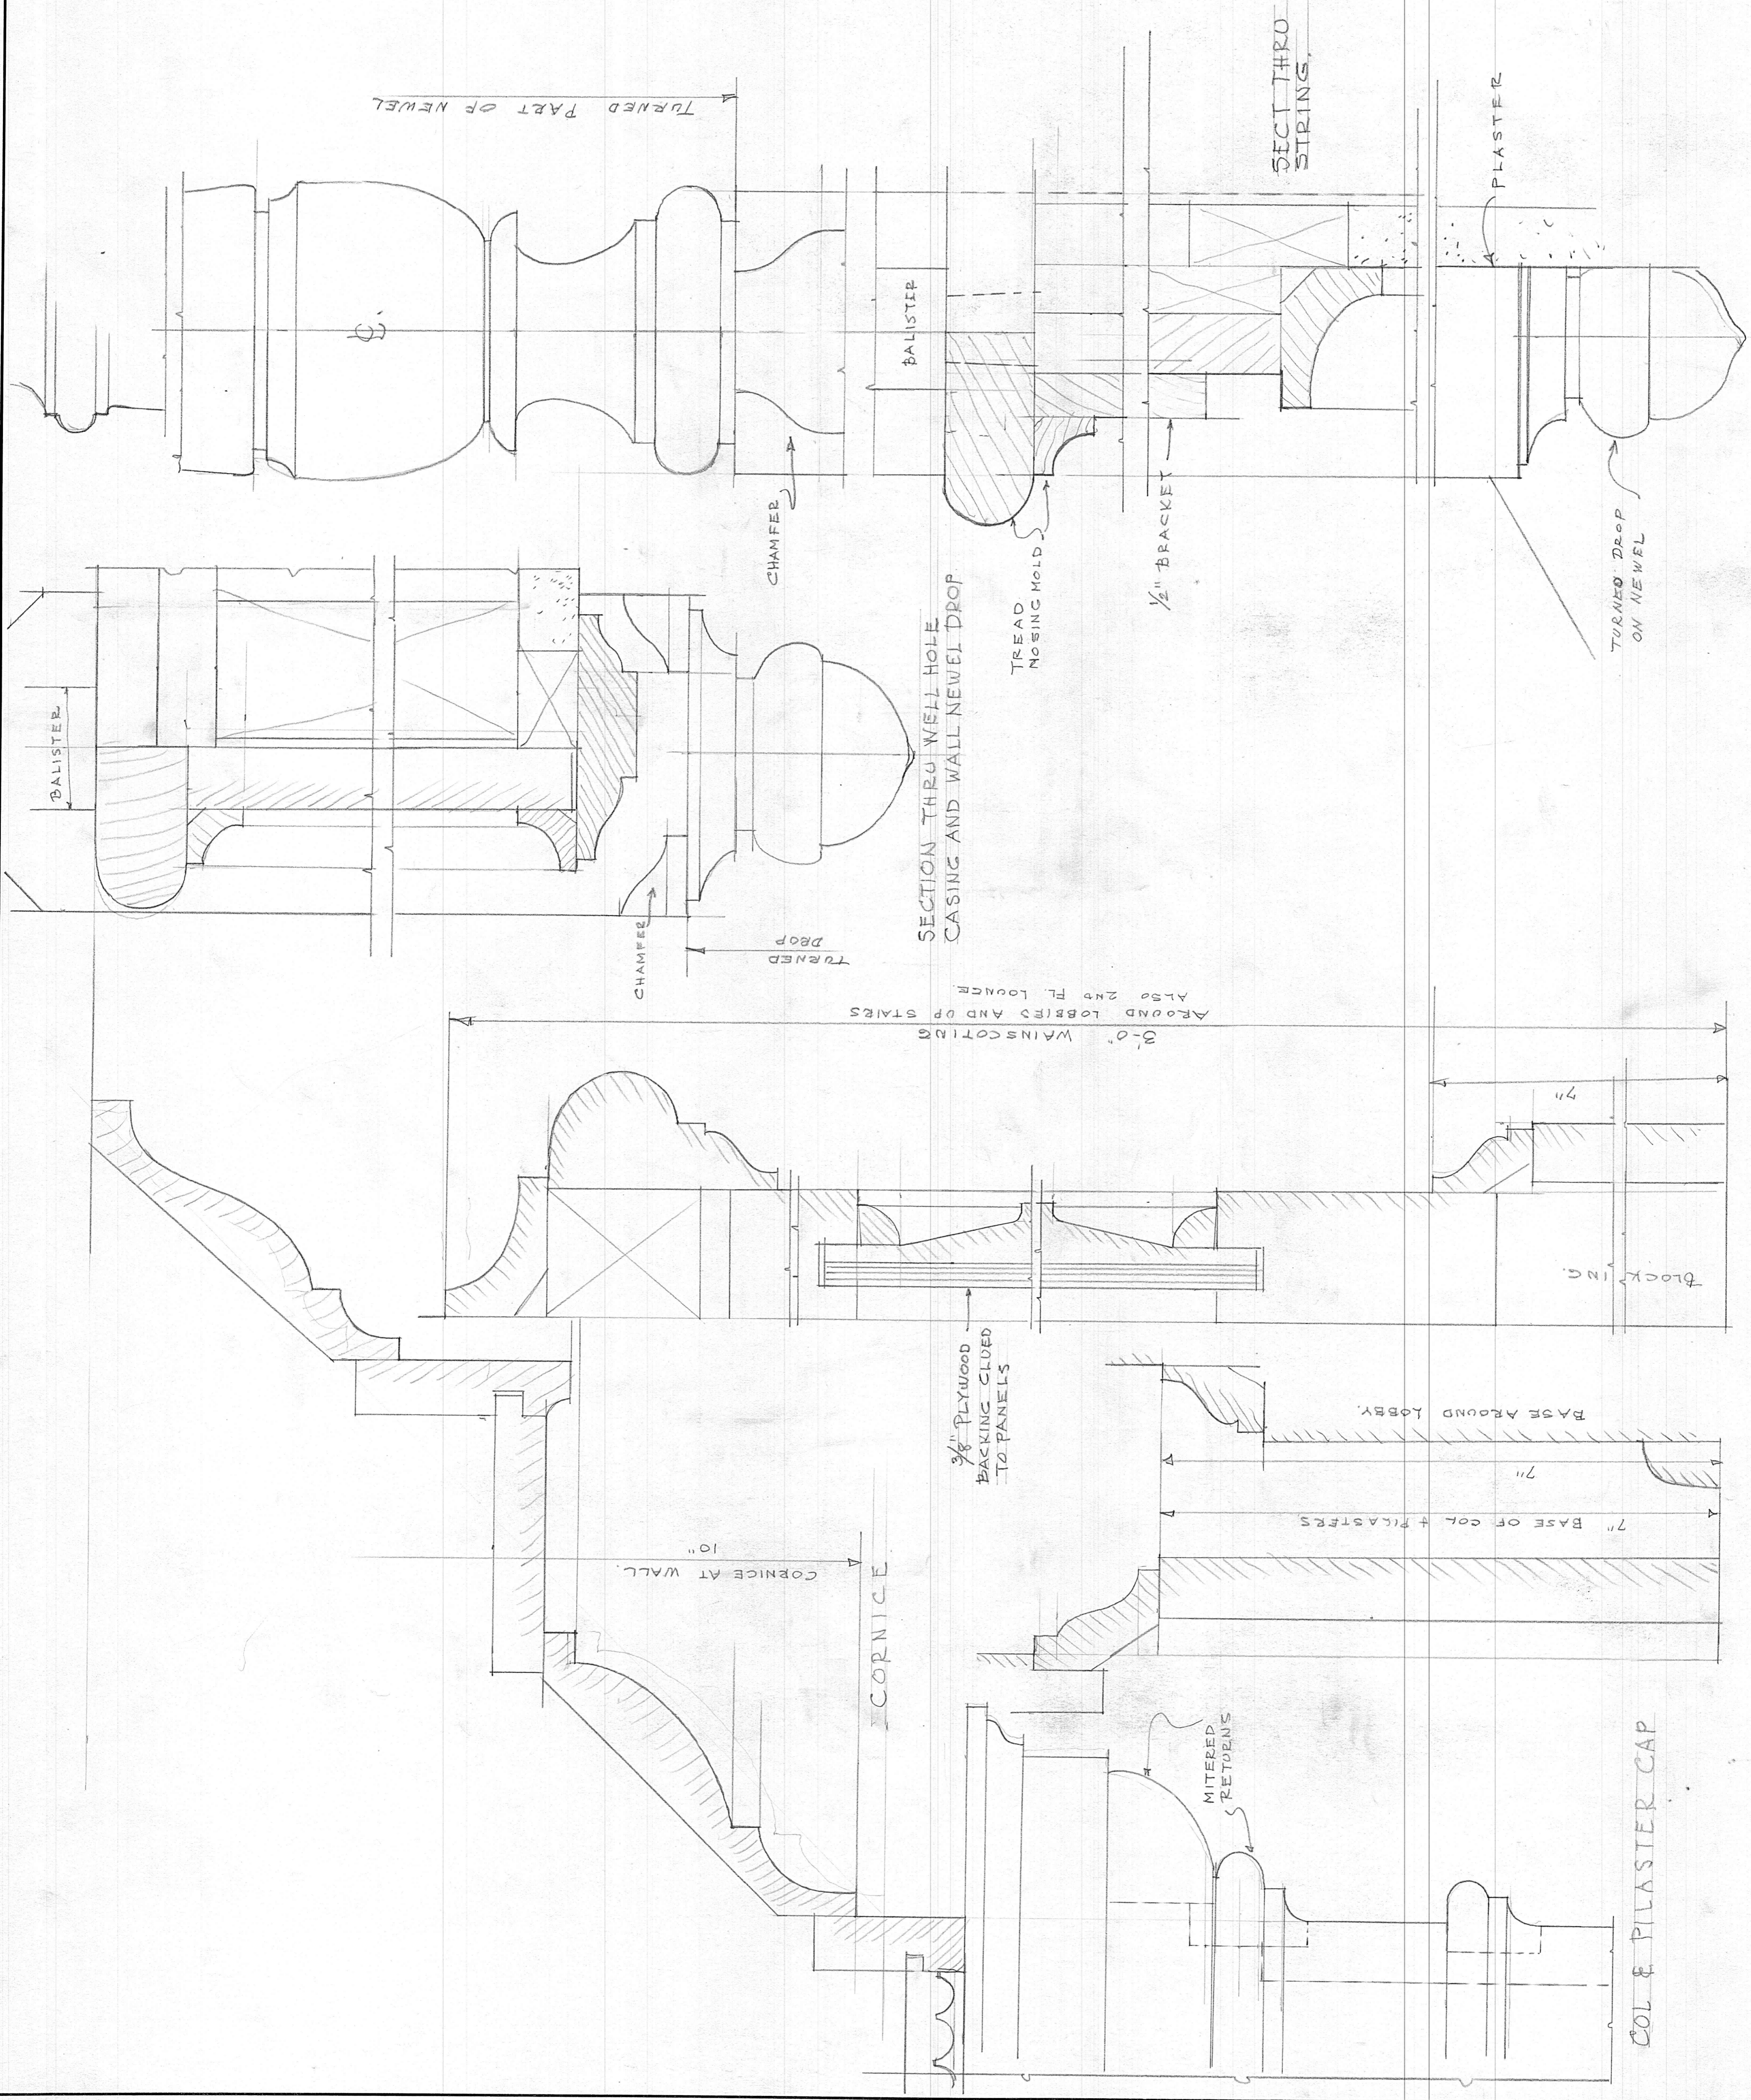

ALTERATIONS TO ADMINISTRATION
AND CHAPEL BLDG
PRESBYTERIAN ORPHANS HOME
LYNCHBURG VA

PENDLETON S. CLARK, ARCHITECT
LYNCHBURG, VA.

DETAILS OF SHEET M-1.

DATE: 6/1	SHEET: M-1A
REVISED: J	CHECKED:
DRAWN BY: VMS	SCALE: