


GYMNASIUM
FOR
PRESBYTERIAN ORPHAN'S HOME
LYNCHBURG, VA.

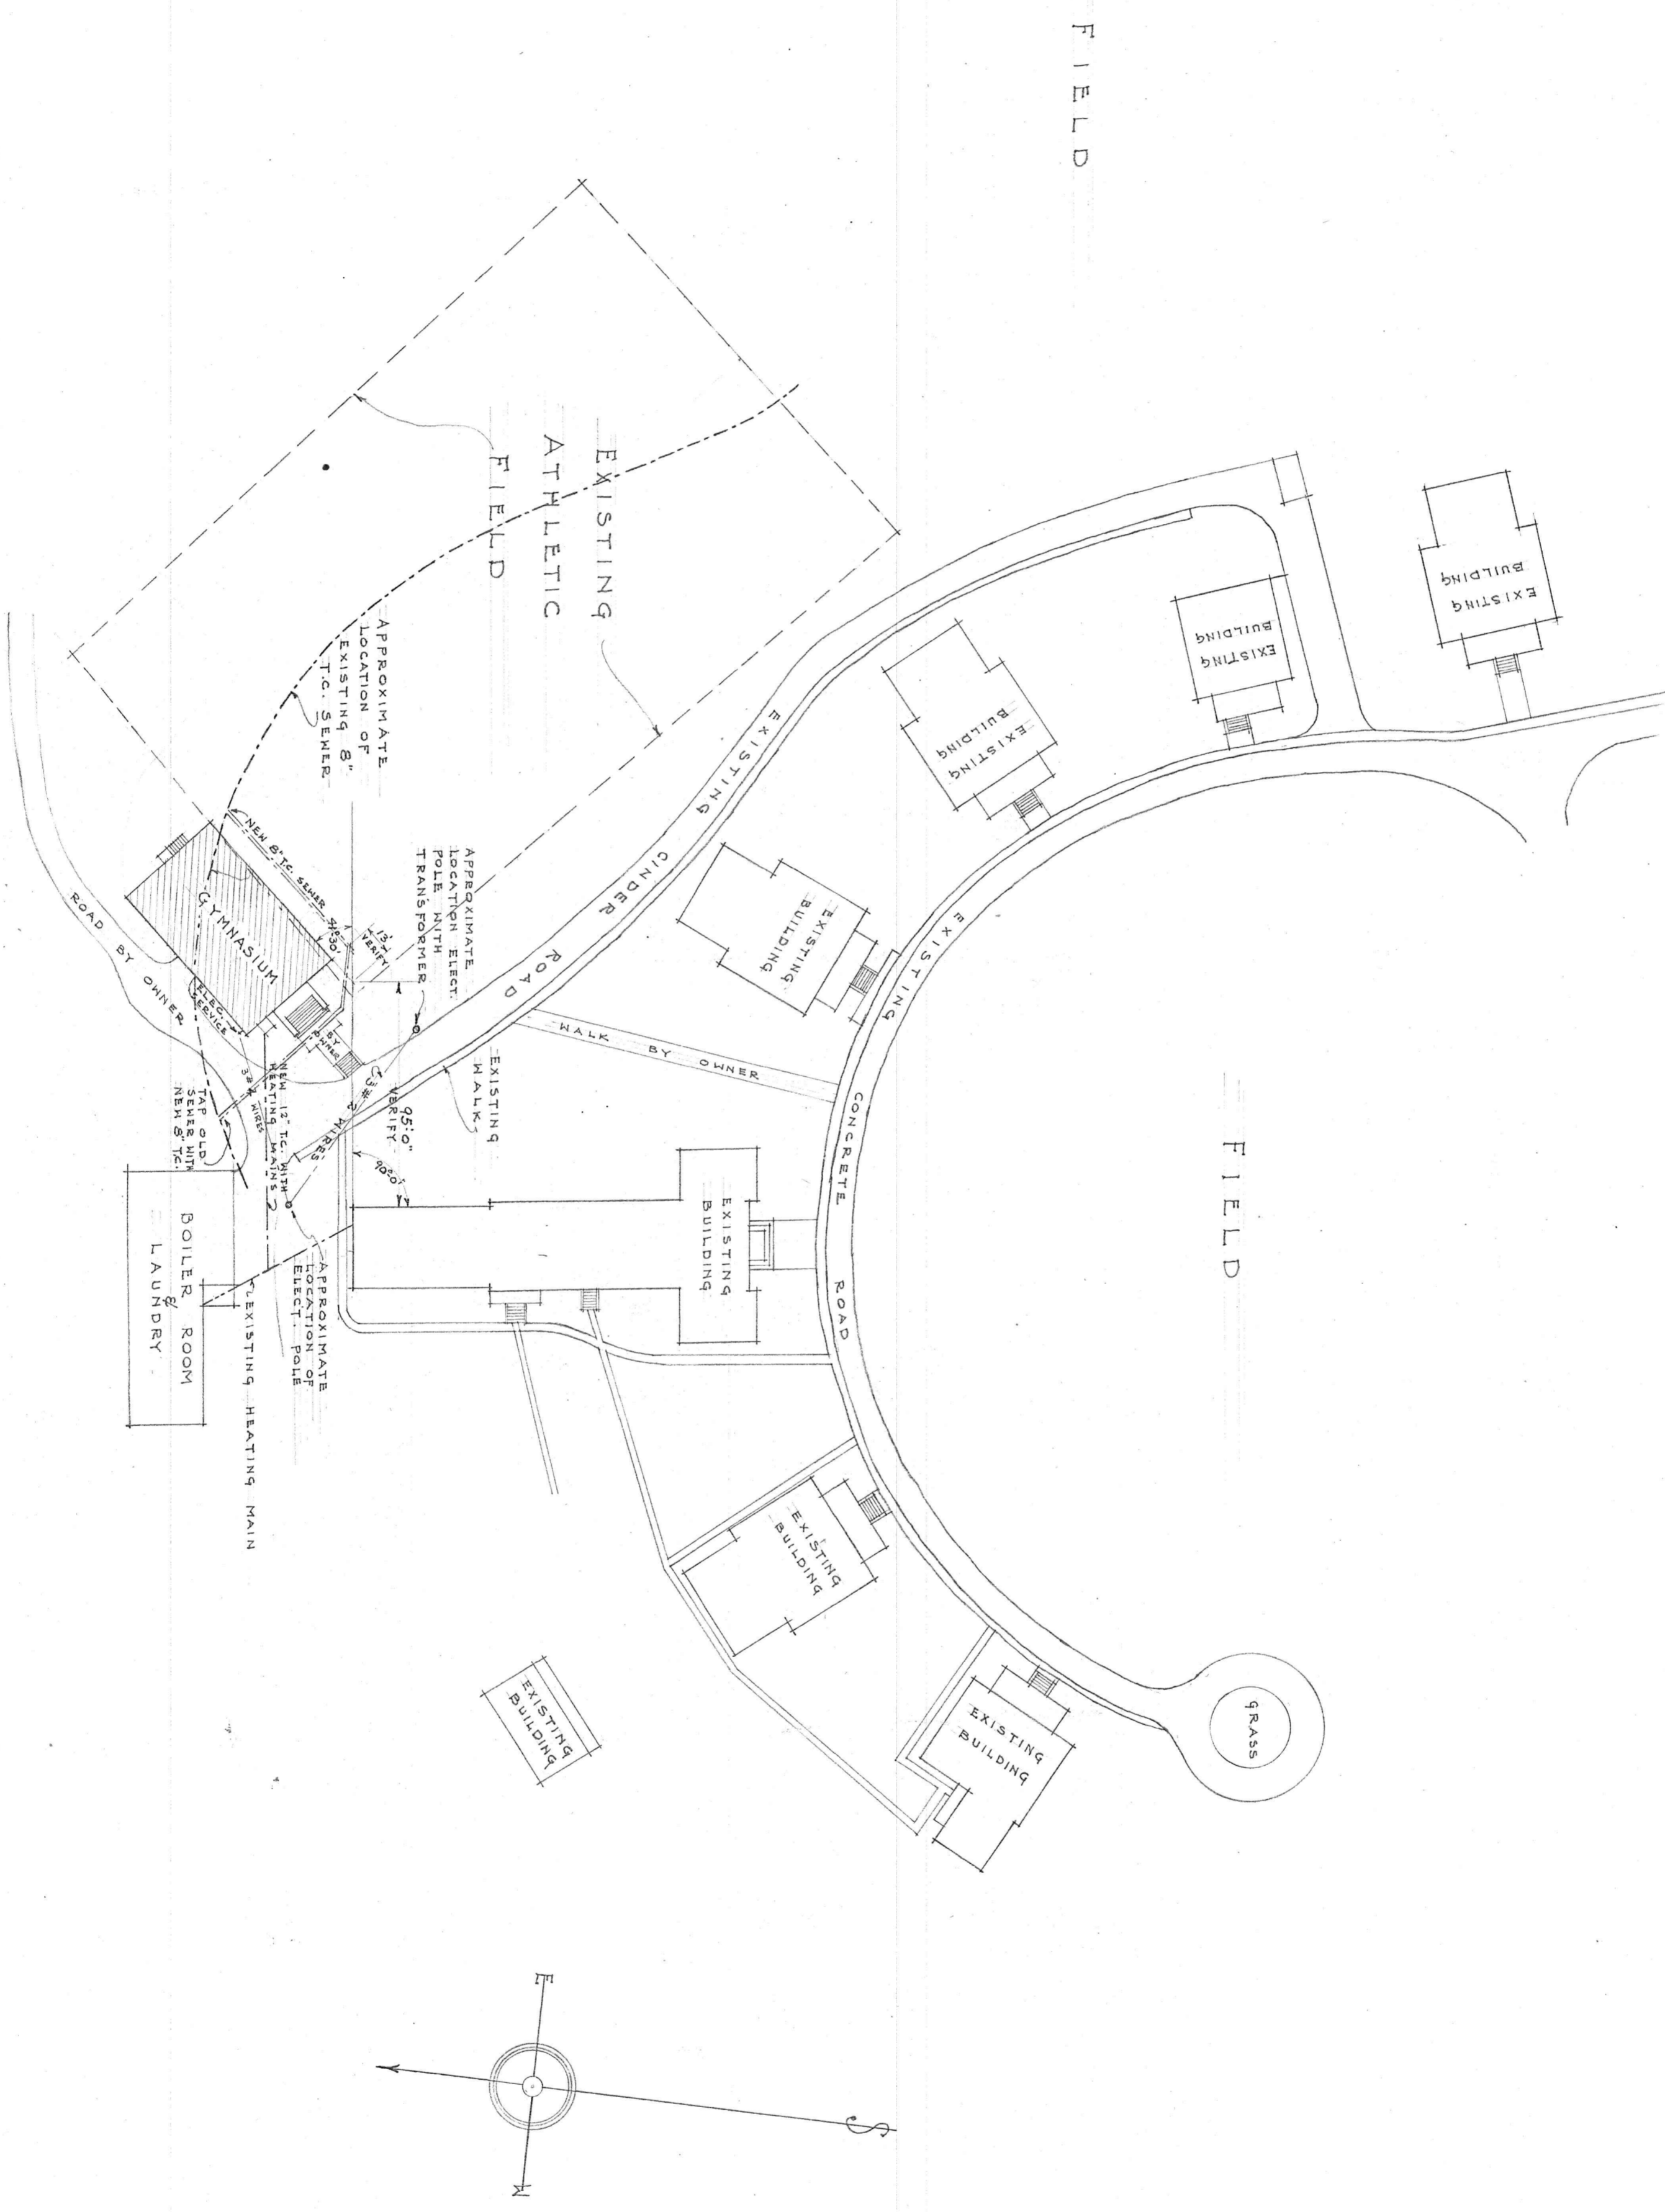


PLAT PLAN
SCALE 1/50" = 1'-0"

APPROVED
BY _____
DATE _____

PENDLETON S. CLARK
ARCHITECT
LYNCHBURG, VA.
APRIL 14, 1939
REVISED MAY 23, 1939

HOOK UP TO EXISTING
SEWER AS SHOWN
ON SHEET NO. 1


RUN 5" T.C. TO SURFACE
AND TURN LOOSE ABOUT
50 FEET FROM BUILDING.

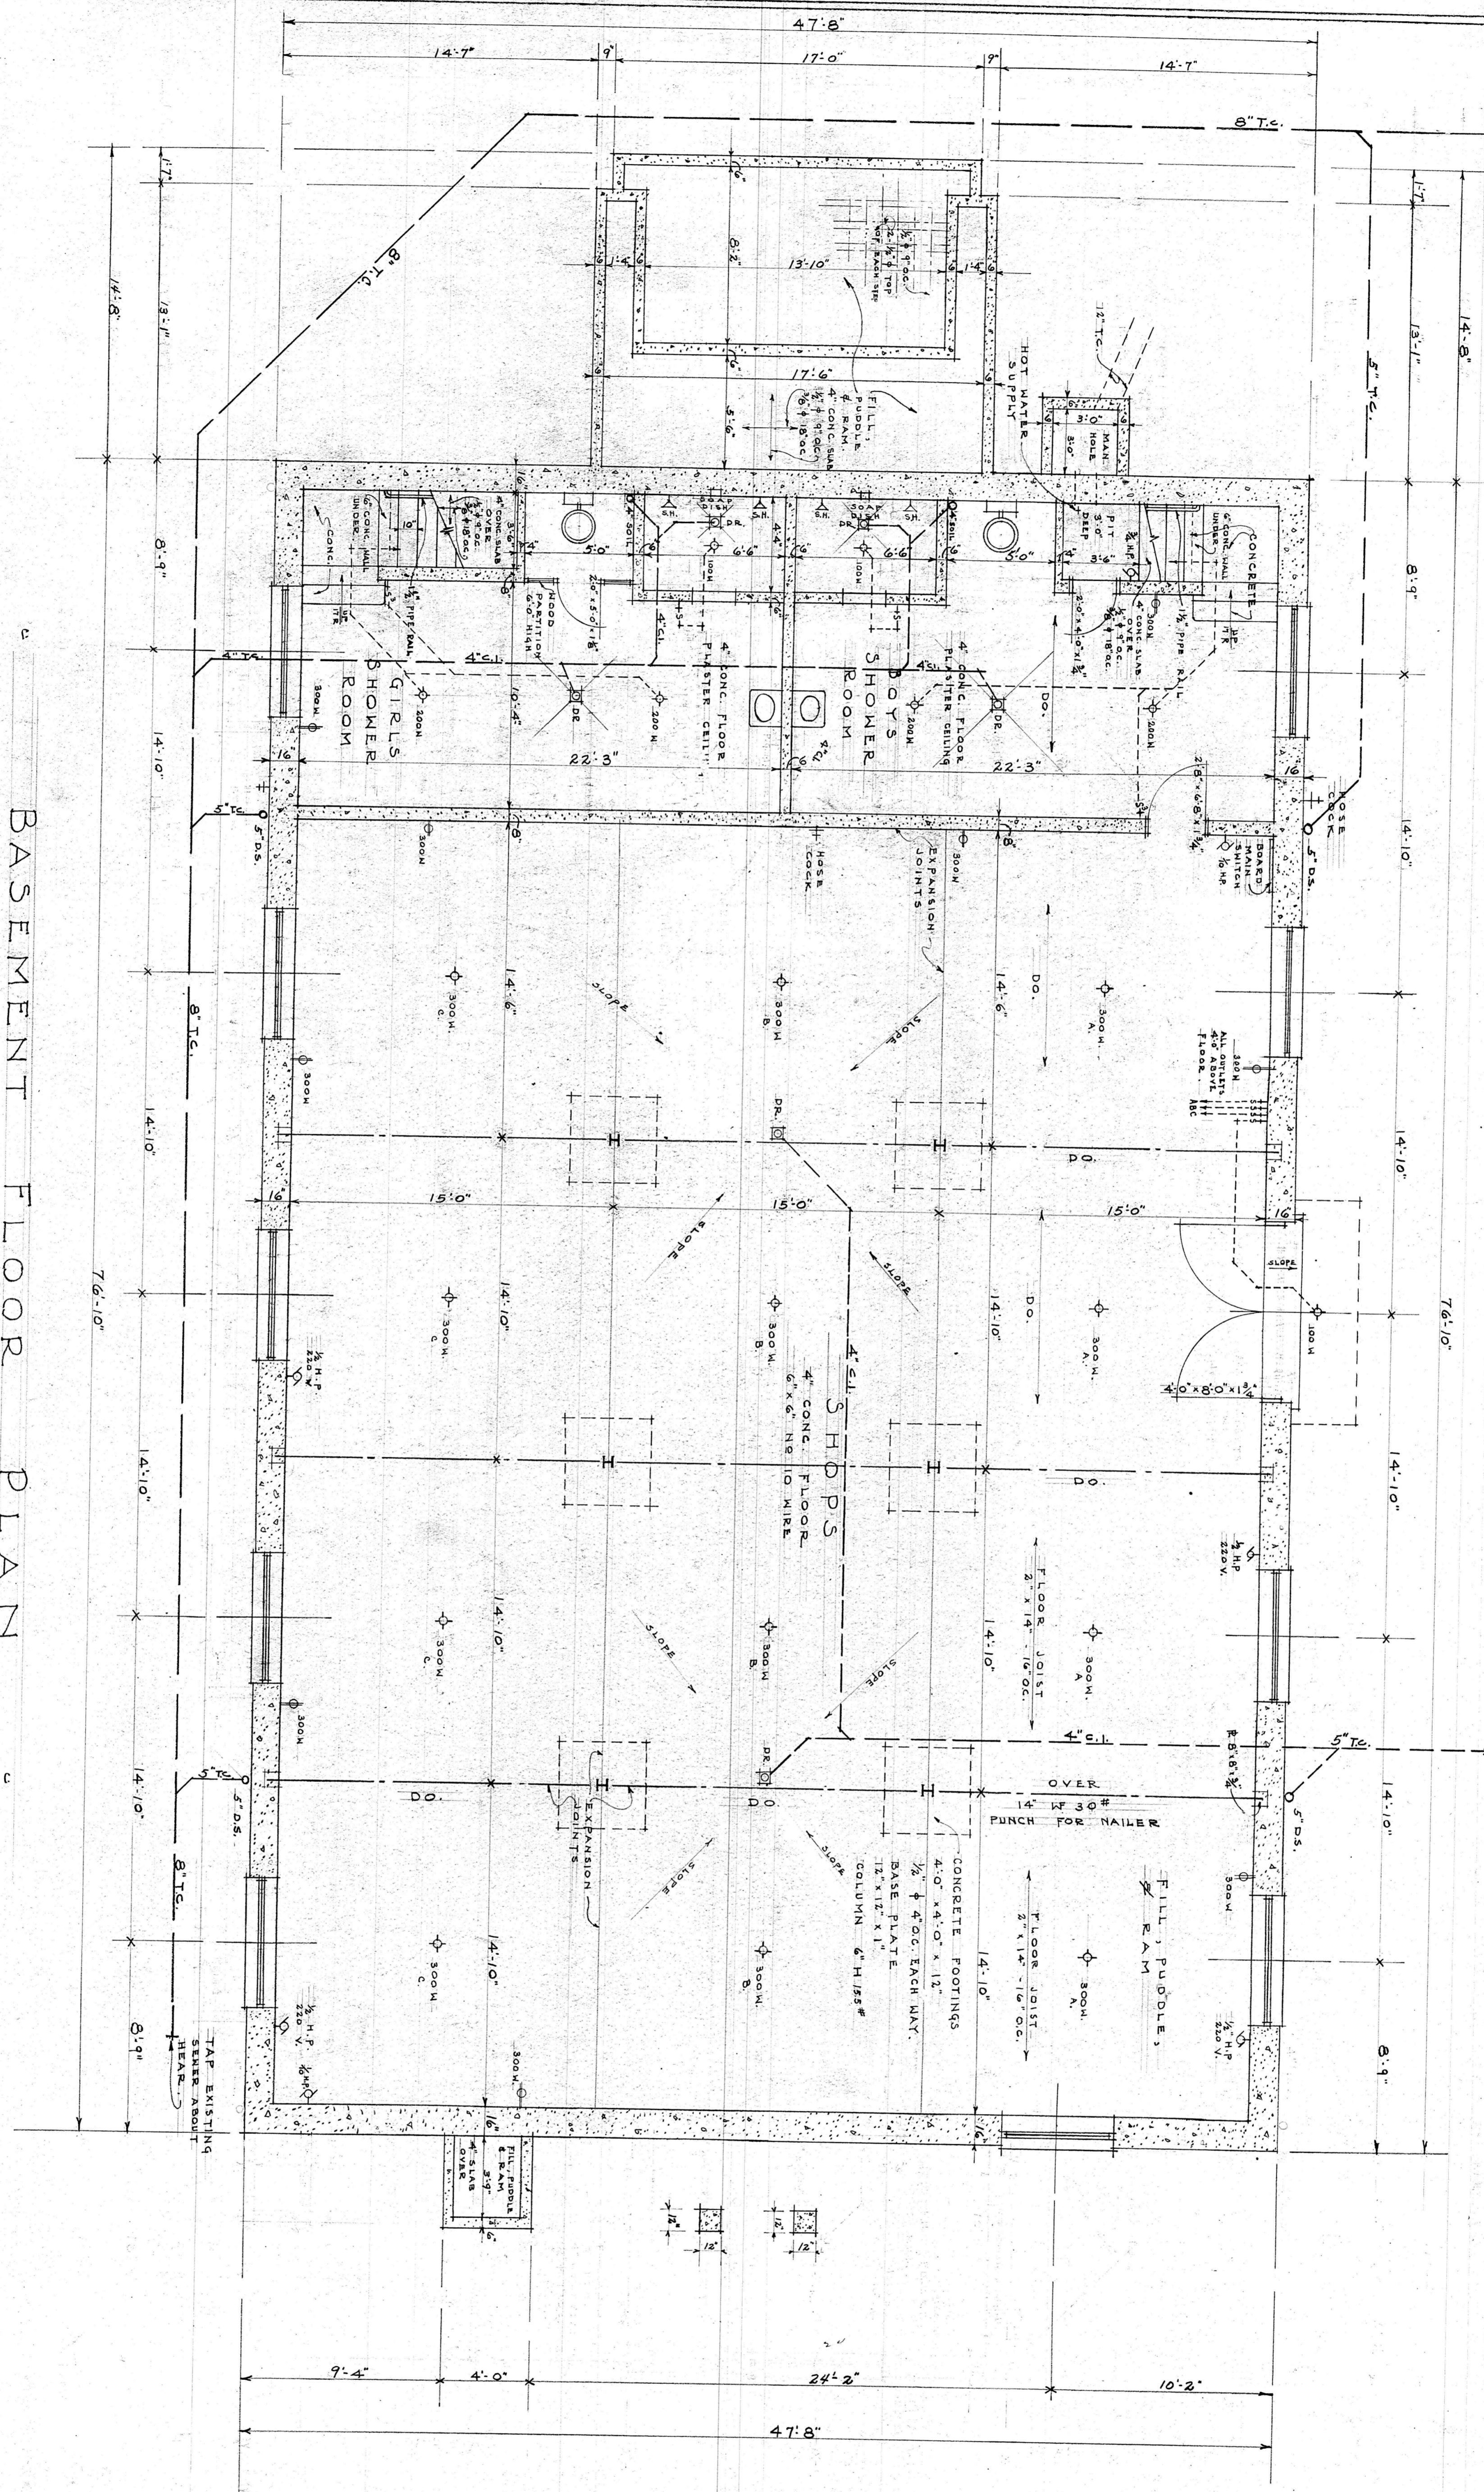

BASEMENT FLOOR PLAN

SCALE 1/4" = 1'-0"

PENDLETON S. CLARK
ARCHITECT
LYNCHBURG, VA.
APRIL 14, 1939
REVISED MAY 23, 1939

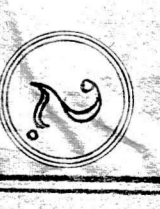




FIRST FLOOR PLAN


SCALE 1/4" = 1'-0"

PENDELTON S. CLARK
 ARCHITECT
 LYNCHBURG, VA.
 APRIL 14, 1939
 REVISED MAY 23, 1939


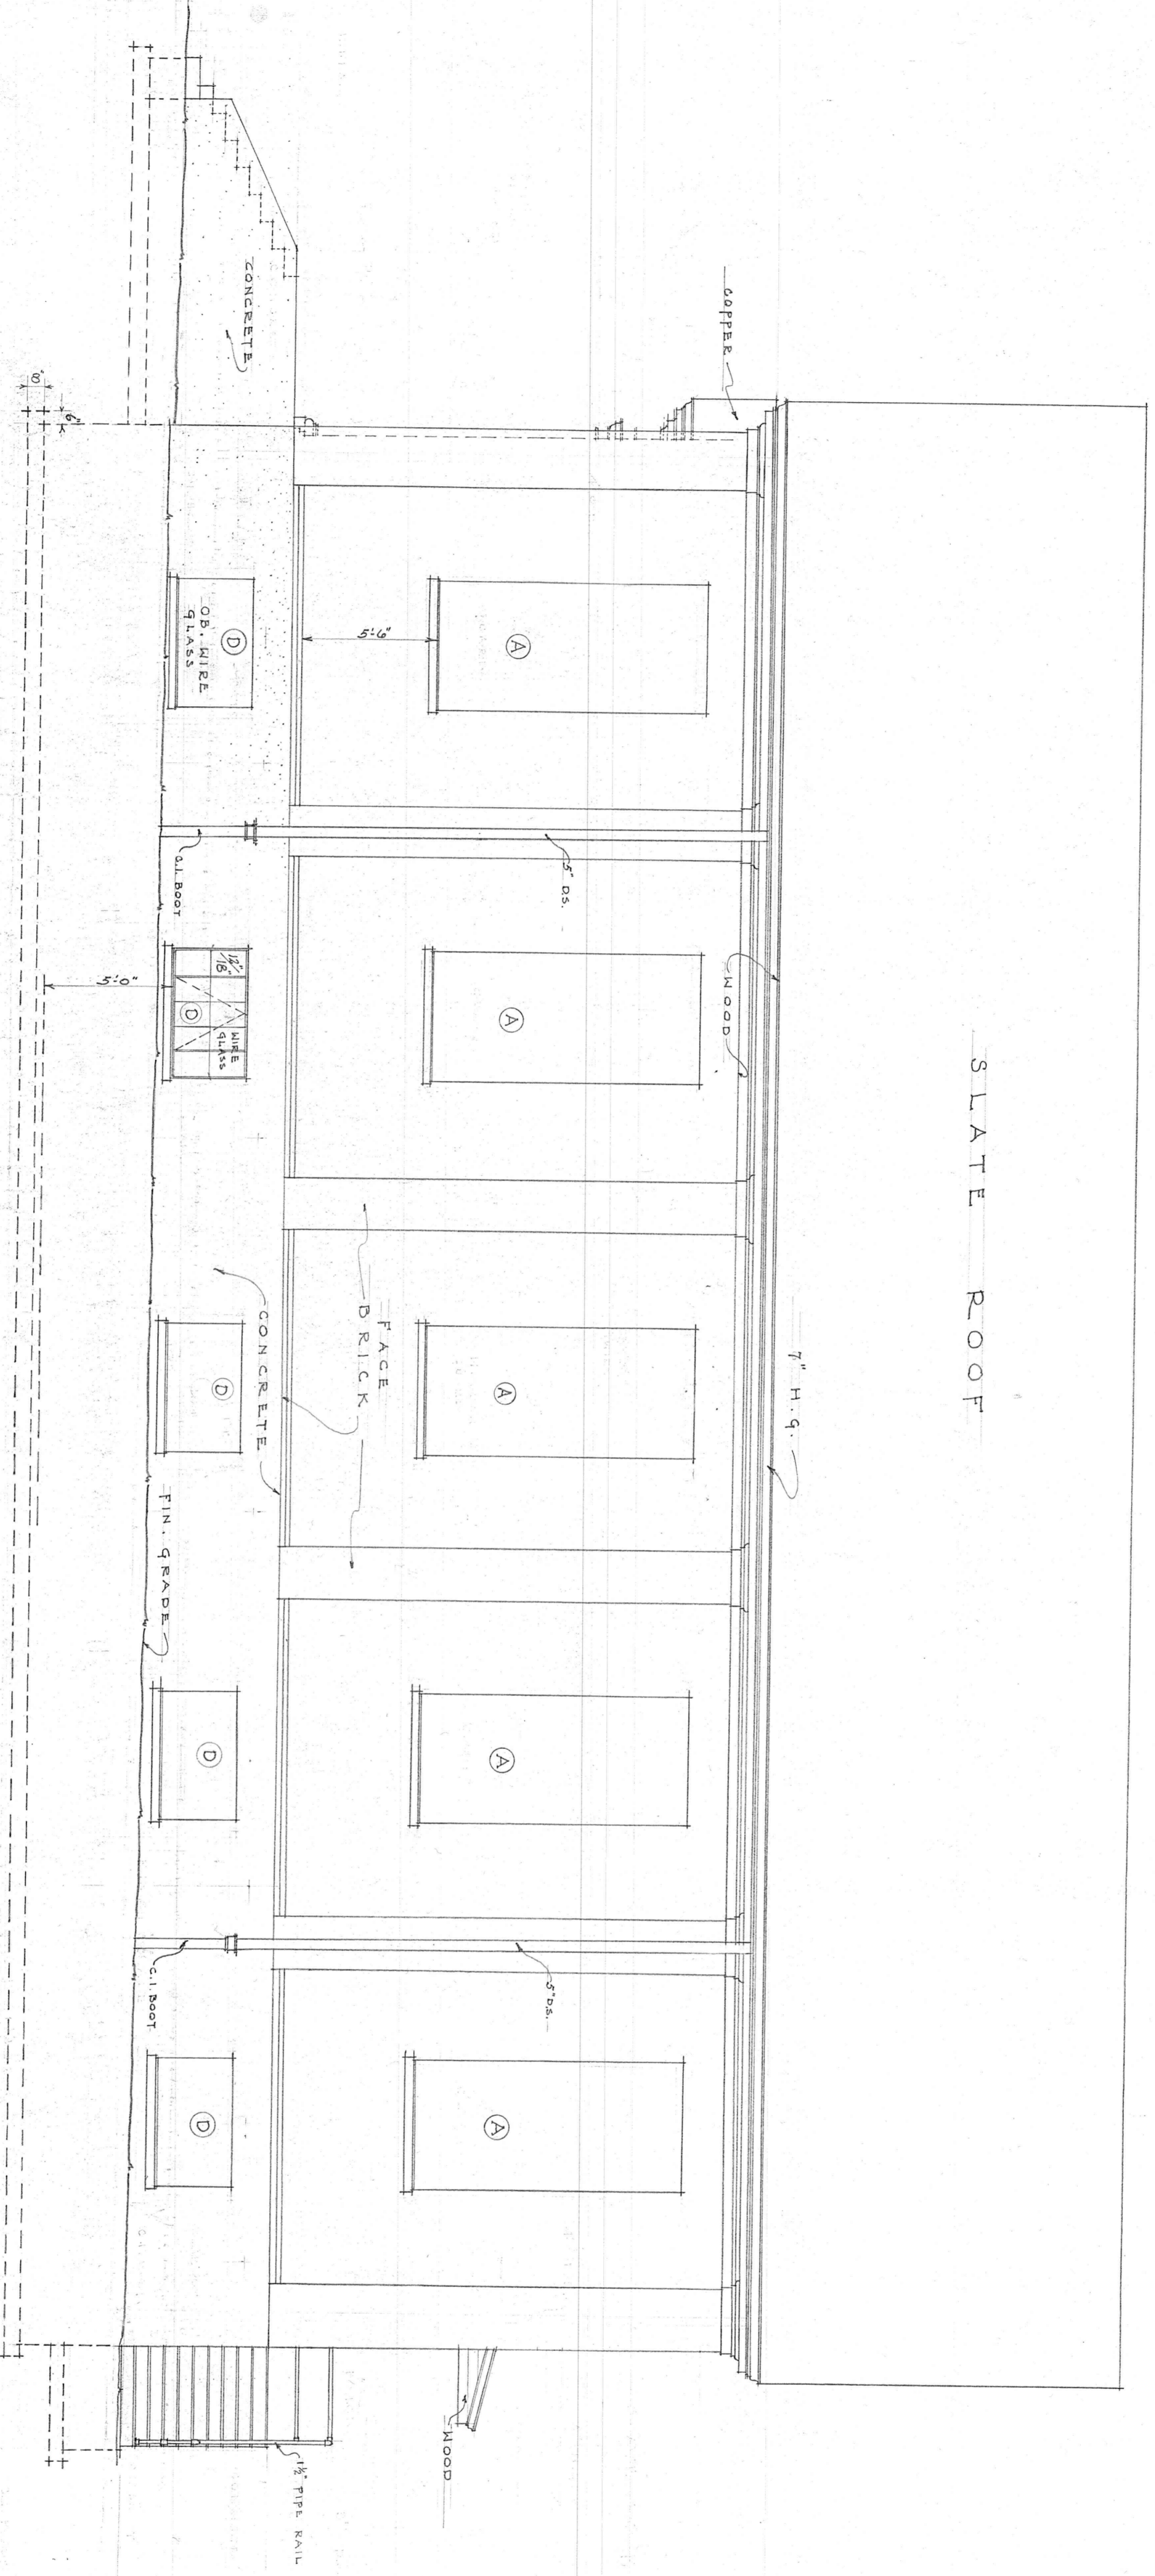


5 EAST ELEVATION 5
 SCALE 1/4" = 1'-0"



PENDLETON S. CLARK
 ARCHITECT
 LYNCHBURG, VA.
 APRIL 14, 1939
 REVISED MAY 23, 1939

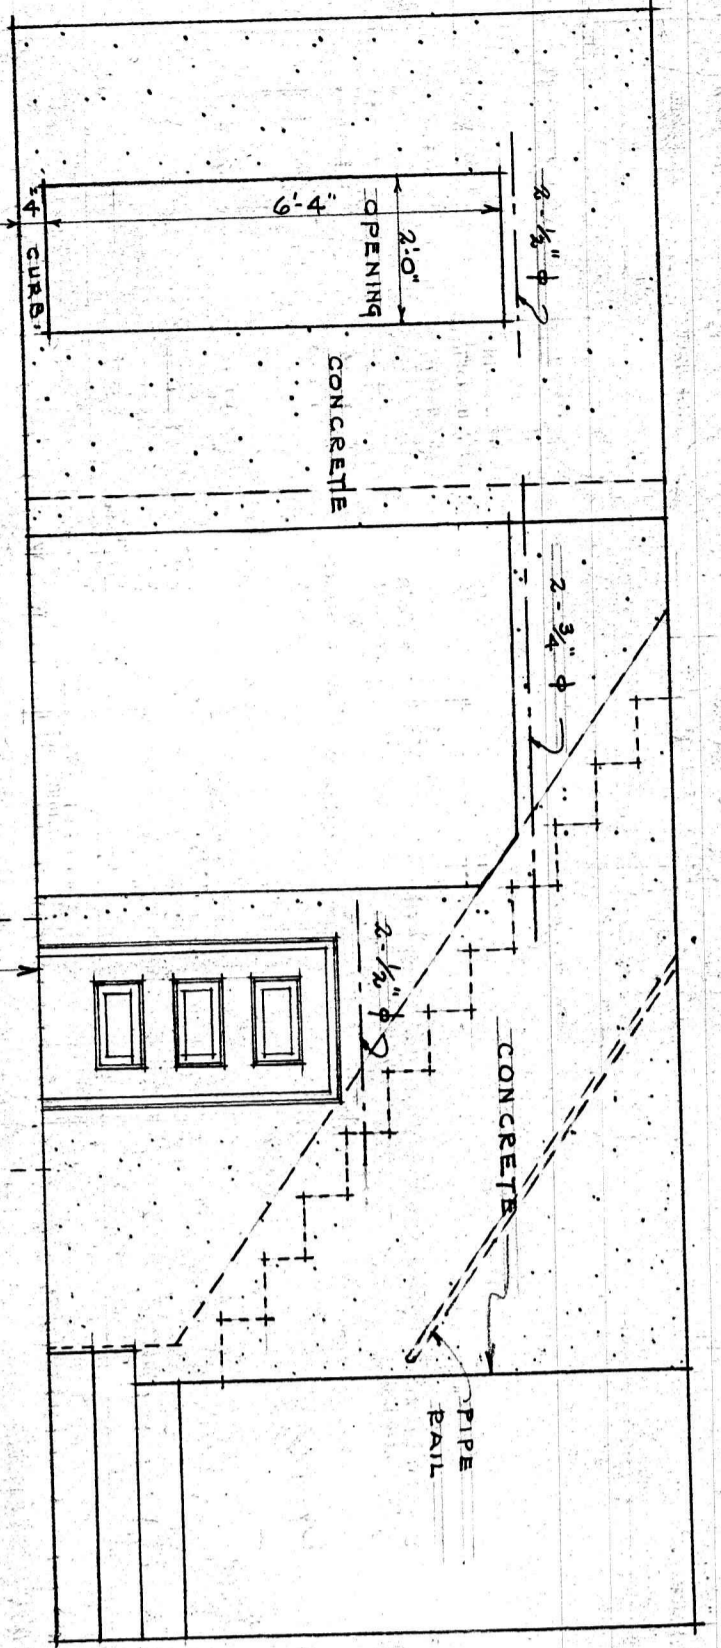


BOYS SHOWER ROOM
GIRLS SHOWER ROOM
SIMILAR.

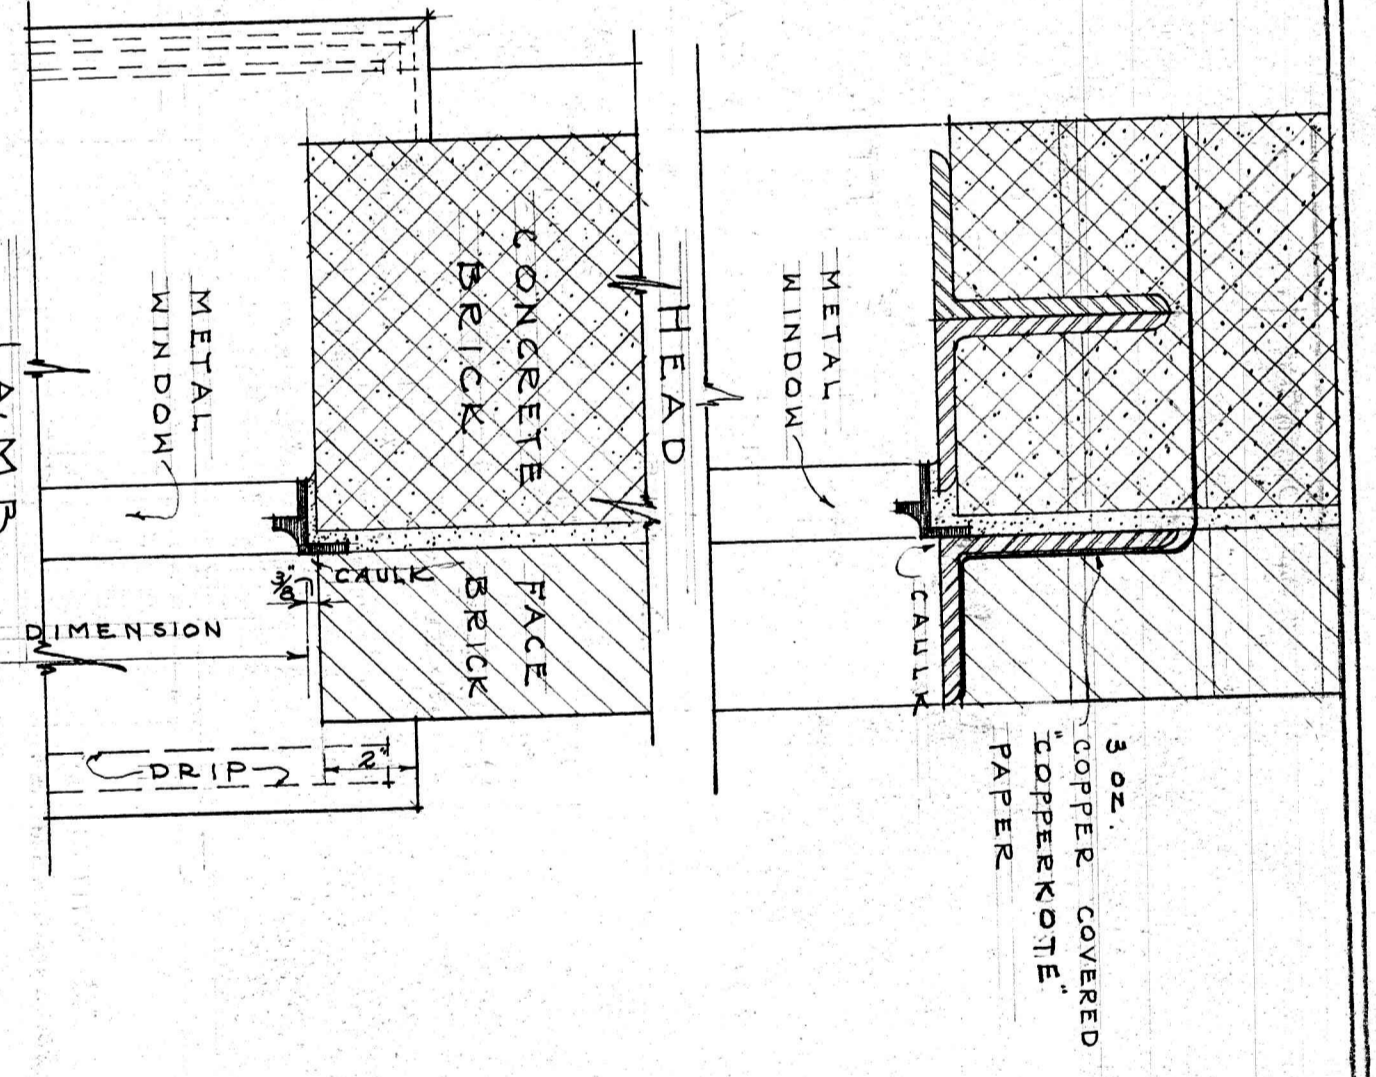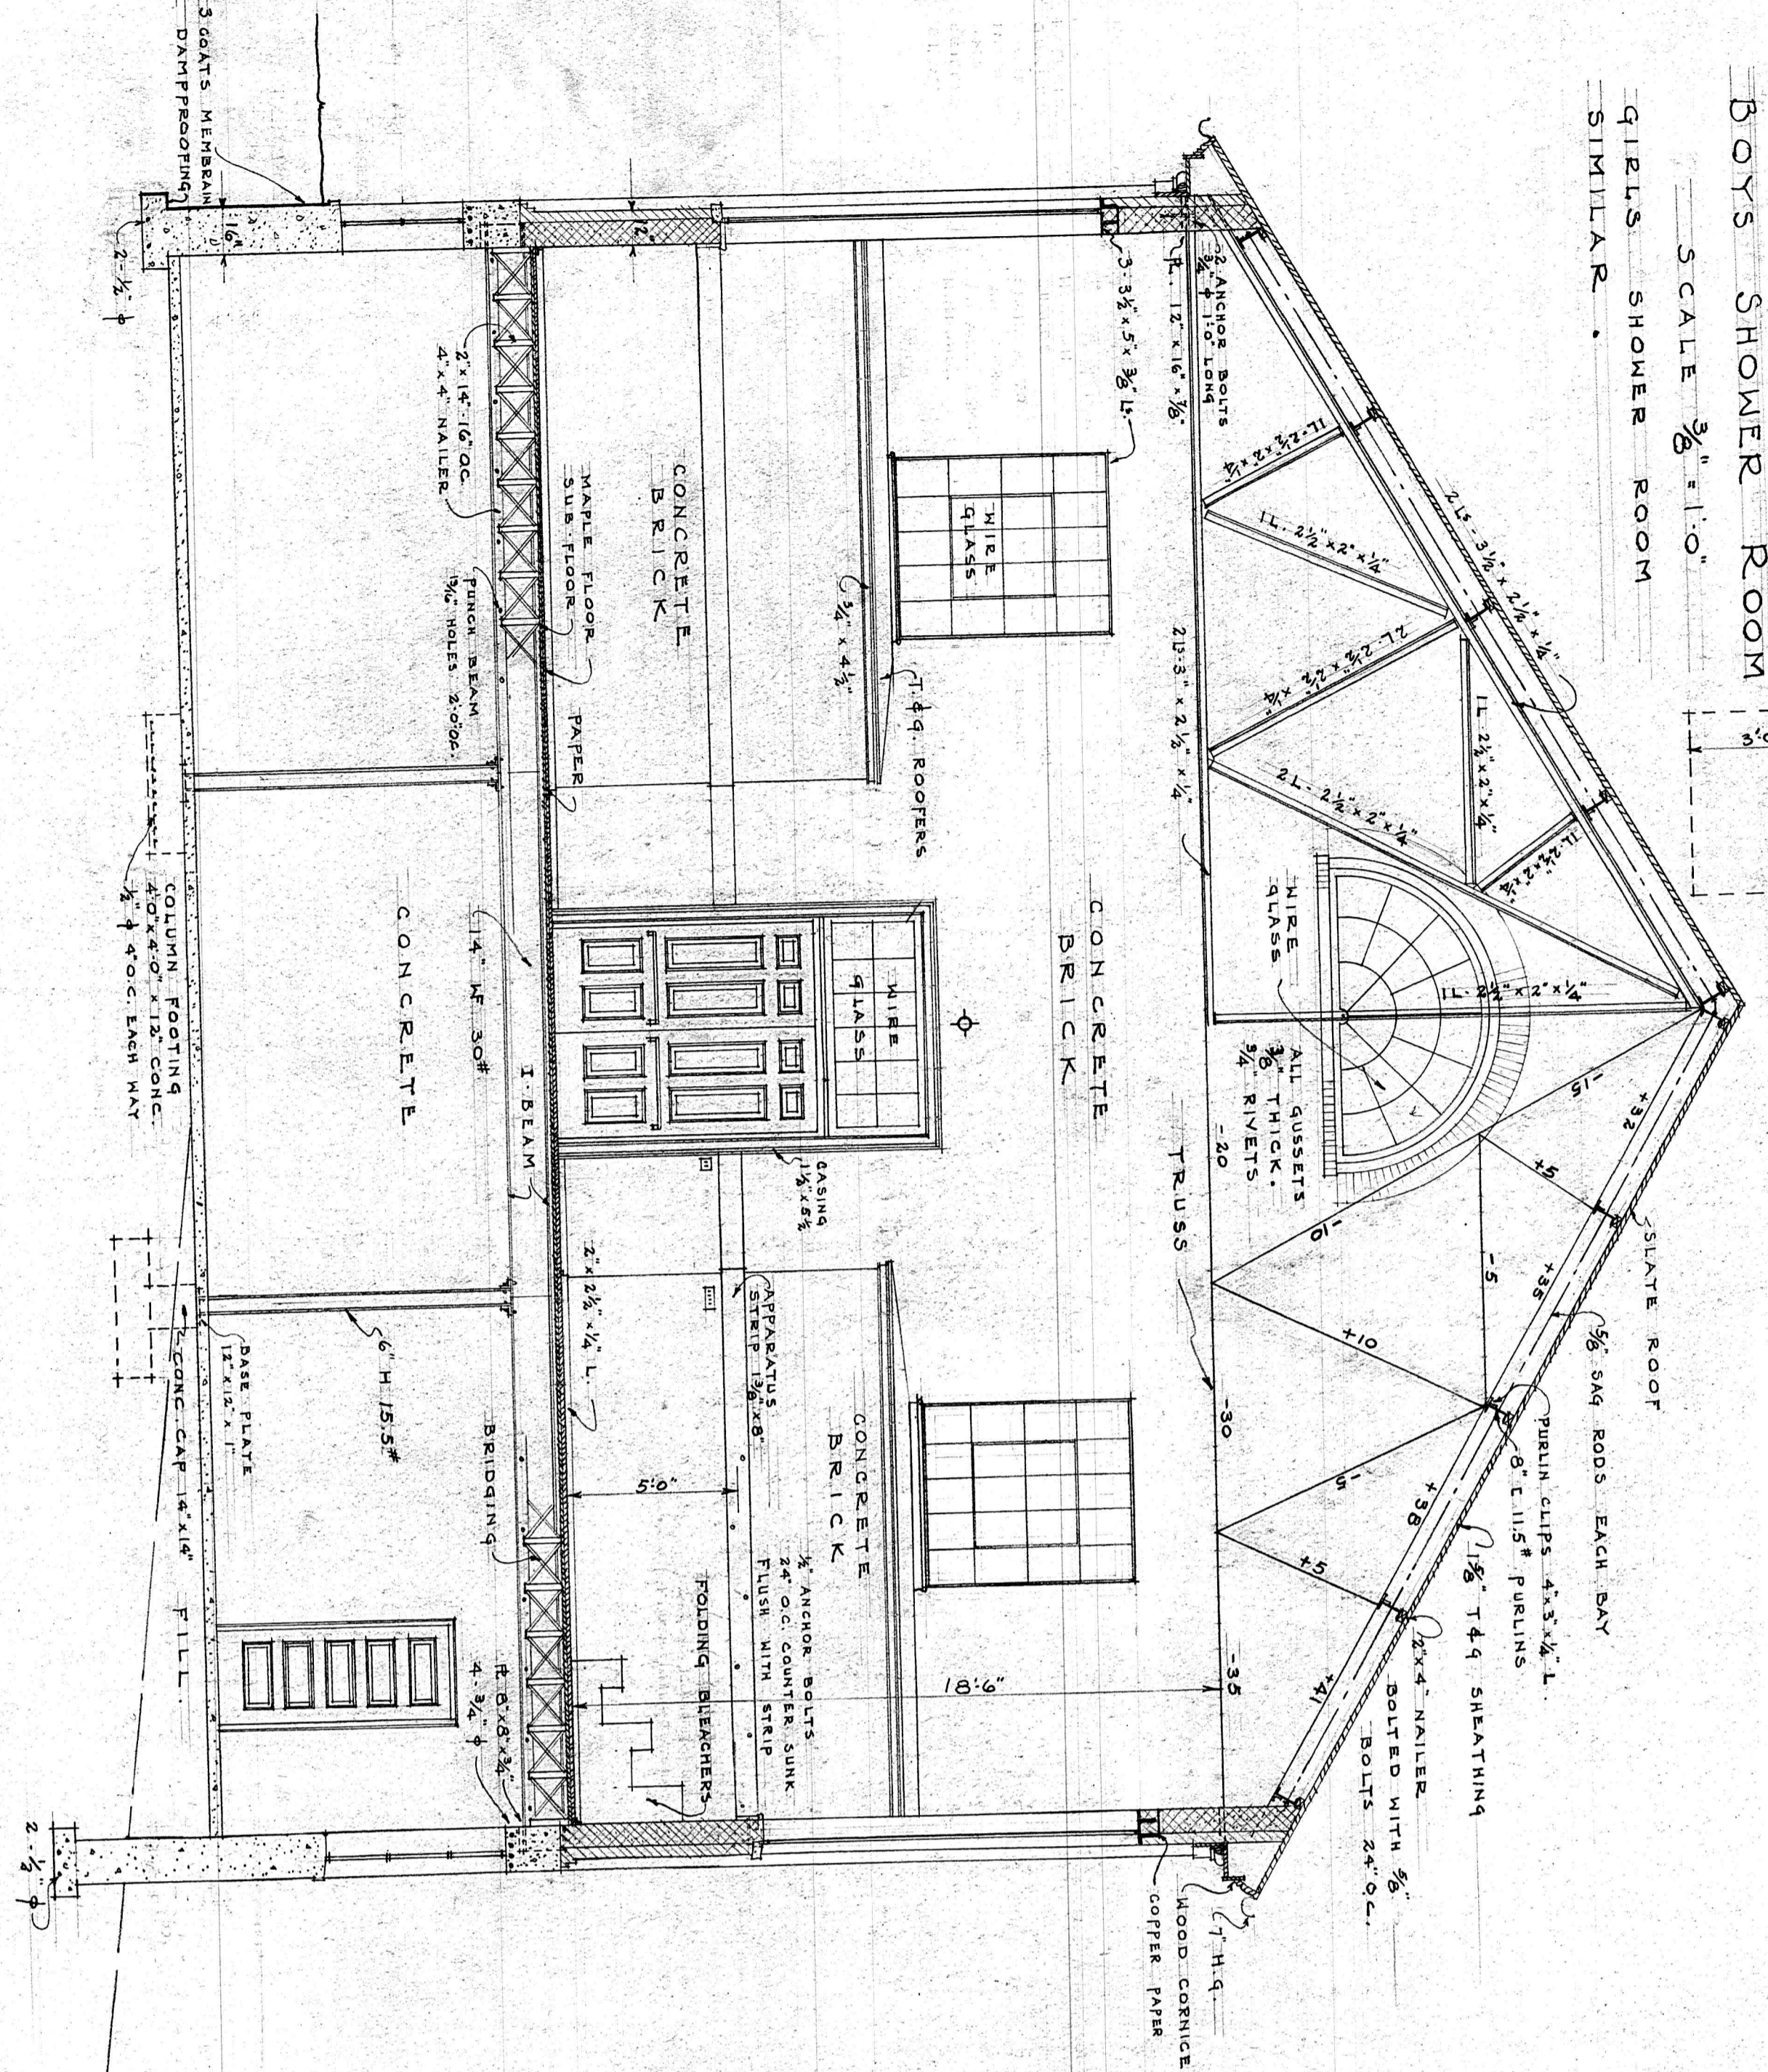


DETAIL BASKETBALL BACKSTOP
SCALE 1/2" = 1'-0"

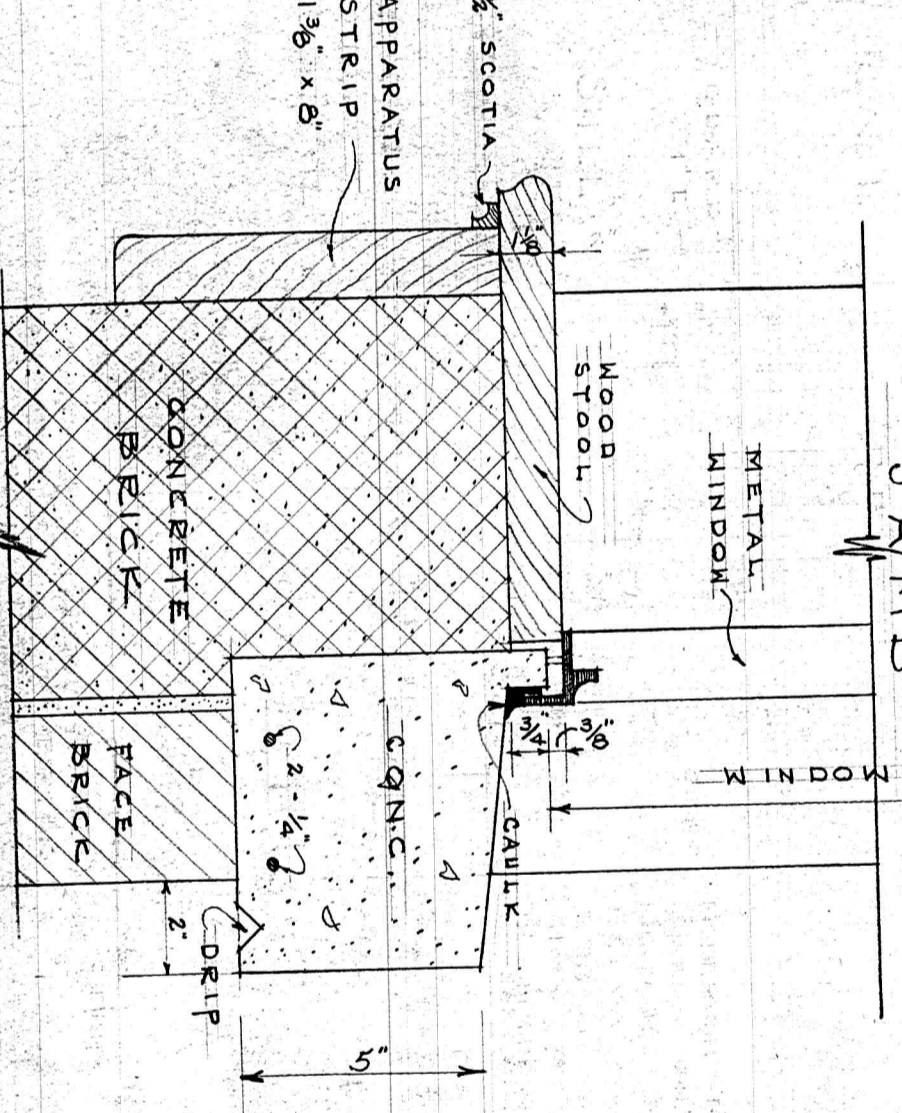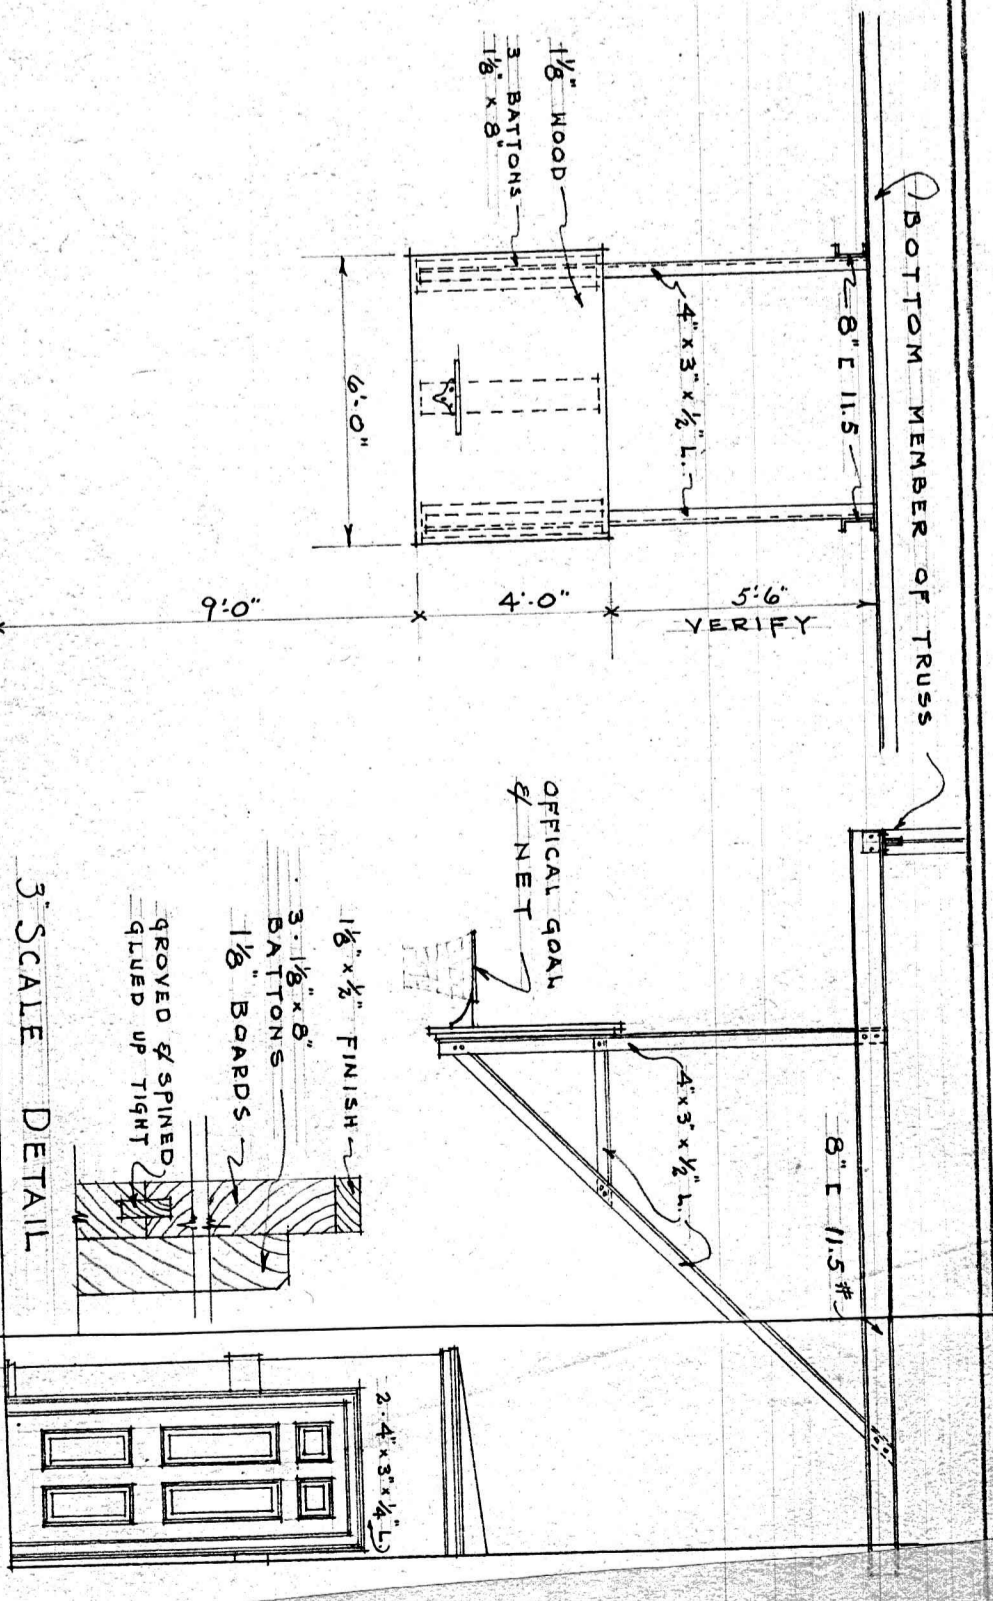

SECTION THRU CORNICE

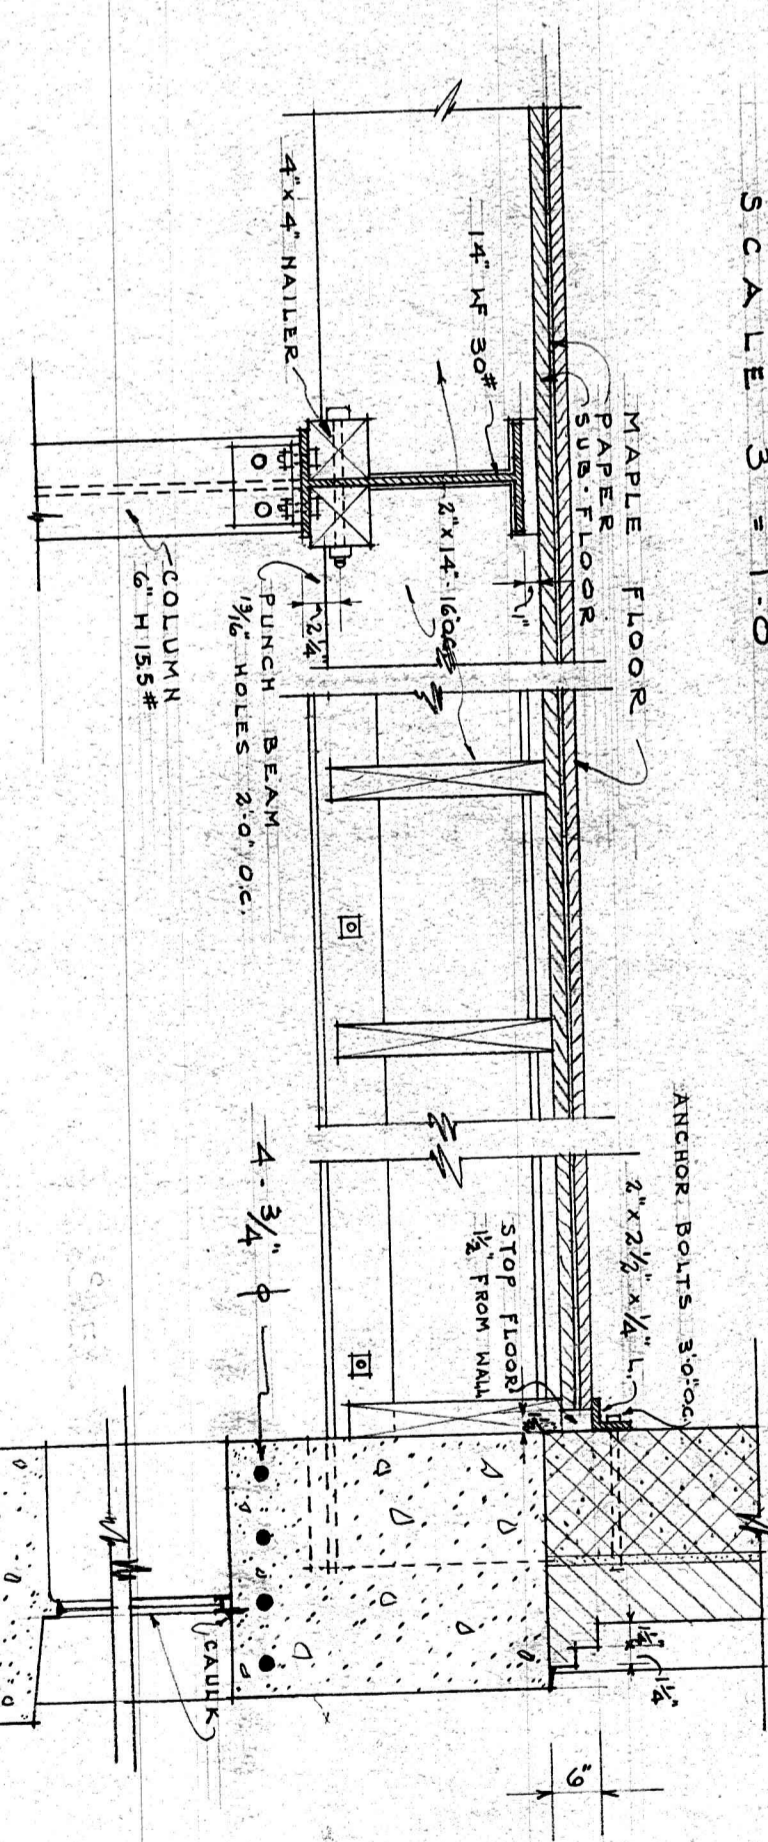

PENDLETON S. CLARK
ARCHITECT
LYNCHBURG, VA.
APRIL 14, 1939
REVISED MAY 23, 1939

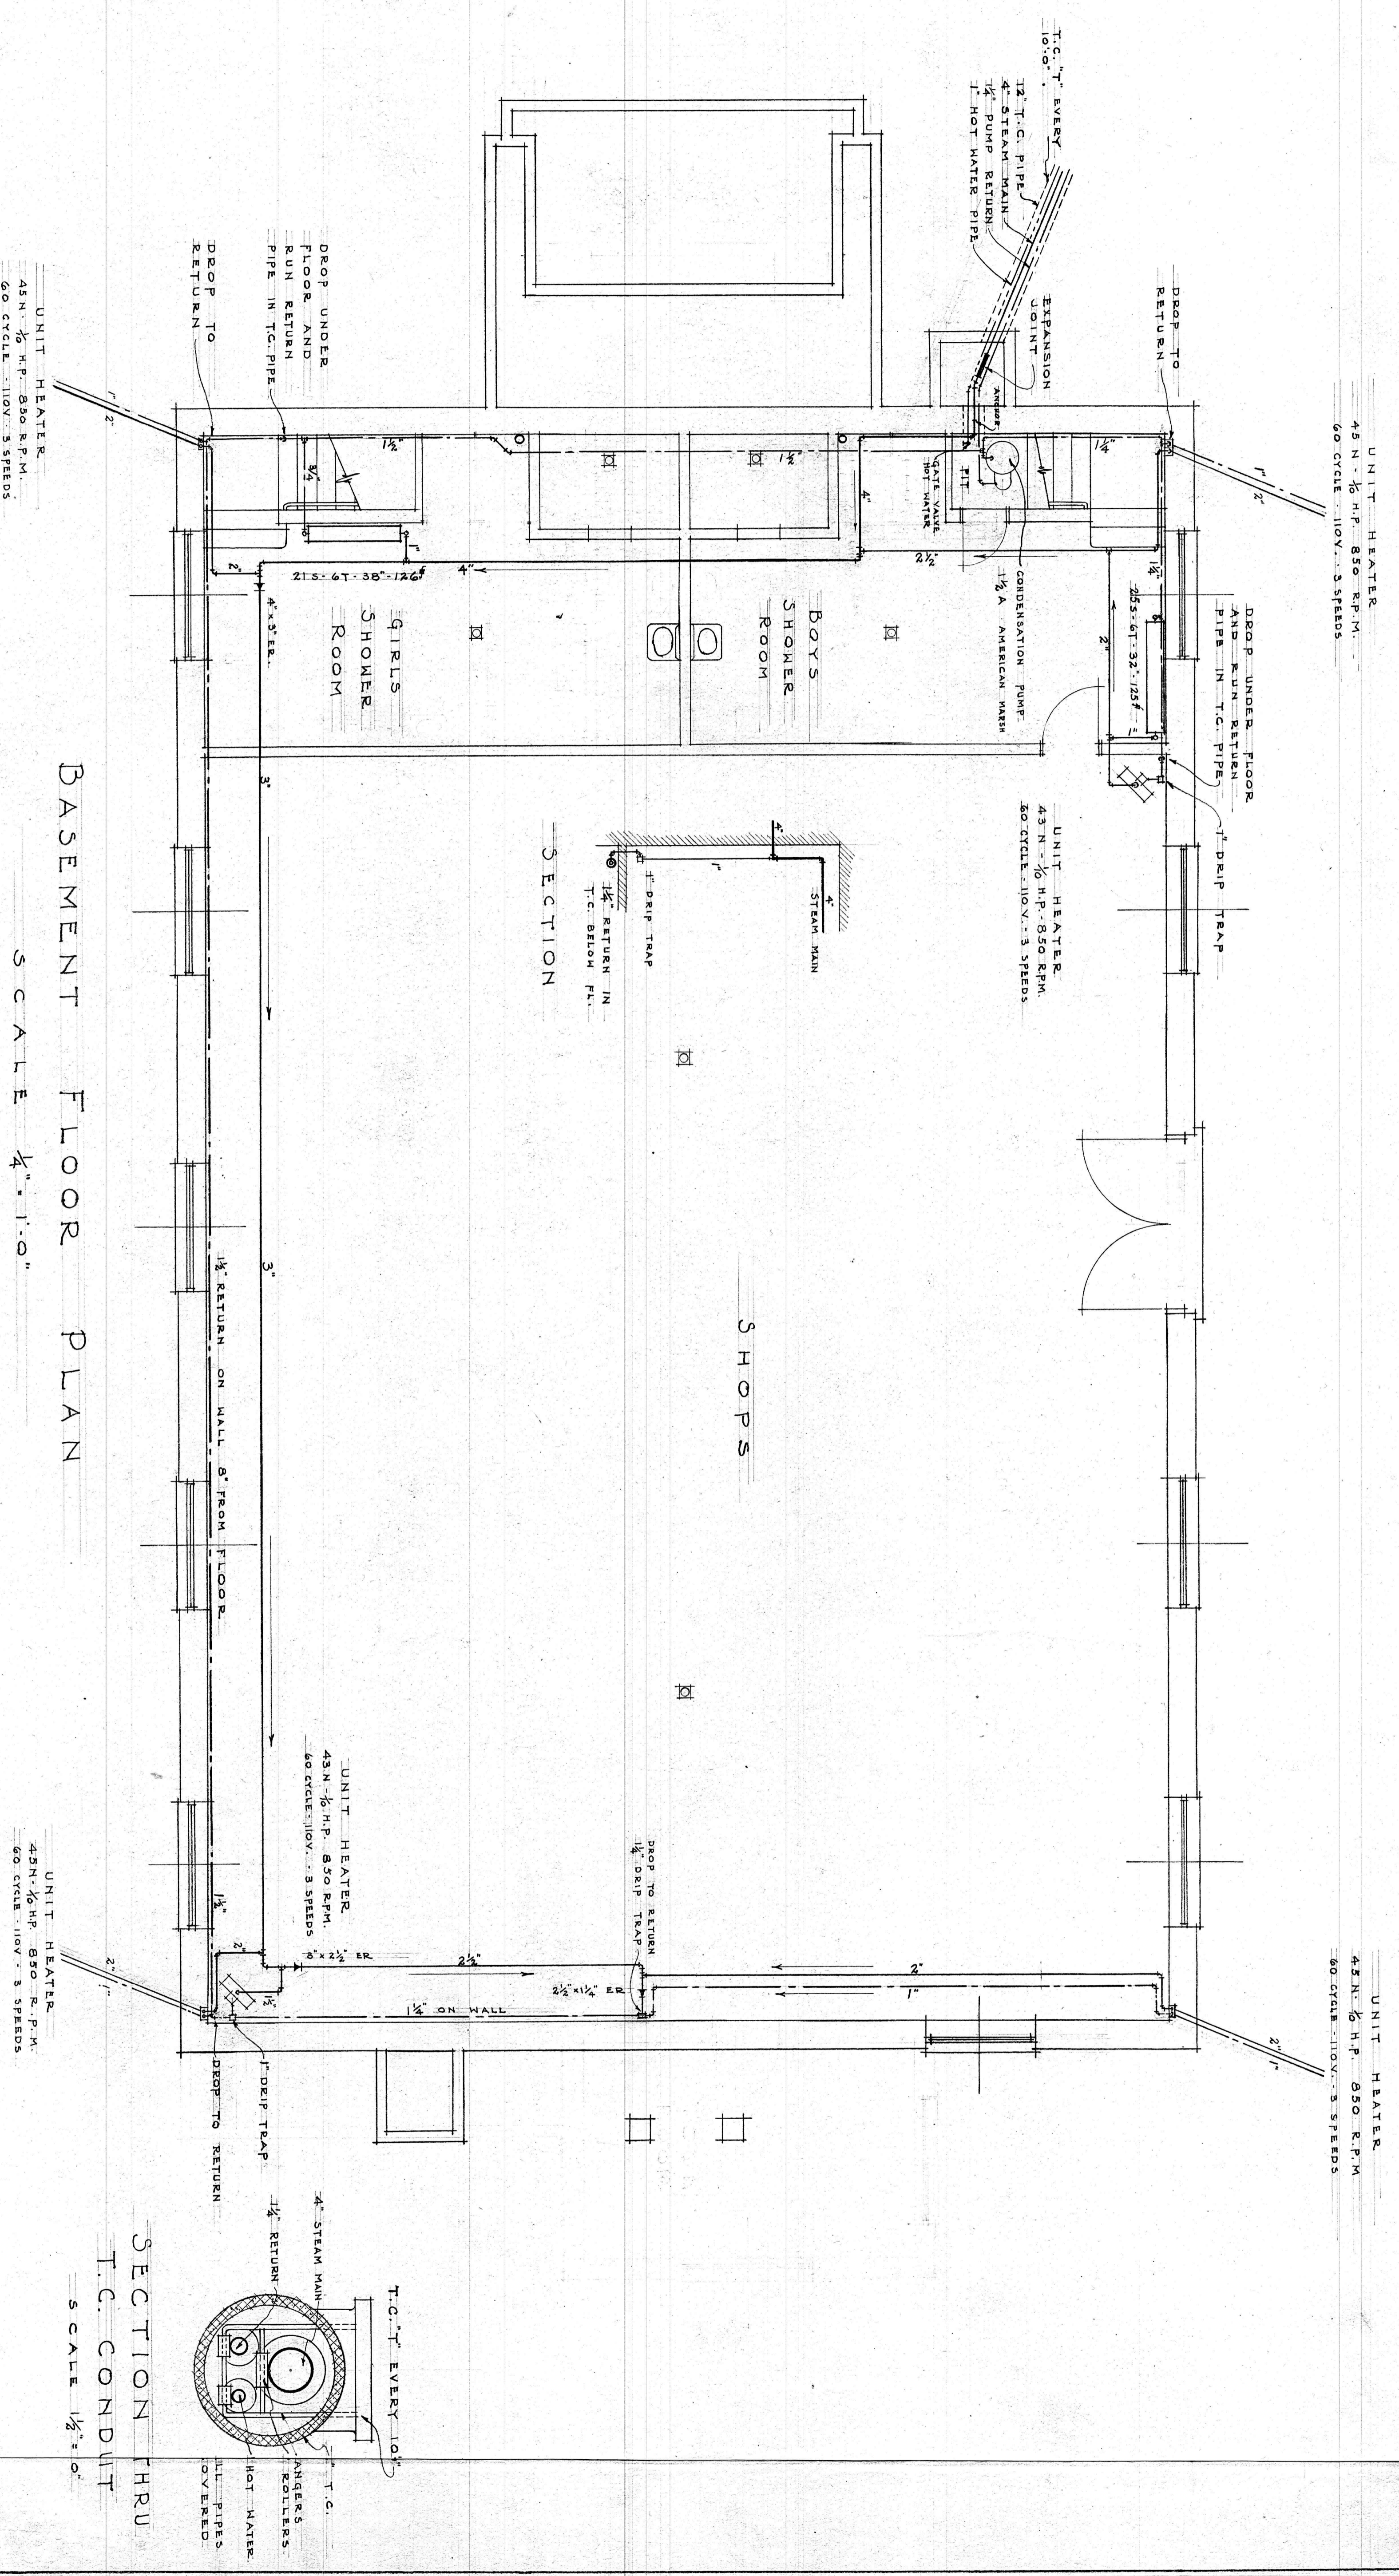

BASEMENT FLOOR PLAN

SCALE 1/4" = 1'-0"

HEATING LAYOUT

GYMNASIUM


FOR

PRESBYTERIAN ORPHAN'S HOME

LYNCHBURG, VA.

SECTION THRU T.C. CONDUIT

SCALE 1/2" = 0'

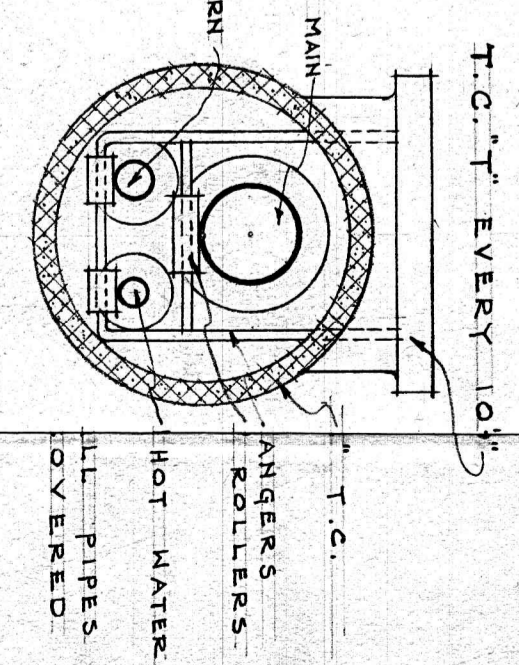

PENDLETON S. CLARK


ARCHITECT

LYNCHBURG, VA.

APRIL 14, 1939

REVISED MAY 23, 1939



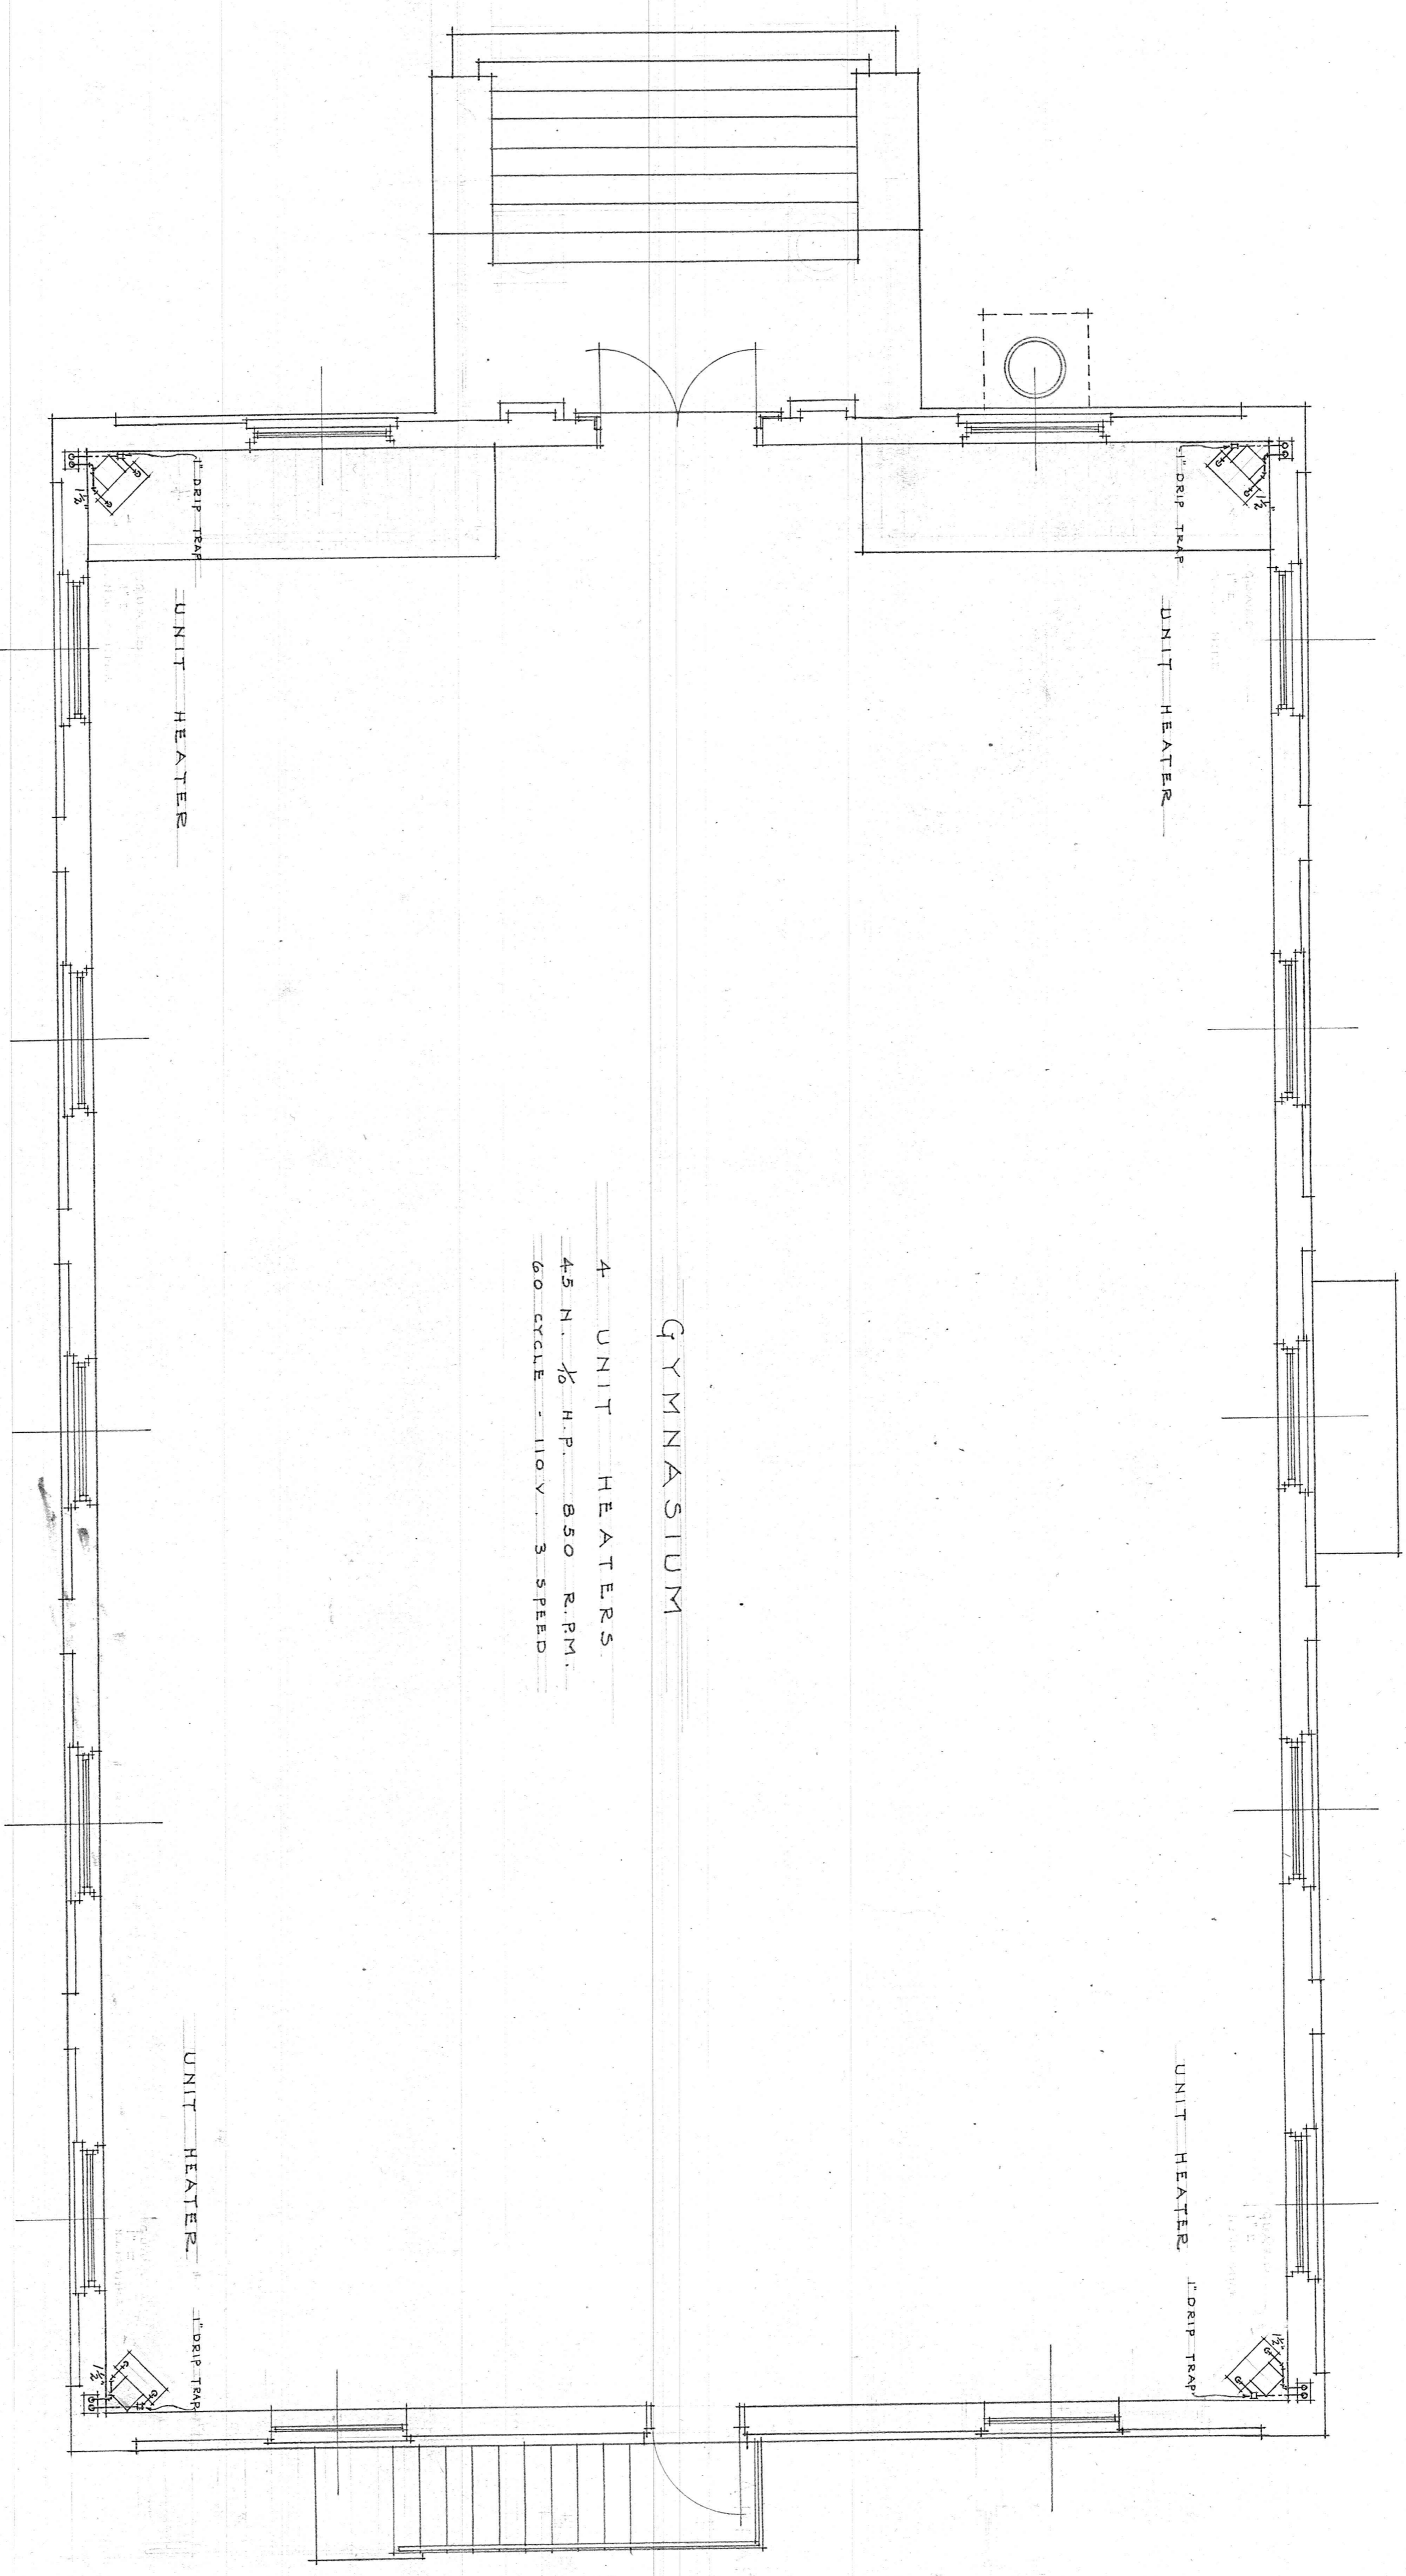

4 UNIT HEATERS
 45 N. 1/2 H.P. 850 R.P.M.
 60 CYCLE - 110 V. 3 SPEED

GYMNASIUM

FIRST FLOOR PLAN
 SCALE 1/4" = 1'-0"

PENDLETON S. CLARK
 ARCHITECT
 LYNCHBURG, VA.
 APRIL 14, 1939
 REVISED MAY 23, 1939

