




SECOND FLOOR PLAN
SCALE: 1/4" = 1'-0"

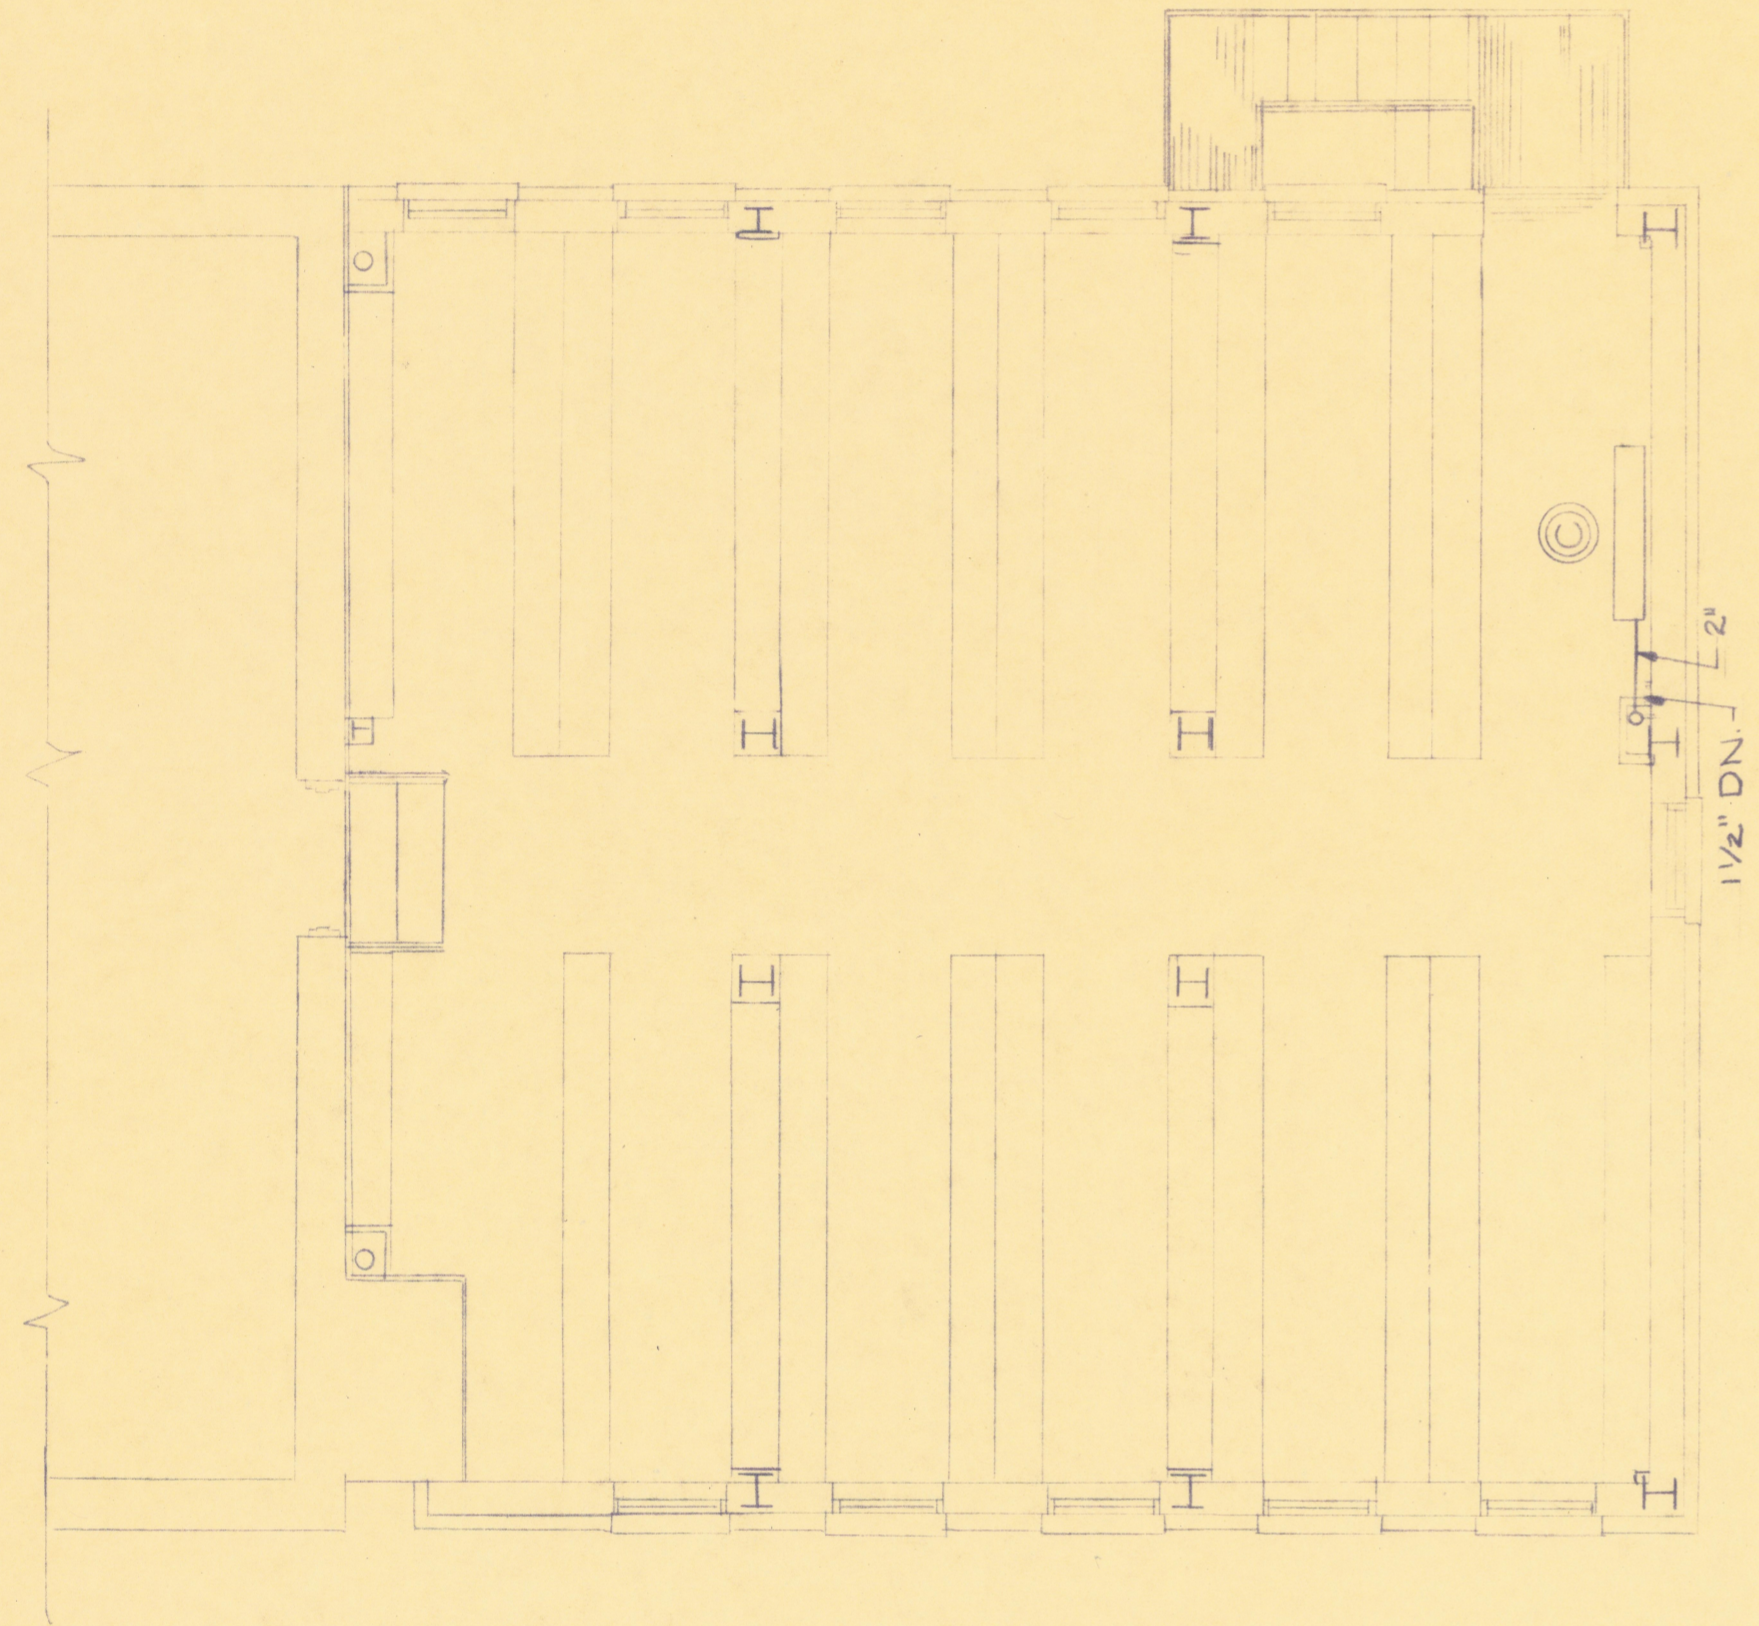


THIRD FLOOR PLAN
SCALE: 1/4" = 1'-0"

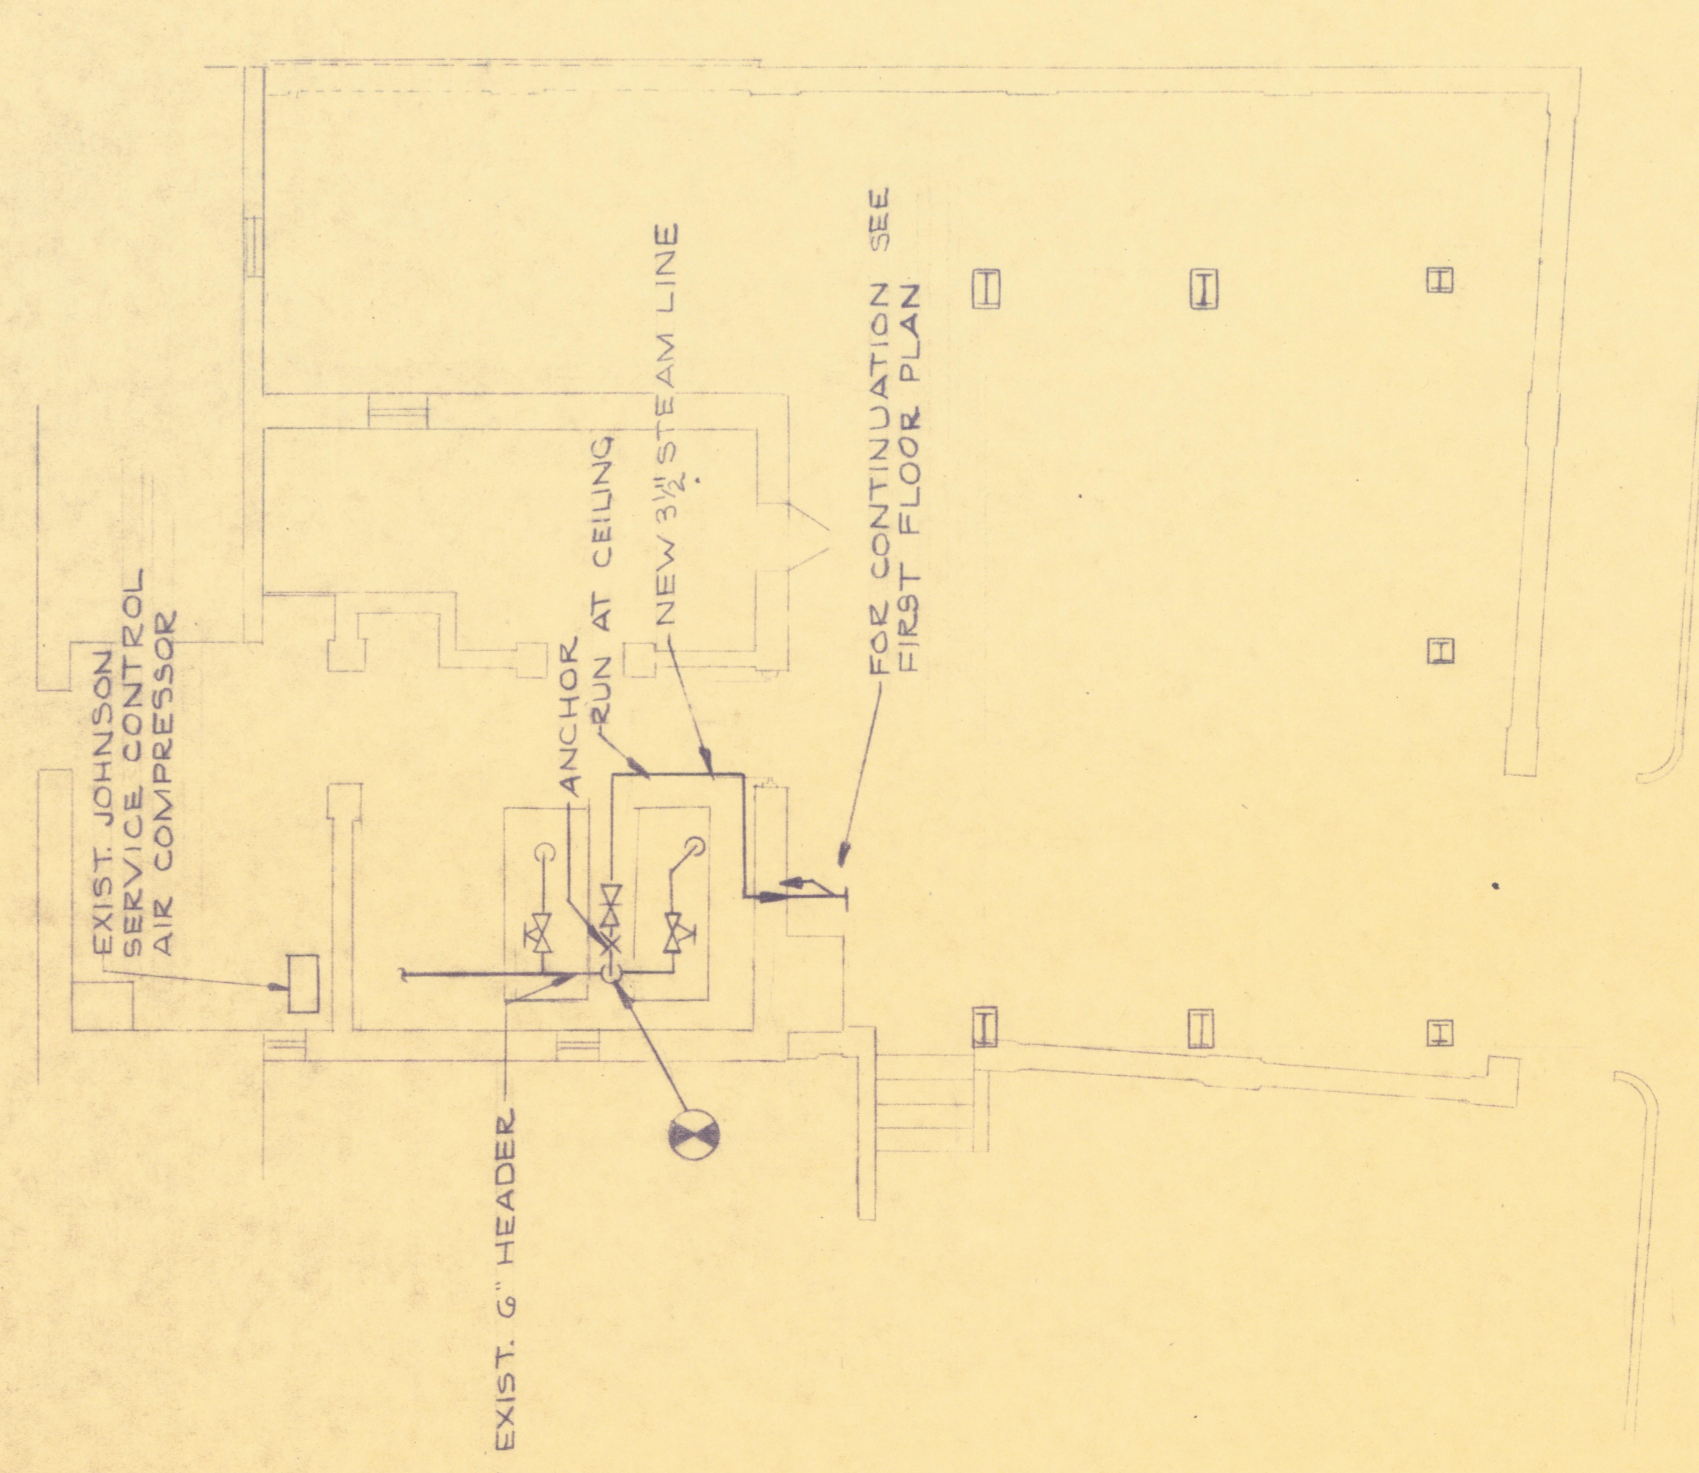

COURT PLAN
SCALE: 1/8" = 1'-0"

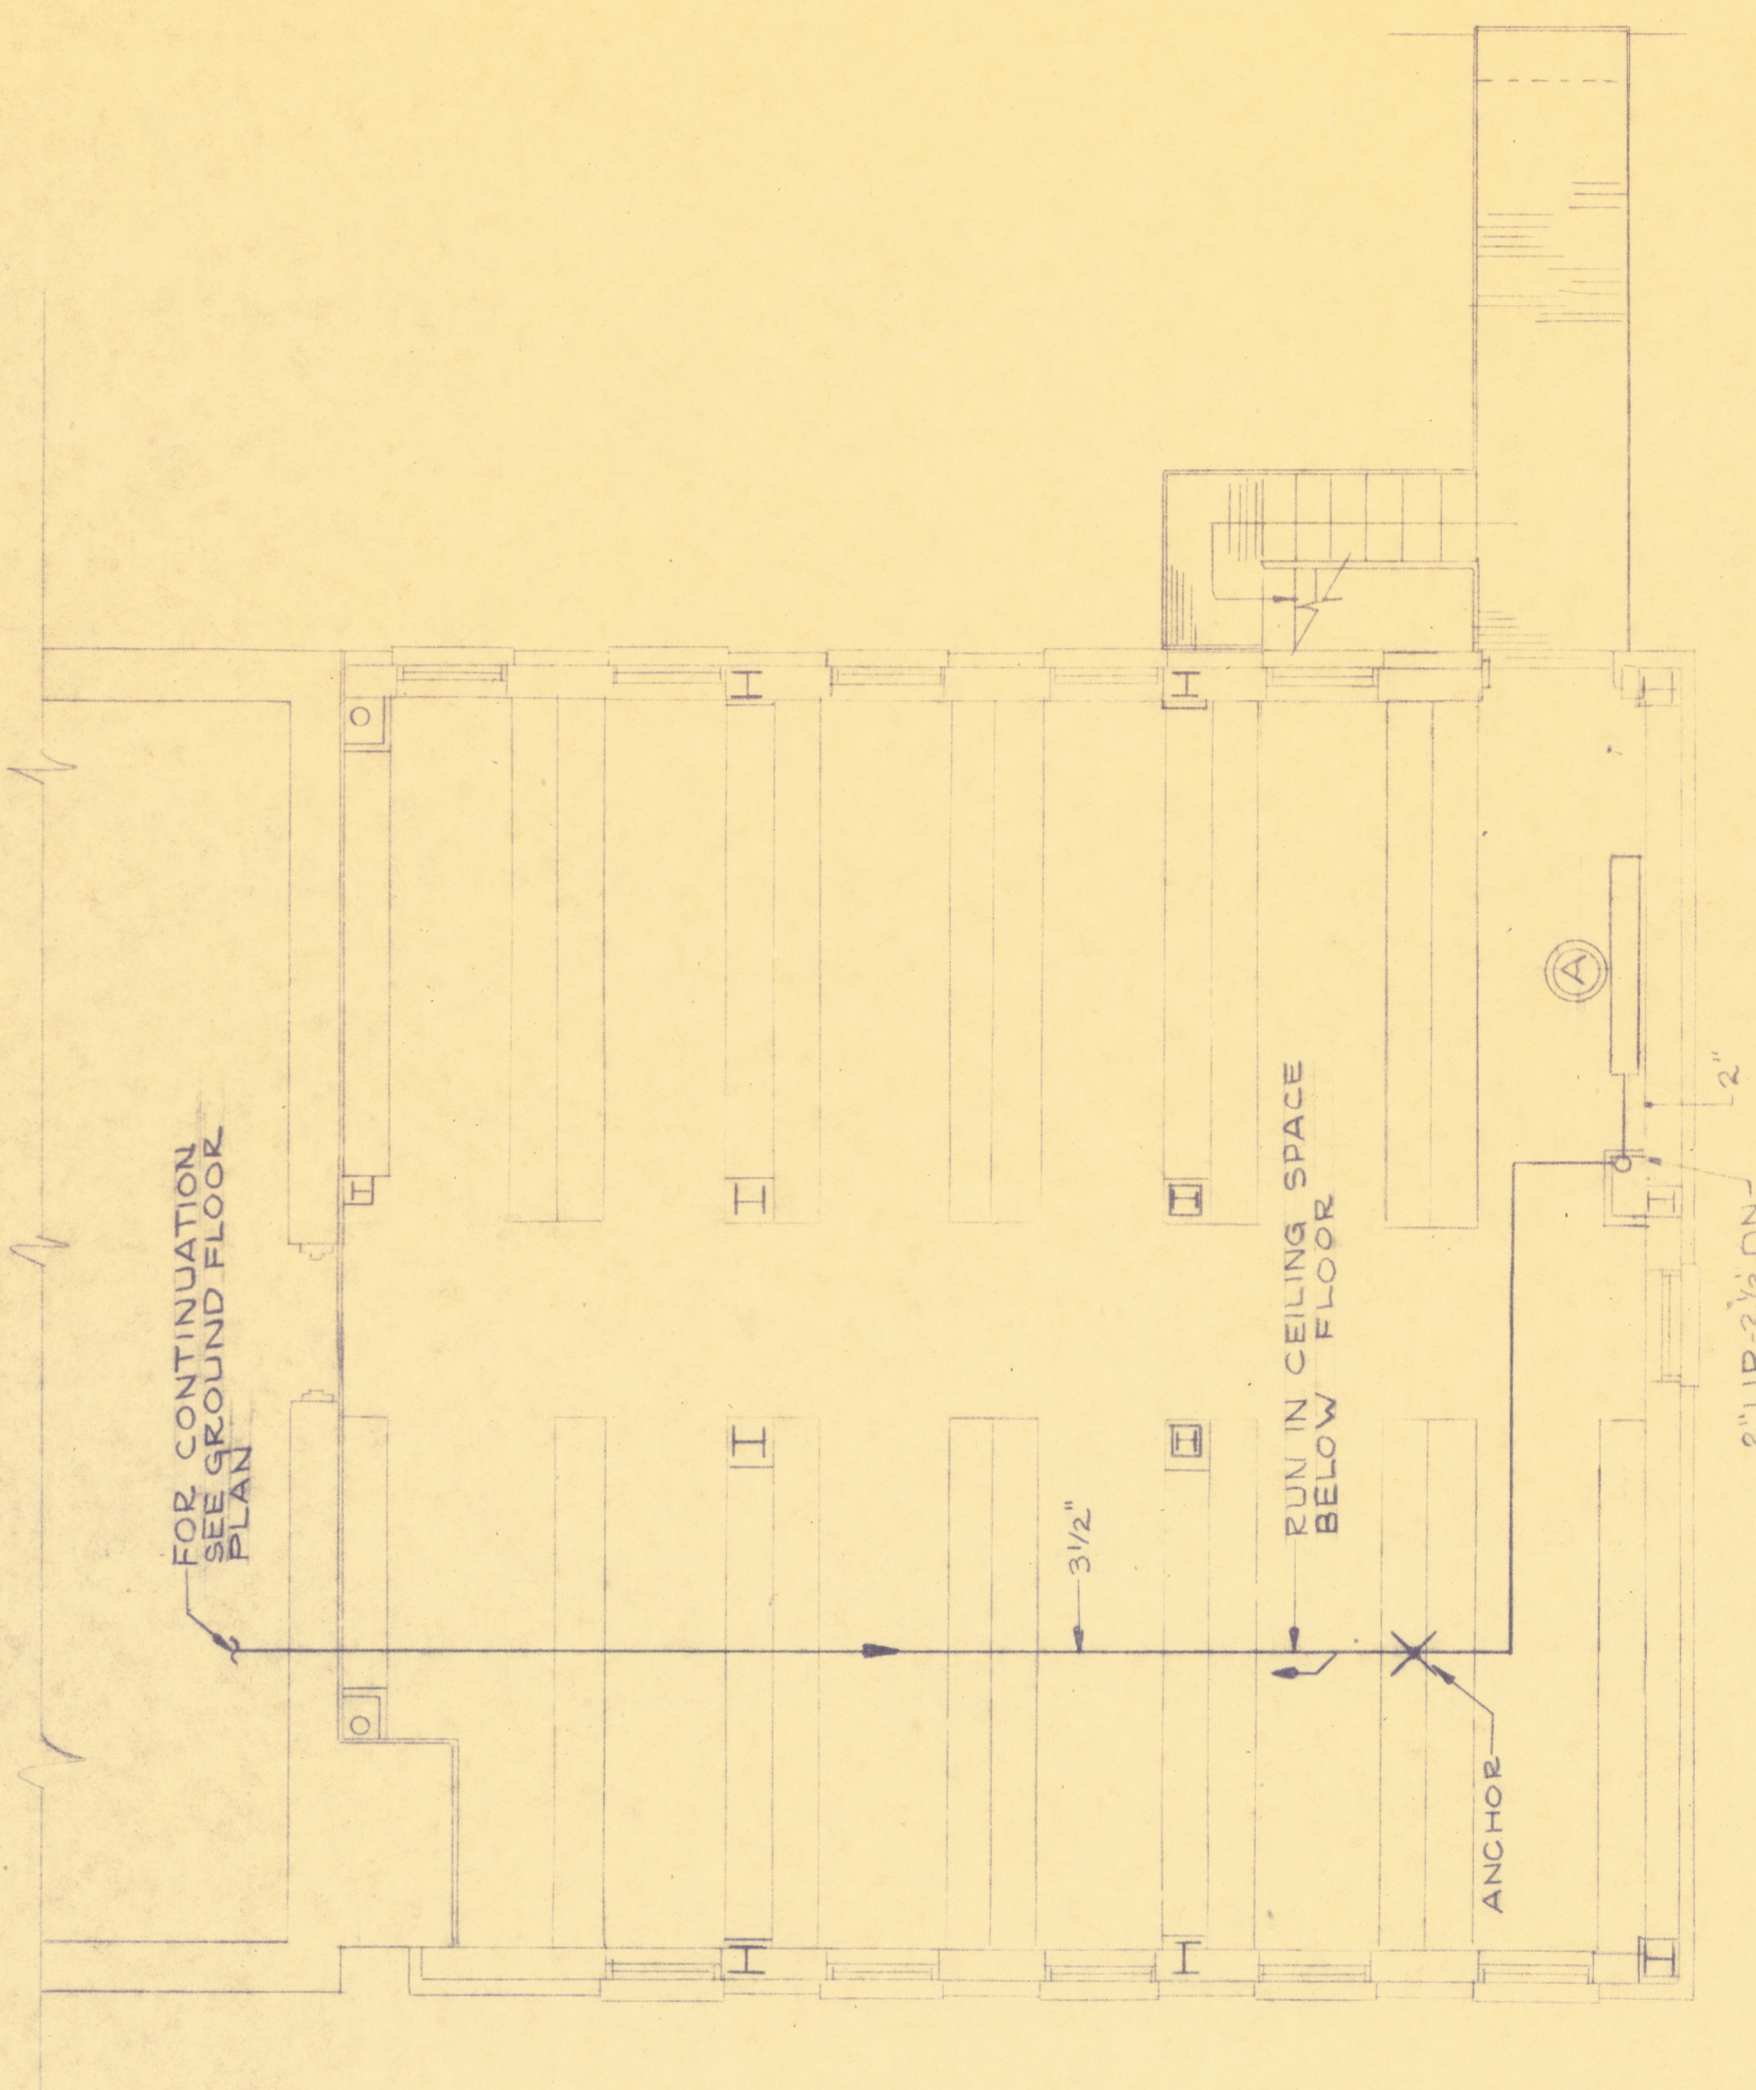

FIRST FLOOR PLAN
SCALE: 1/4" = 1'-0"

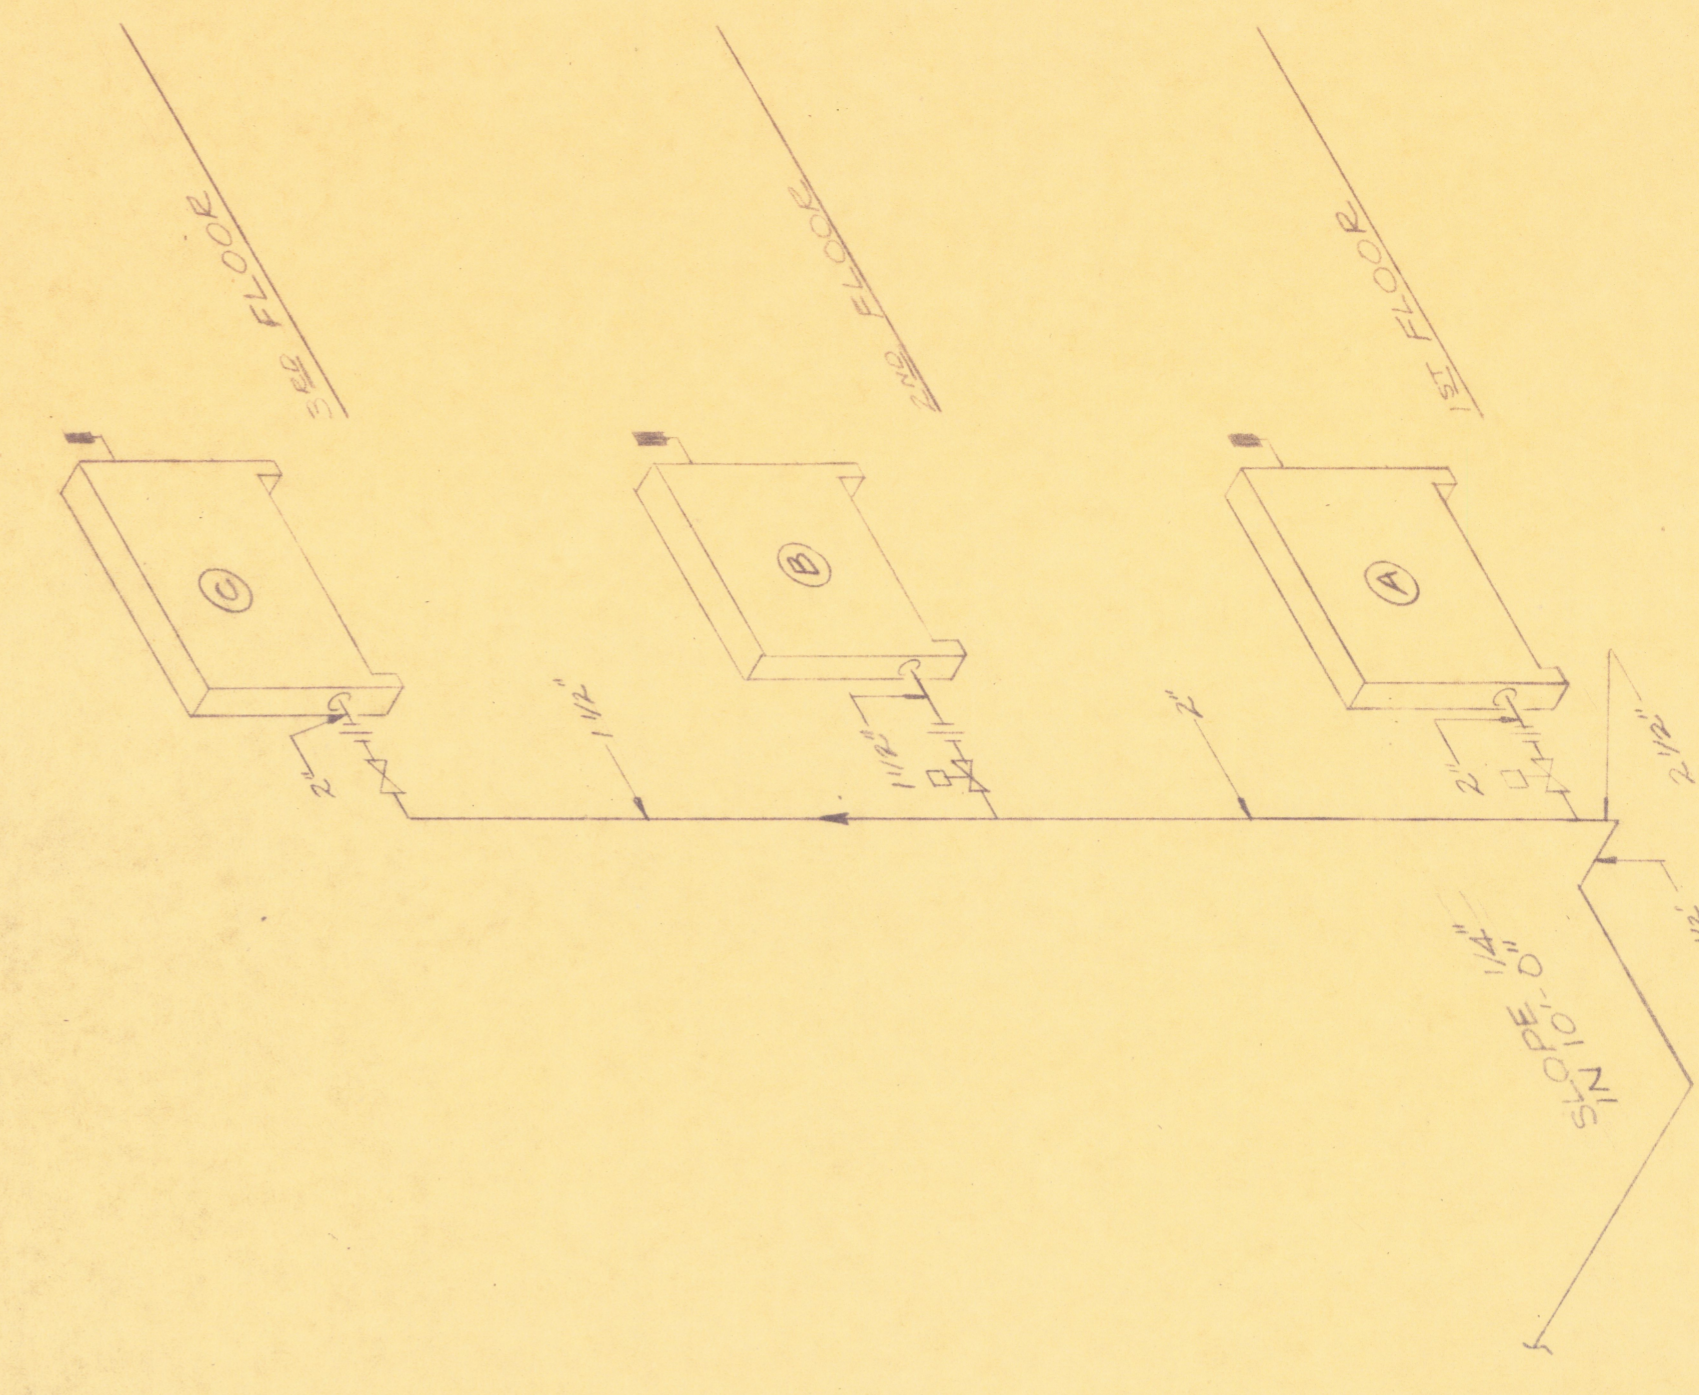

RADIATOR CONNECTION DETAIL
NO SCALE


- LEGEND**
- STEAM
 - PNEUMATIC CONTROL VALVE
 - SLOPE OF MAIN
 - DIRECTION OF FLOW
 - EXISTING BOILER SHUT OFF VALVE
 - THERMOSTAT
 - RADIATOR
 - CONNECT NEW TO EXISTING
 - UNION
 - AUTO AIR VENT
 - GATE VALVE
 - RADIATOR MARK

NOTES

- 1. PITCH OF MAINS SHALL NOT BE LESS THAN 1/4" IN 1'-0" FT.
- 2. PITCH OF HORIZONTAL BRANCHES TO BE PER FLOOR.
- 3. RADIATORS SHOULD NOT BE LESS THAN 1/2" PER FLOOR.

RADIATOR SCHEDULE

MARK	NO OF SECTIONS	HEIGHT	NO OF TUBES	SQ. FT. RADIATION
A	2.6	3.2'	6	103.6
B	2.4	3.2'	6	88.8
C	3.0	3.2'	6	111.0

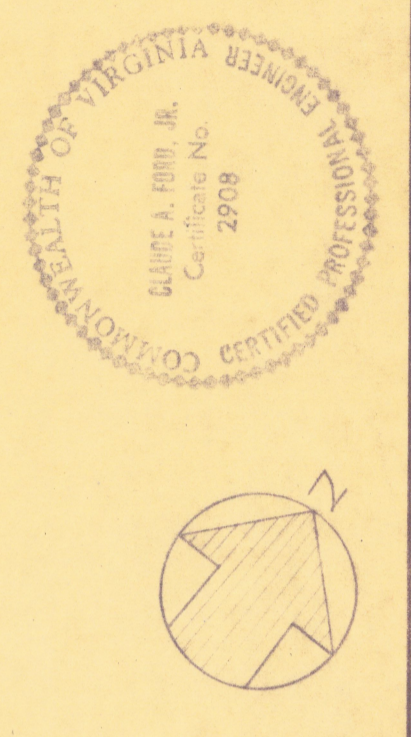

BOOK STACK ADDITION
TO
JONES MEMORIAL LIBRARY
LYNCHBURG, VIRGINIA

CLARK, NEXSEN & OWEN—ARCHITECTS
LYNCHBURG, VIRGINIA
NORFOLK, VIRGINIA

PLANS & DETAIL
SCALE: AS NOTED
DATE: 18 AUG 67
DRAWN BY: EES
CHECKED BY: THH
DWG. NO.: M-1