

- ARCHITECTURAL
- STRUCTURAL
- CIVIL
- MECHANICAL
- ELECTRICAL

CLARK, NEXSEN & OWEN
ARCHITECTS & ENGINEERS
COMPUTATIONS SHEET


JOB NO.

COMPUTED BY EES
CHECKED BY CAF
DATE JULY 27 19 70

PROPOSED ADDITION TO
AIR CONDITIONING

PROJECT GUGG. MEMORIAL HOSPITAL
SHEET NO. 1 OF 2 SHEETS

FOR ADDITIONAL PIPING LAYOUT
SEE "FAN COIL SYSTEM PIPING
DIAGRAM" SHEET M-6.

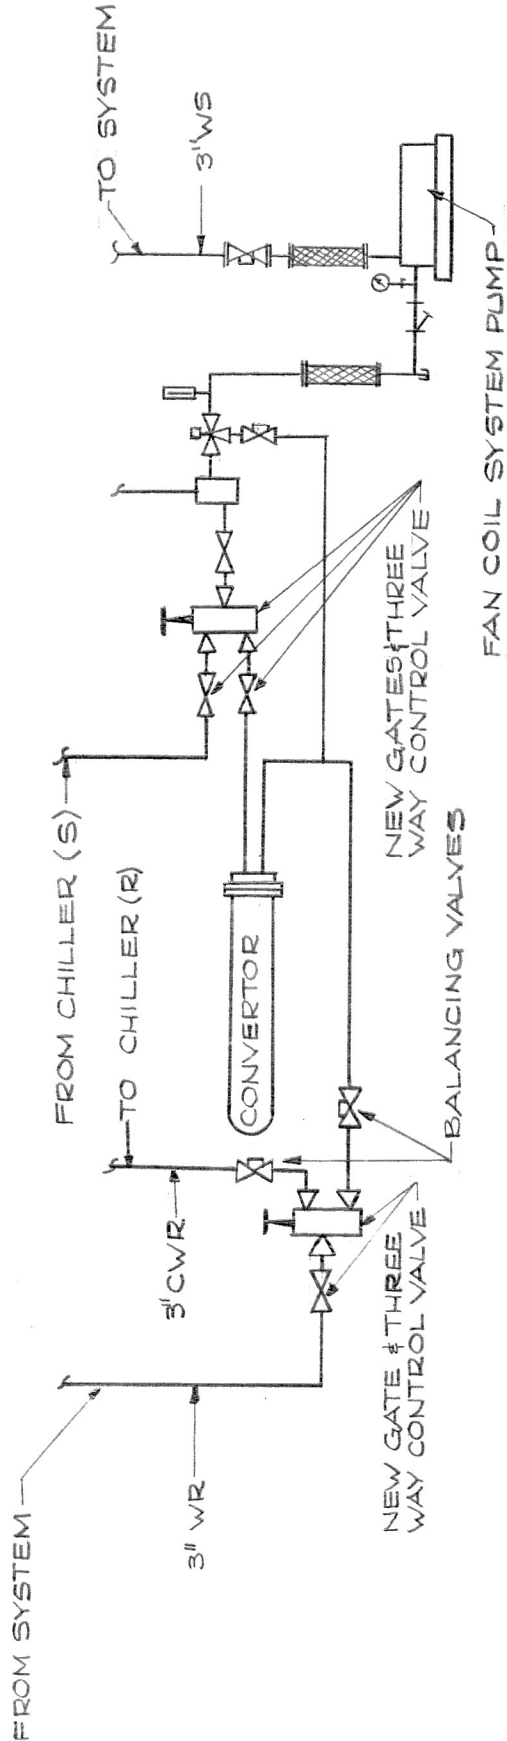

REVISIONS TO FAN COIL PIPING SYSTEM