

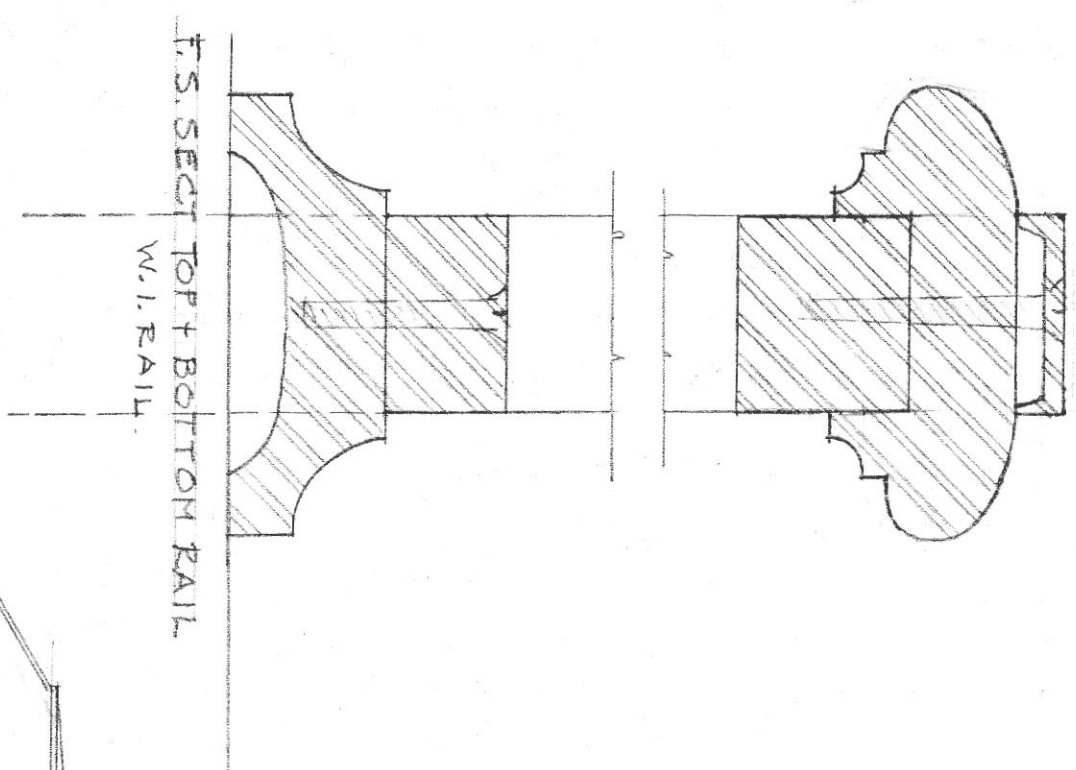



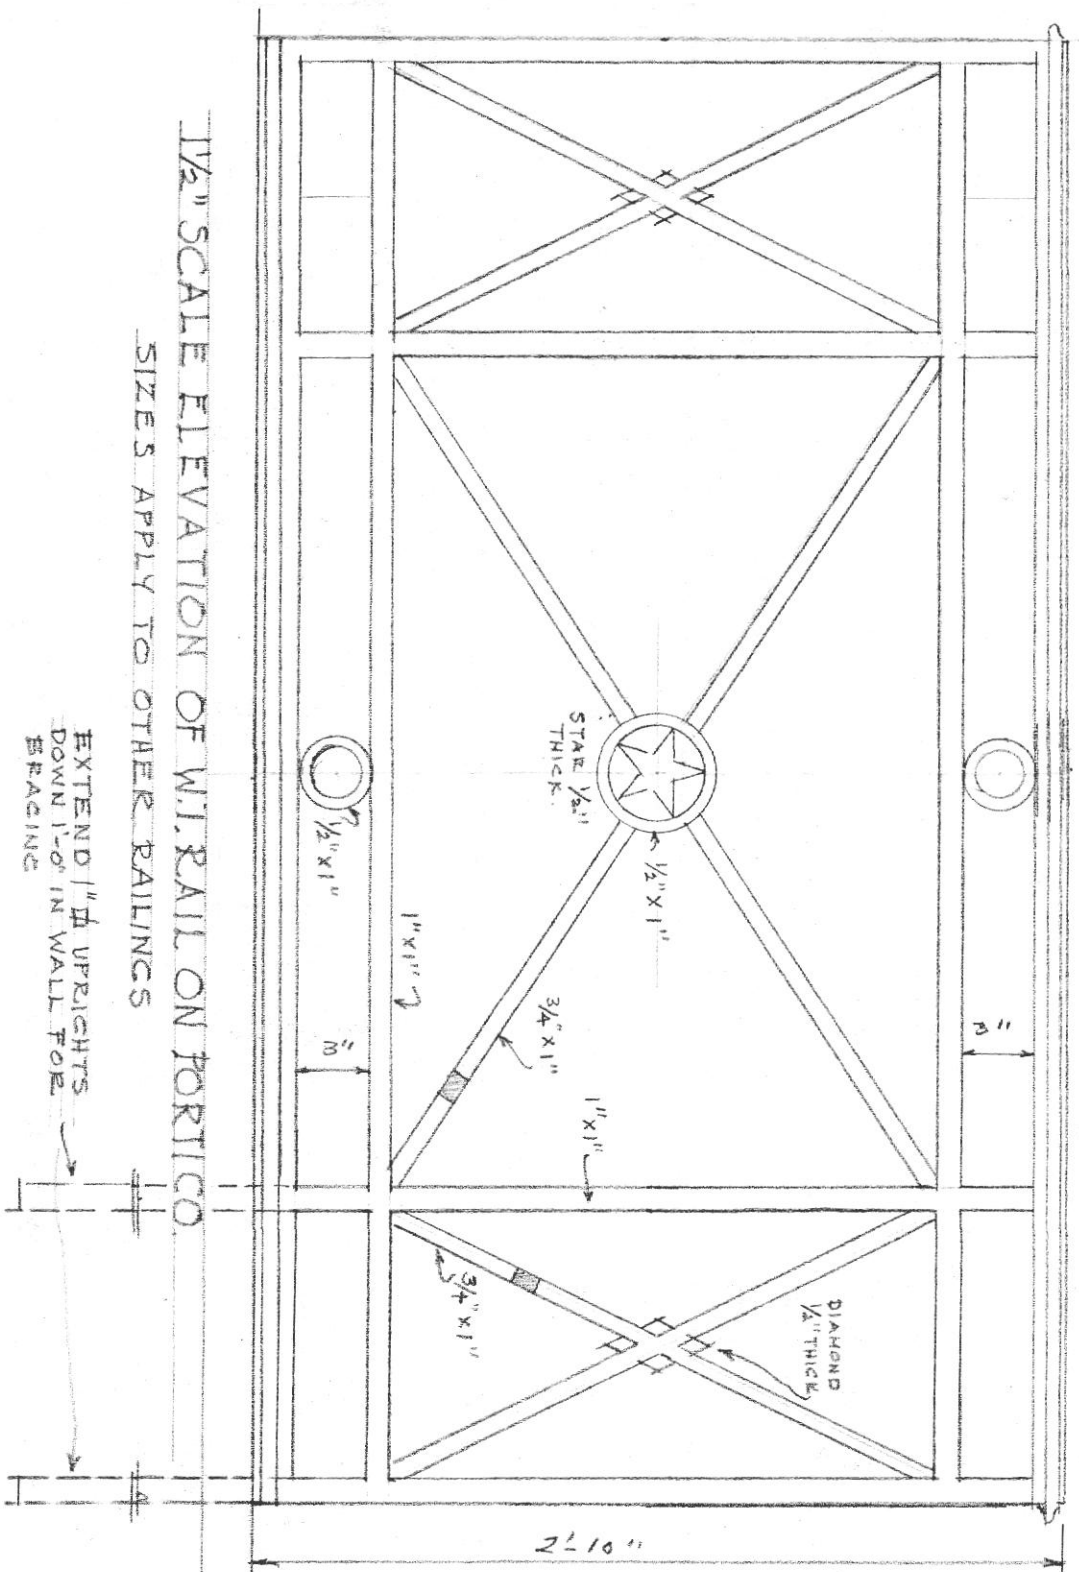


METAL WINDOWS, X-Y+Z TO FIT SAME
SIZE BRICK OPENINGS AS CORRESPONDING
WINDOWS A-B+C. METAL FRAMES WIDE GLASS
WOOD OUTSIDE T.E. IN. WITH MOUNTINGS
NOT TO EXCEED 1 1/2" IN WIDTH.

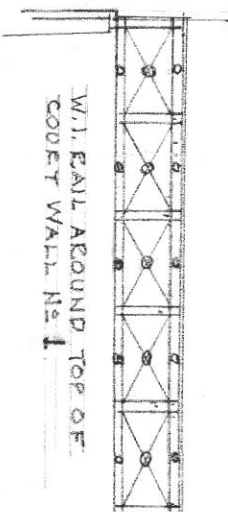

FRONT ELEVATION.
SCALE 1/8" = 1'-0"

 NOTE.
ALL DOWN SPOUNS 4" COPPER.
ALL D.S. BRANDS COPPER. ALL SHIMS CAST IRON.

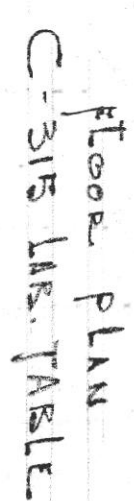


RANDOLPH MASON WOMAN'S COLLEGE

KELLY KILPATRICK

LYNCHBURG VIRGINIA


EQUIPMENT PLAN
SHEET # 2A.

SHEET # 2A

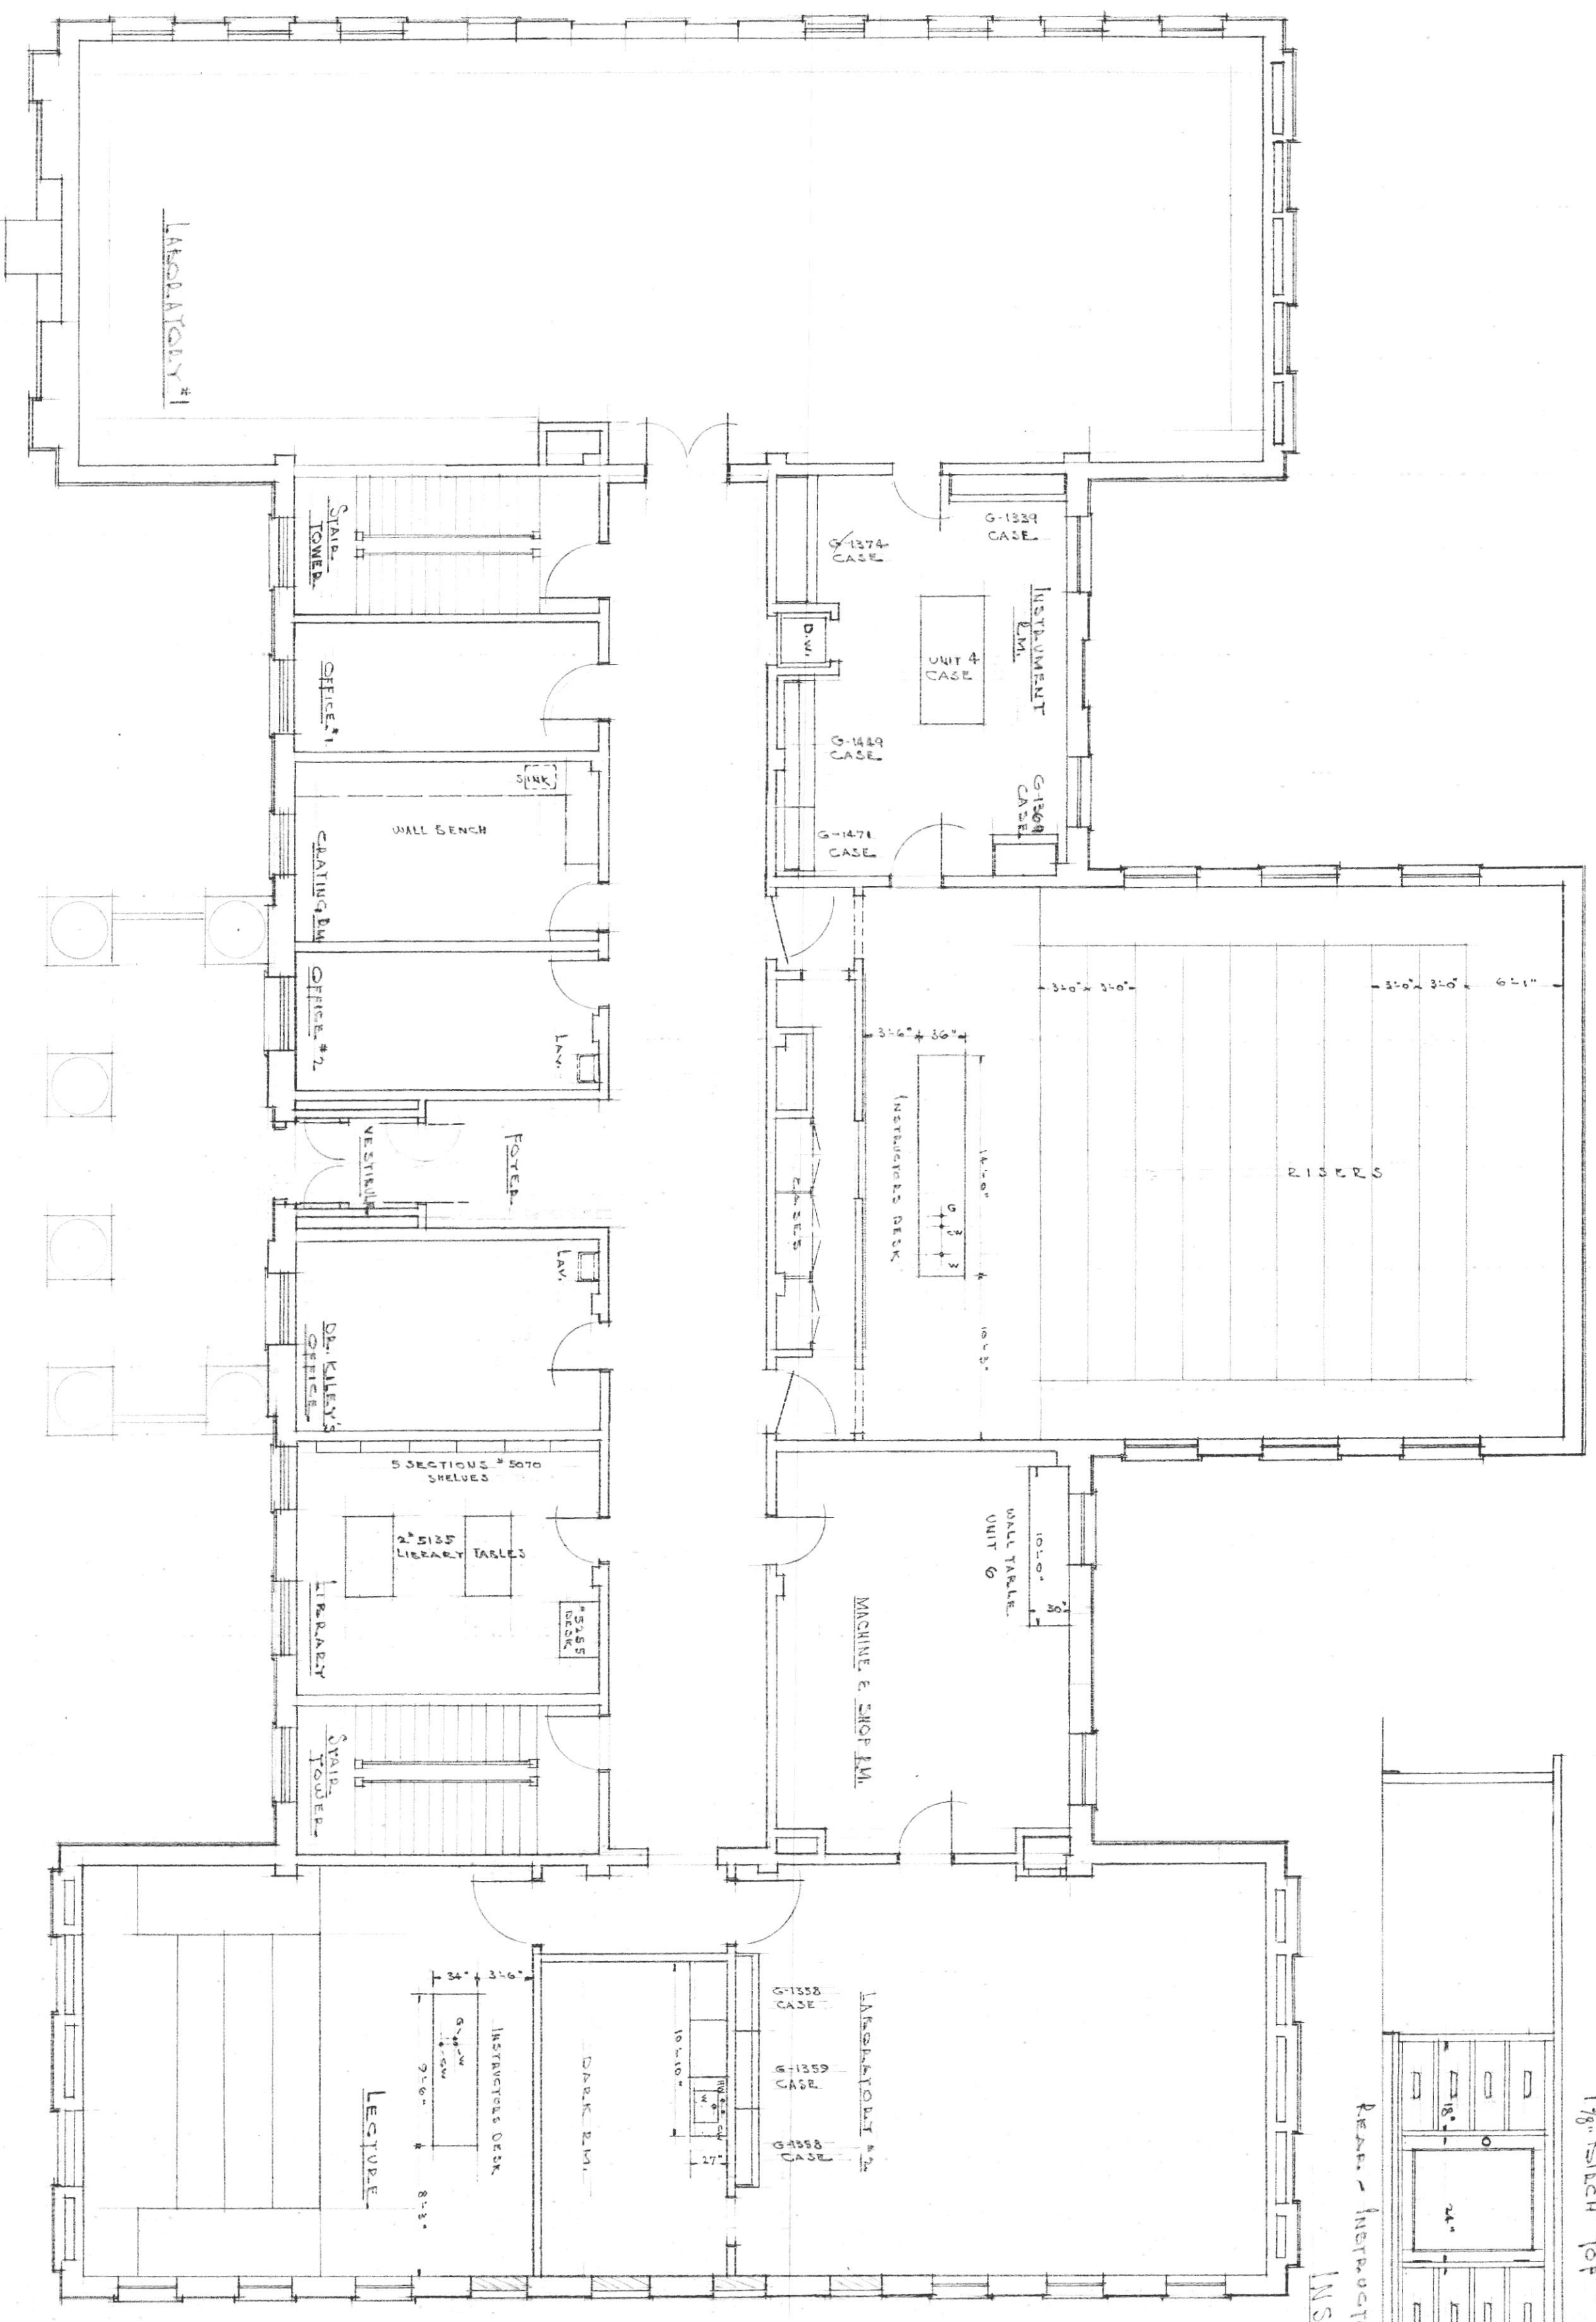


FIRST FLOOR PLAN
SCALE 1/8" = 1'-0"


RANDOLPH MACON WOMANS COLLEGE
NEW SCIENCE BUILDING
LYNCHBURG VIRGINIA

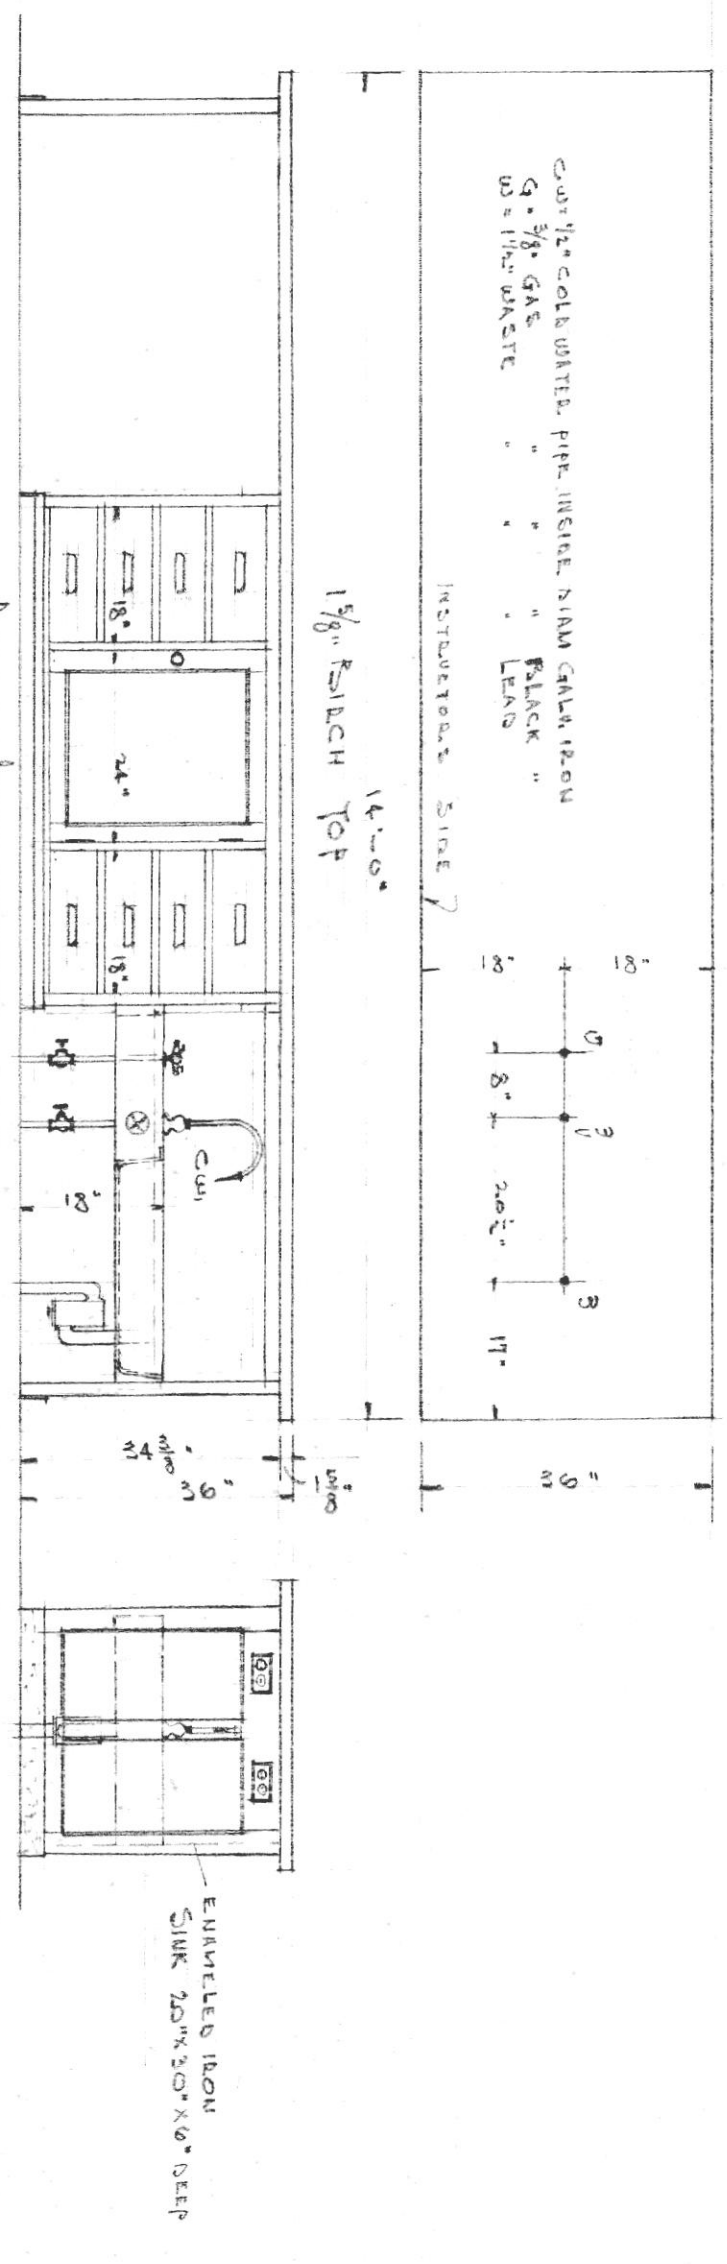



INSTRUCTOR'S DESK

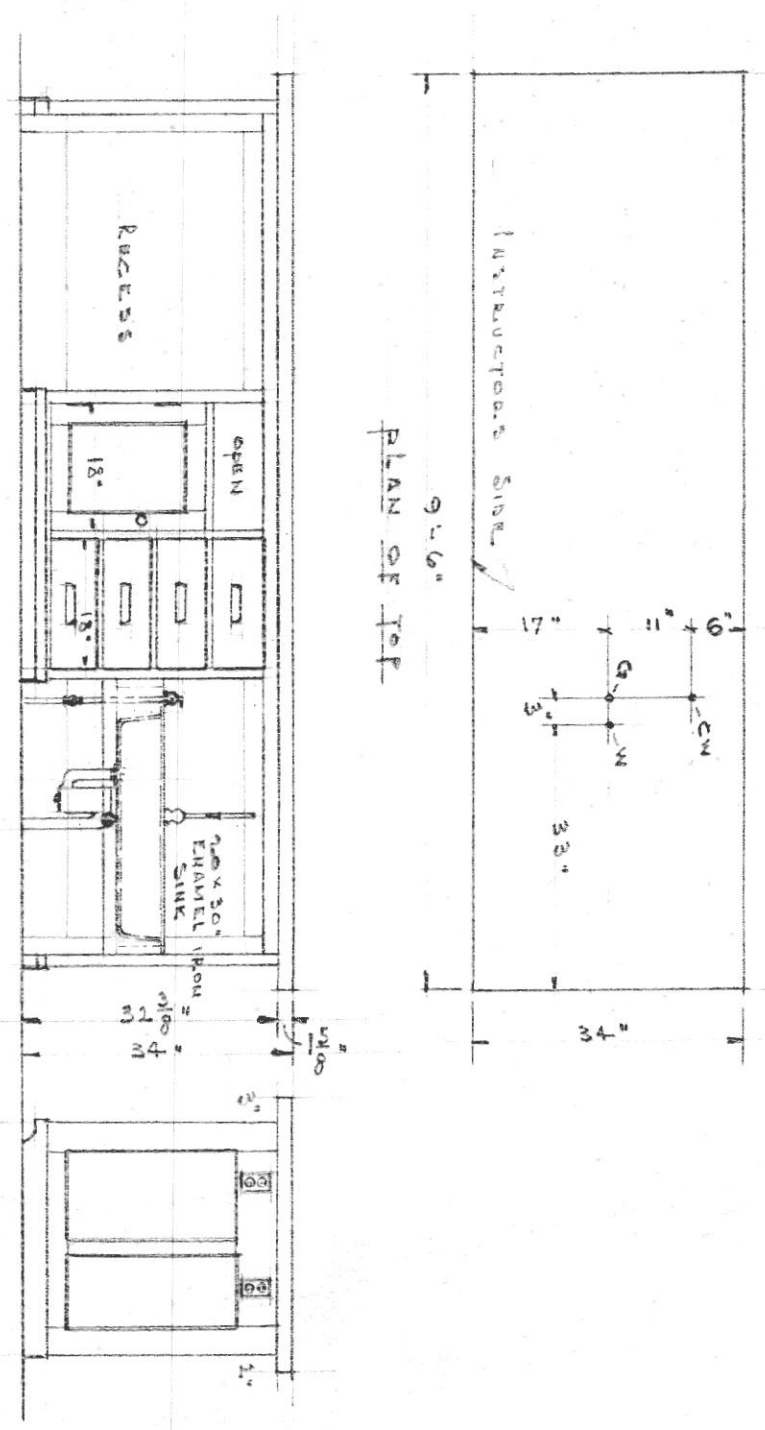



INSTRUCTOR'S DESK

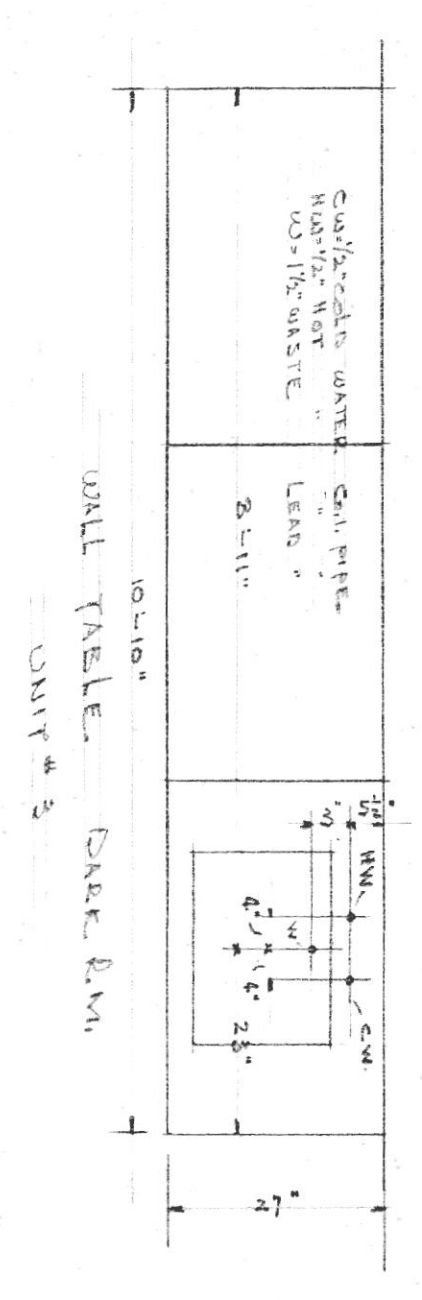

WALL TABLE

  

  C.W. = $\frac{1}{8}$ " GALV IRON COLD WATER PIPE - INS. DIA. - 68 $\frac{1}{4}$ " ABOVE FLOOR,
H.W. = $\frac{1}{2}$ " " HOT " " " " " " "
W. = $\frac{1}{4}$ " LEAD WASTE PIPE - " " " " " " "



SYMBOLS

C.W. ¹ / ₈ " COLD WATER PIPE - INSIDE DIM.	CALK IRON,
H.W. ¹ / ₈ " HOT WATER "	" "
G. ¹ / ₂ " GAS "	" BLACK "
G. ¹ / ₂ " H.S. "	" LEAD "
S.R. ¹ / ₈ " SYRNEY " "	" BLACK "
E.R. ¹ / ₈ " " "	" "
" WASTE PIPE "	" LEAD "
V. ⁶ / ₁₆ " DIA FLOOR DRAINING - 8'-10" ABOVE FLOOR - BROOM FIXTURE REQUIRED.	
F. ⁸ / ₈ " " " - 8'-10" "	" - 240 CMH "
F. ⁴ / ₄ " " " - 8'-6" "	" - 240 CMH "
V. ⁴ / ₈ " VENT OPENING IN FLOOR - SLIC OPENING REQUIRES EXHAUST OR 385 C.M.H.	
E.C. ¹ / ₈ " ELECTRIC CONDUIT TO FLOOR	
A.C. ¹ / ₈ " ALTERNATING CURRENT CONDUIT TO FLOOR.	
D.C. ¹ / ₈ " DIRECT "	

BATHING ROOM ELECTRICAL CONTRACTOR TO PROVIDE OUTLET IN WALL WHERE DIRECTED BY ARCHT PLUMBING CONTRACTOR TO 5'7" SERVICE LINE IN WALL FOR WALL SINKS . SEE PLAN ABOVE FOR WALL SINK FULL

DIMENSIONAL LOCATION OF OBJECTS

Scale factor = 1.01

RANDOLPH MACON'S COLLEGE

PH.D. SCIENCE

LYNCHBURG,

VIRGINIA.

EQUIPMENT PLAN.
SHEET # 4-A-A.