

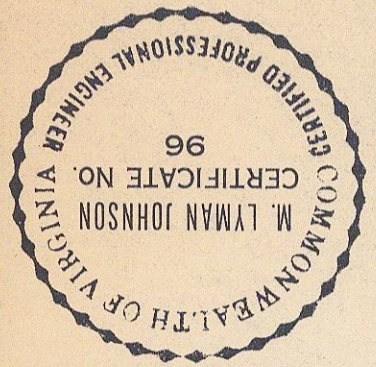



These construction documents are for use in connection with the project described herein. They are to be used only with the agreement in writing of the appropriate authority. The user shall indemnify and hold the Architect/Engineer harmless from and against all claims, damages, losses and expenses arising out of or resulting from the use of these documents.

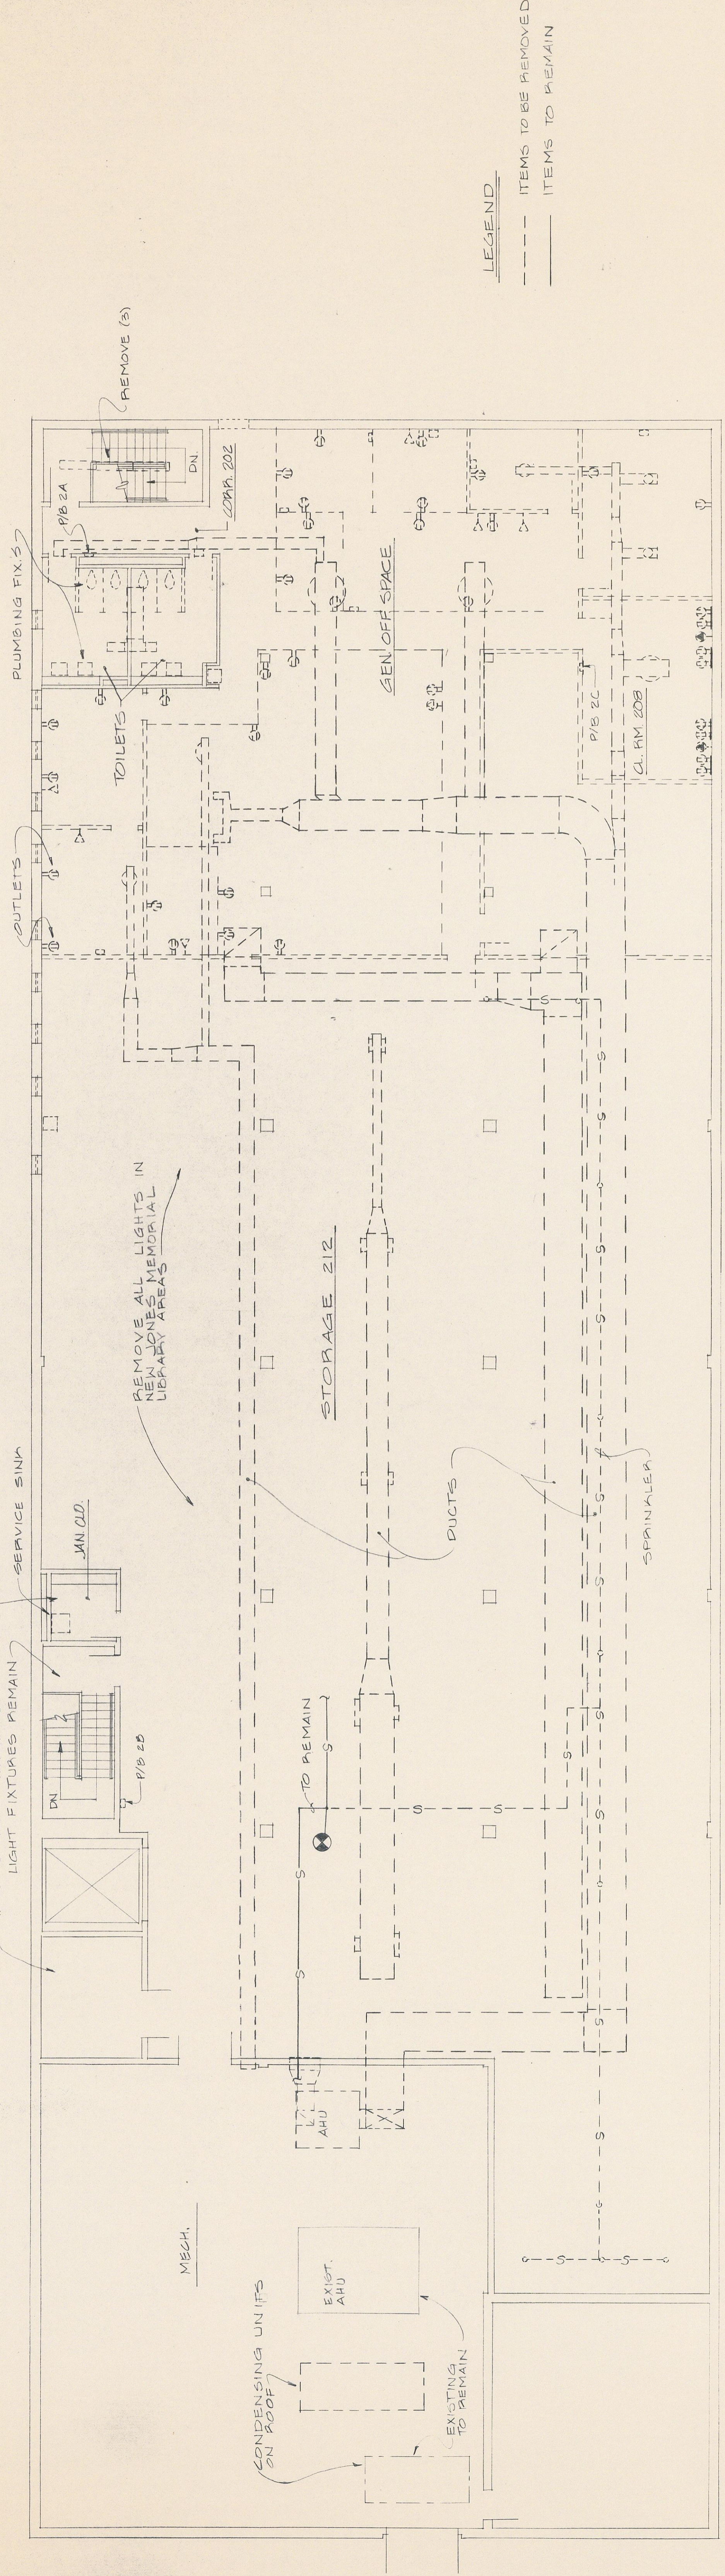


Simpson • Johnson, Inc.
 CONSULTING ENGINEERS
 207 CLAY STREET, LYNCHBURG, VIRGINIA 24504

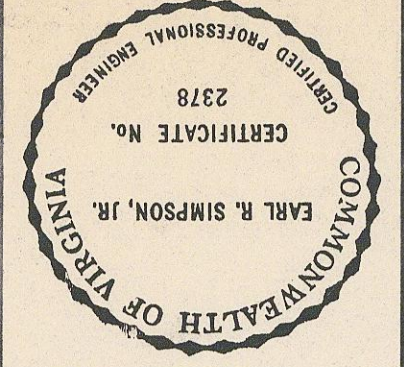


DEMOLITION - SECOND FLOOR PLAN
 SCALE: 1/8" = 1'-0"

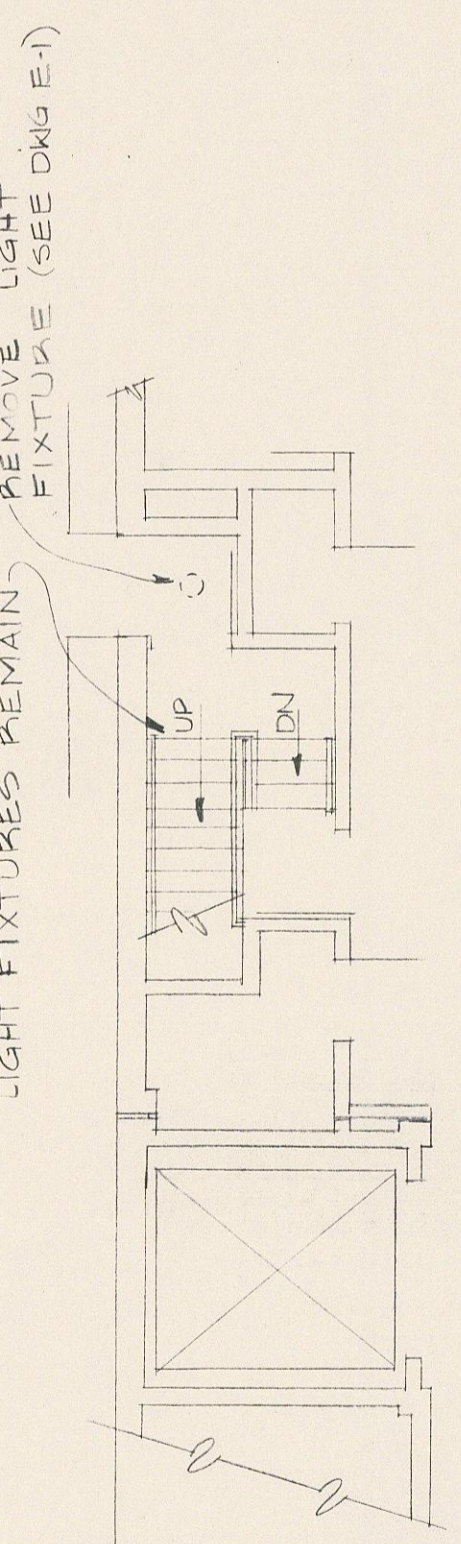

DEMOLITION - PART FIRST FLOOR PLAN
 SCALE: 1/8" = 1'-0"

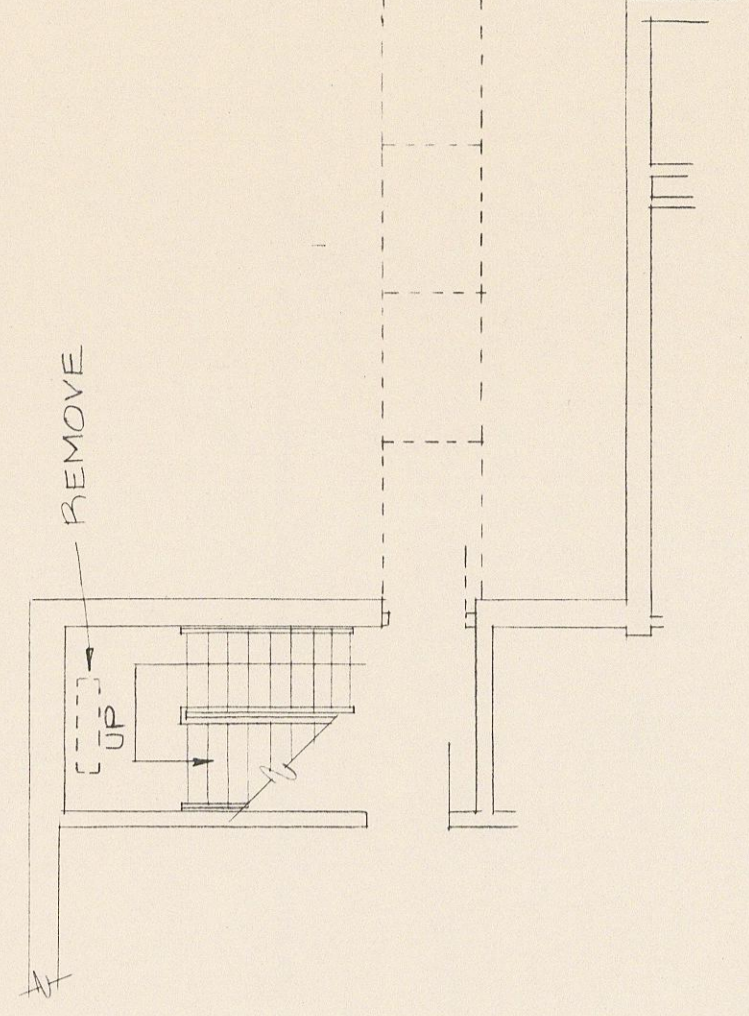

DEMOLITION - PART FIRST FLOOR PLAN
 SCALE: 1/8" = 1'-0"

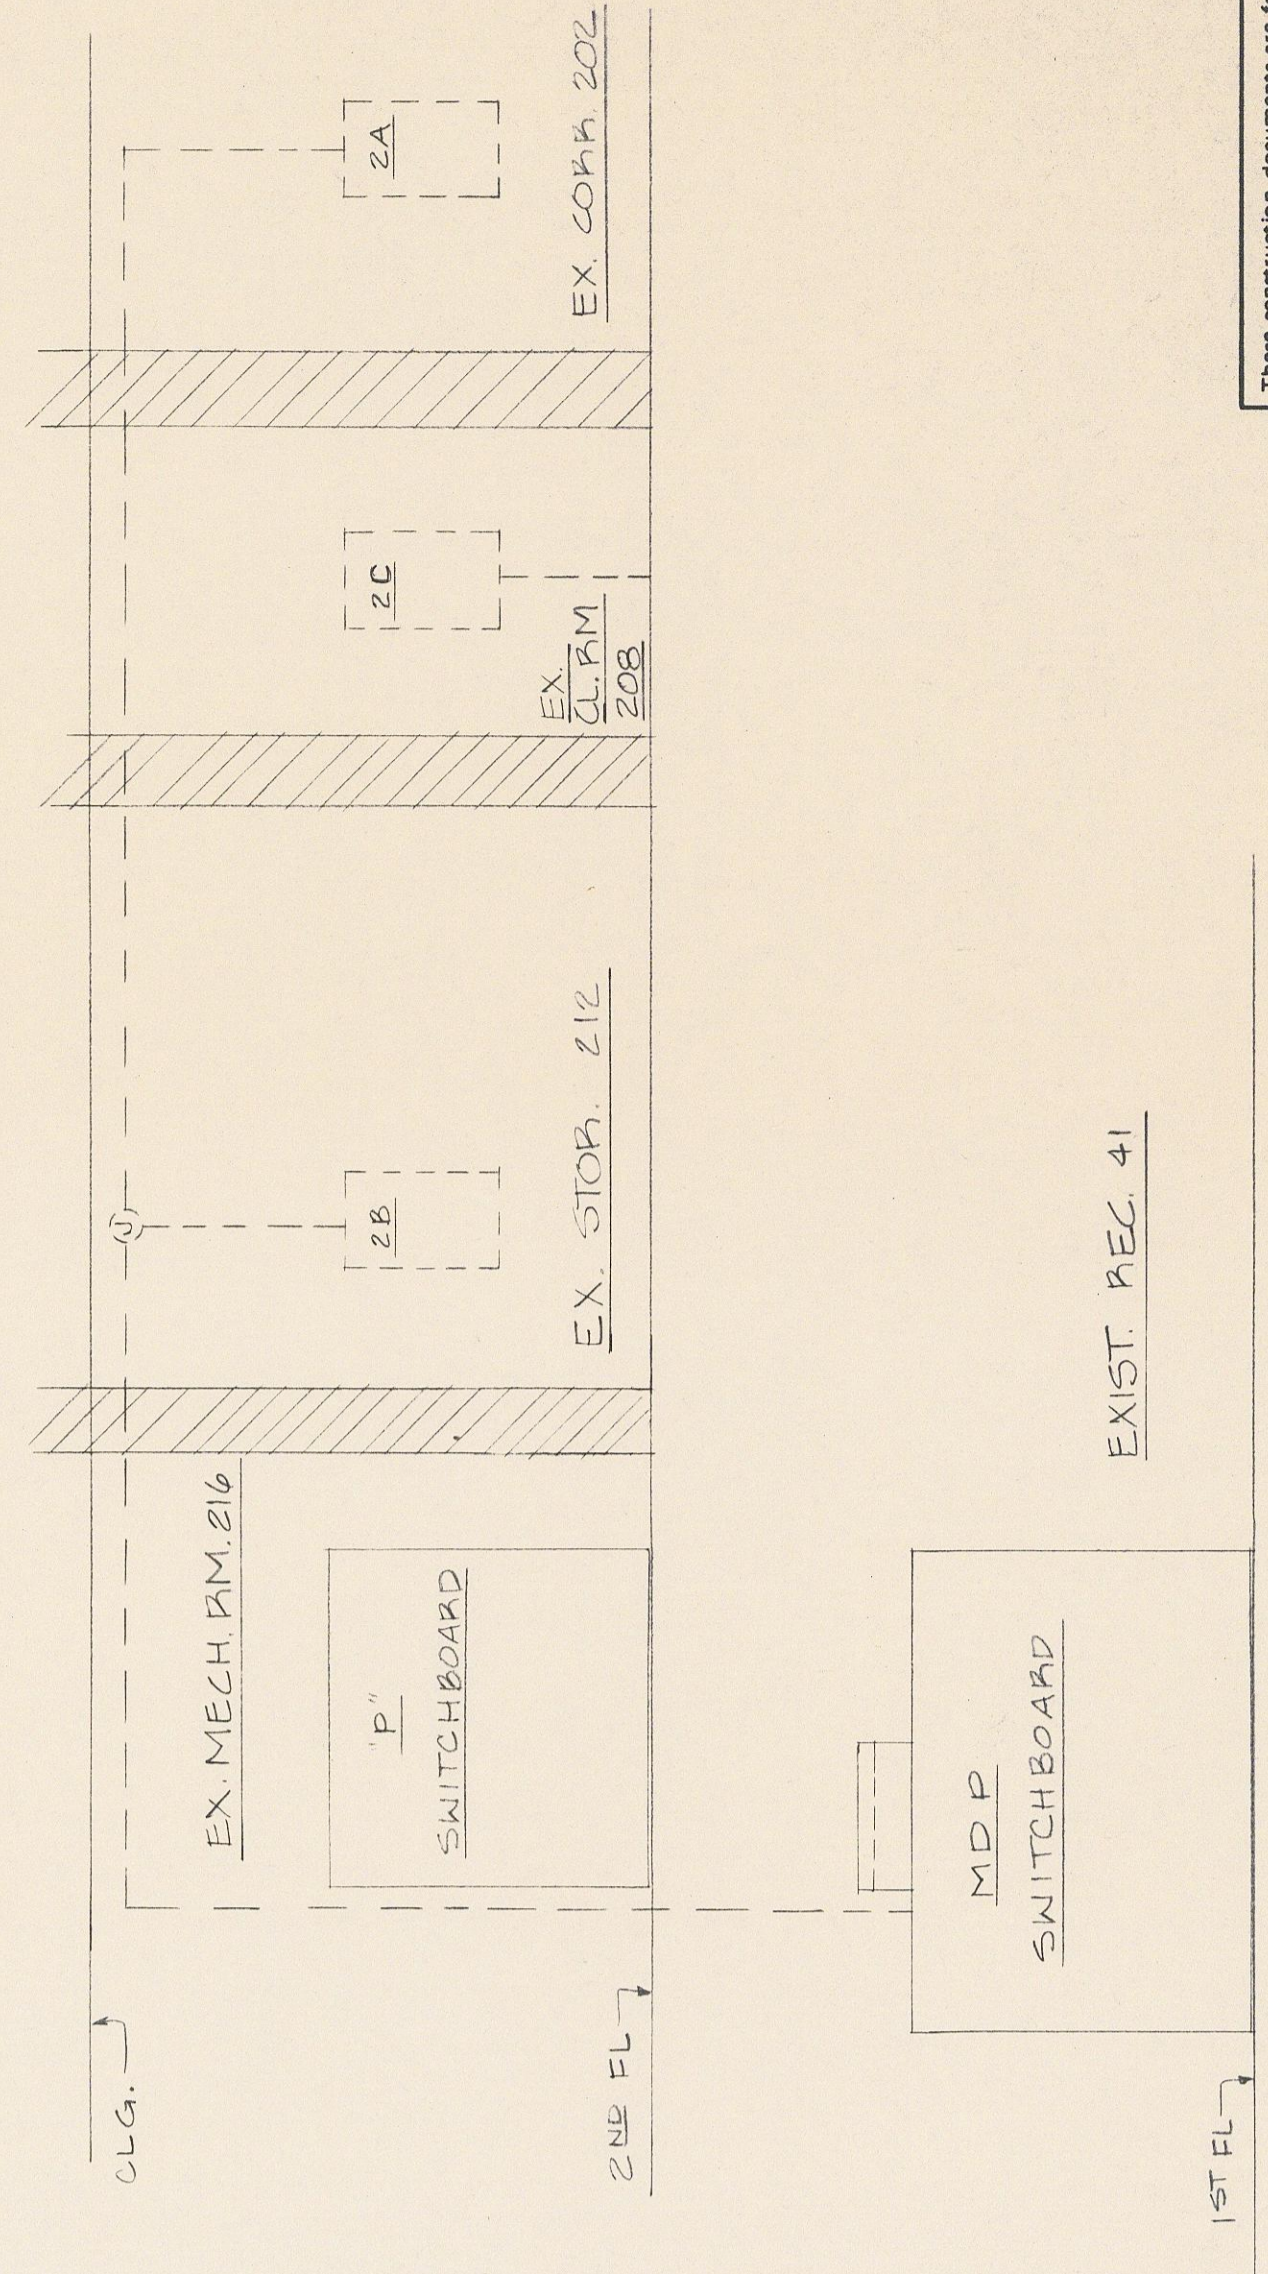

EXIST. REC. 41

POWER RISER DIAGRAM - DEMOLITION
 NOT TO SCALE