

# HUNTON BRANCH Y.M.C.A.


## LYNCHBURG, VIRGINIA

### LEGEND OF ABBREVIATIONS

AC.T.	ACCOUSTIC TILE
AS.T.	ASPHALT TILE
BR.	BRICK
C.B.	CONCRETE BLOCK
CONC.	CONCRETE
C.I.	CAST IRON
C.P.	CEMENT PLASTER
C.T.	CERAMIC TILE
EXP.C.B.	EXPOSED CONCRETE BLOCK, NEATLY LAID, TOOLED JOINTS
G.B.	GLAZED BRICK
G.I.	GALVANIZED IRON
GP.AS.T.	GREASEPROOF ASPHALT TILE
G.S.T.	GLAZED STRUCTURAL TILE
H.W.P.	HARD WHITE PLASTER
K.CEM.	KEENE CEMENT
MET.	METAL
PL.	PLASTIC WALL COVERING
PL.GL.	PLATE GLASS
PL.T.	PLASTIC TILE
S.S.	SERVICE SINK (BY PLUMBING CONTRACTOR)
UNFIN.	ROUGH MASONRY OR CONCRETE
V.C.	VITREOUS CLAY
V.P.	VERMICULITE PLASTER
WD.	WOOD
W.I.	WROUGHT IRON

### LEGEND OF MATERIALS

	CONCRETE
	BRICK
	CONCRETE BLOCK
	STONE OR GL. ST. TILE
	WOOD
	CERAMIC TILE
	ACCOUSTIC TILE
	GLASS BLOCK
	METAL LARGE SCALE
	METAL SMALL SCALE

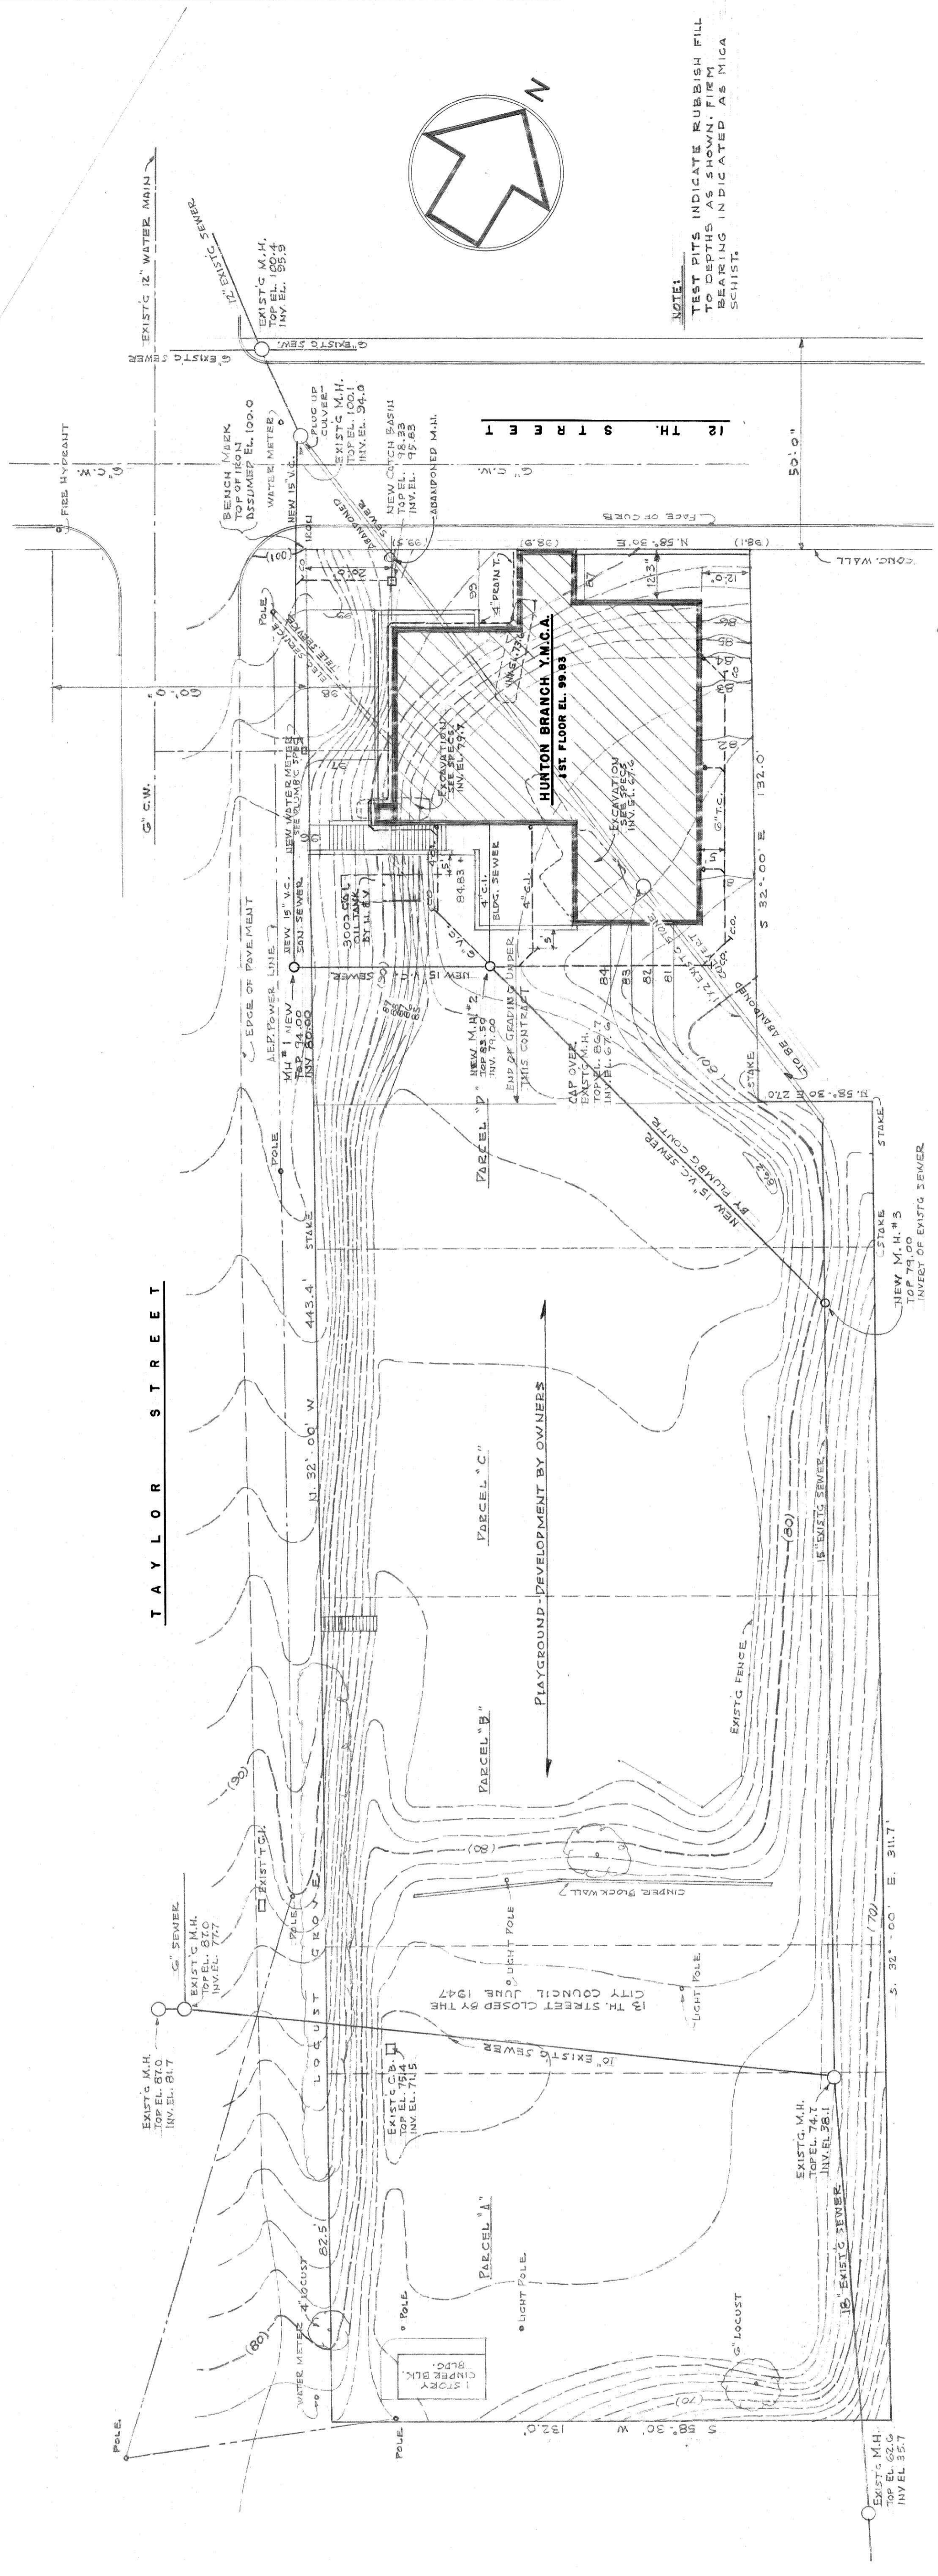

S I T E P L A N  
SCALE 1" = 20' - 0"

HUNTON BRANCH Y.M.C.A.  
LYNCHBURG, VIRGINIA  
FOR YOUNG MEN'S CHRISTIAN ASSOCIATION  
LYNCHBURG, VIRGINIA

PENLETON S. CLARK, ARCHITECT  
LYNCHBURG, VIRGINIA

DATE	AUG. 1936
SCALE	1" = 20' - 0"
DRAWN BY	G.L.Y.
CHECKED	G.S.
SITE	I


















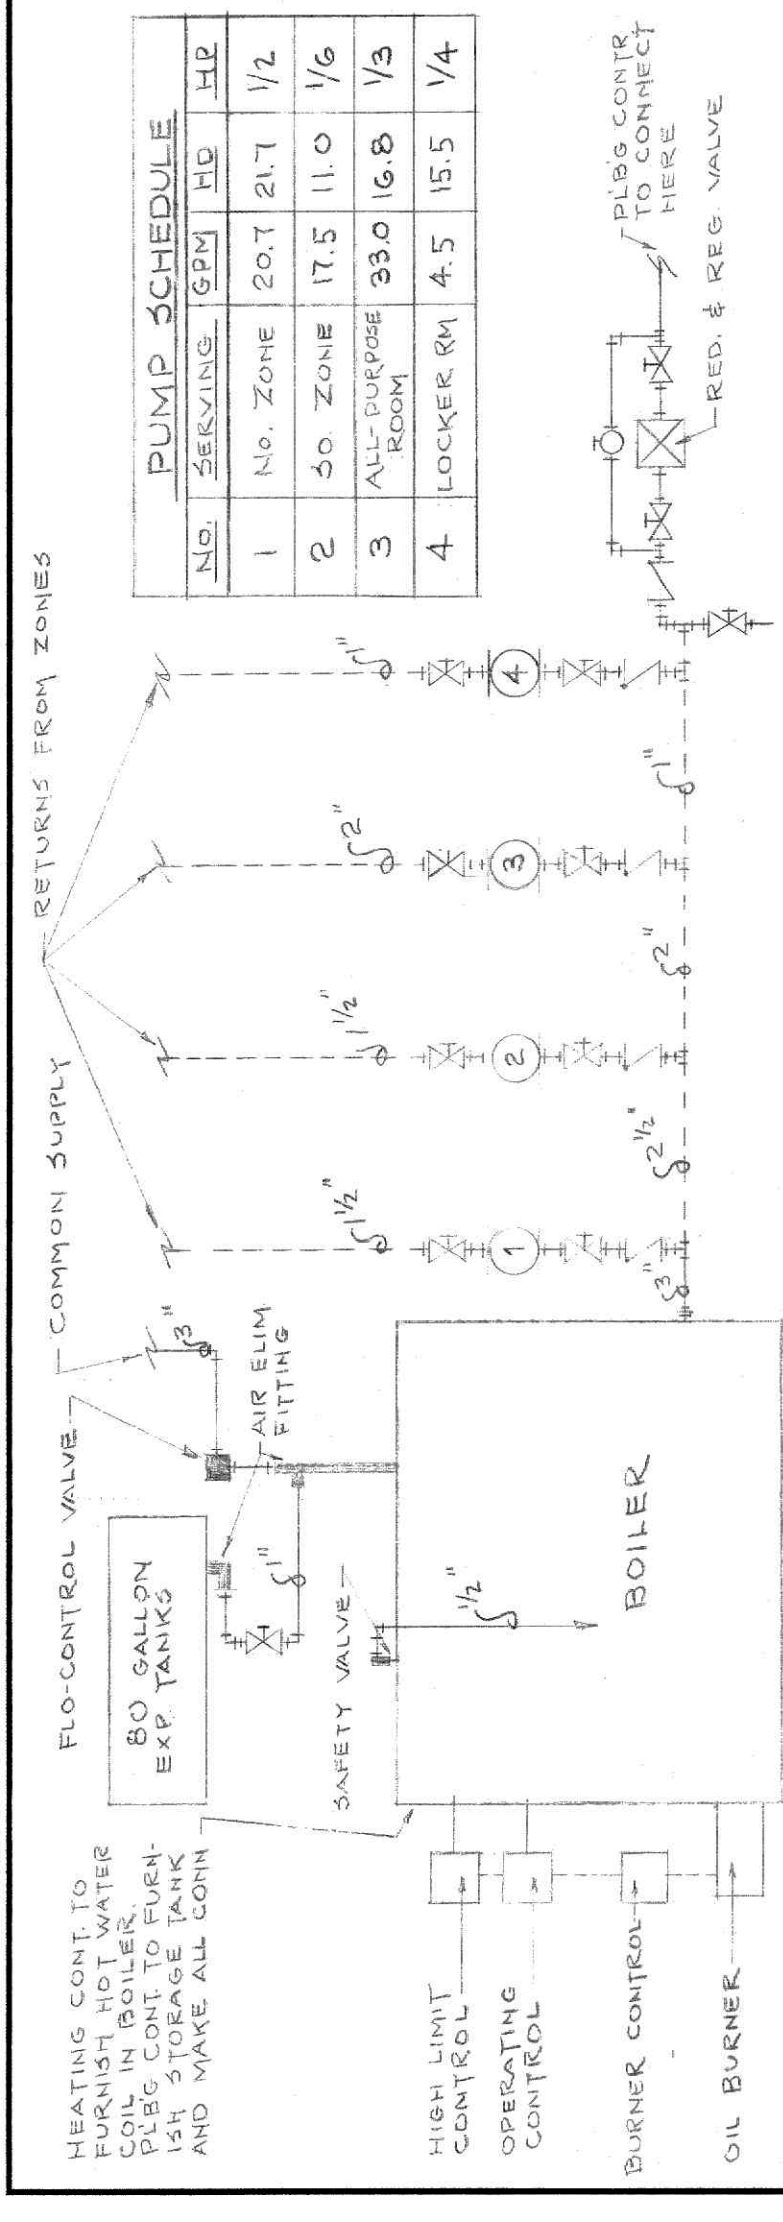


PUMP SCHEDULE			
NO.	ZONE	DIS.	H.Z.
1	NO. ZONE	20.1	1/2
2	SO. ZONE	17.5	1/2
3	ALL-PURPOSE ROOM	33.0	1/3
4	LOCKER RM.	4.5	1/4

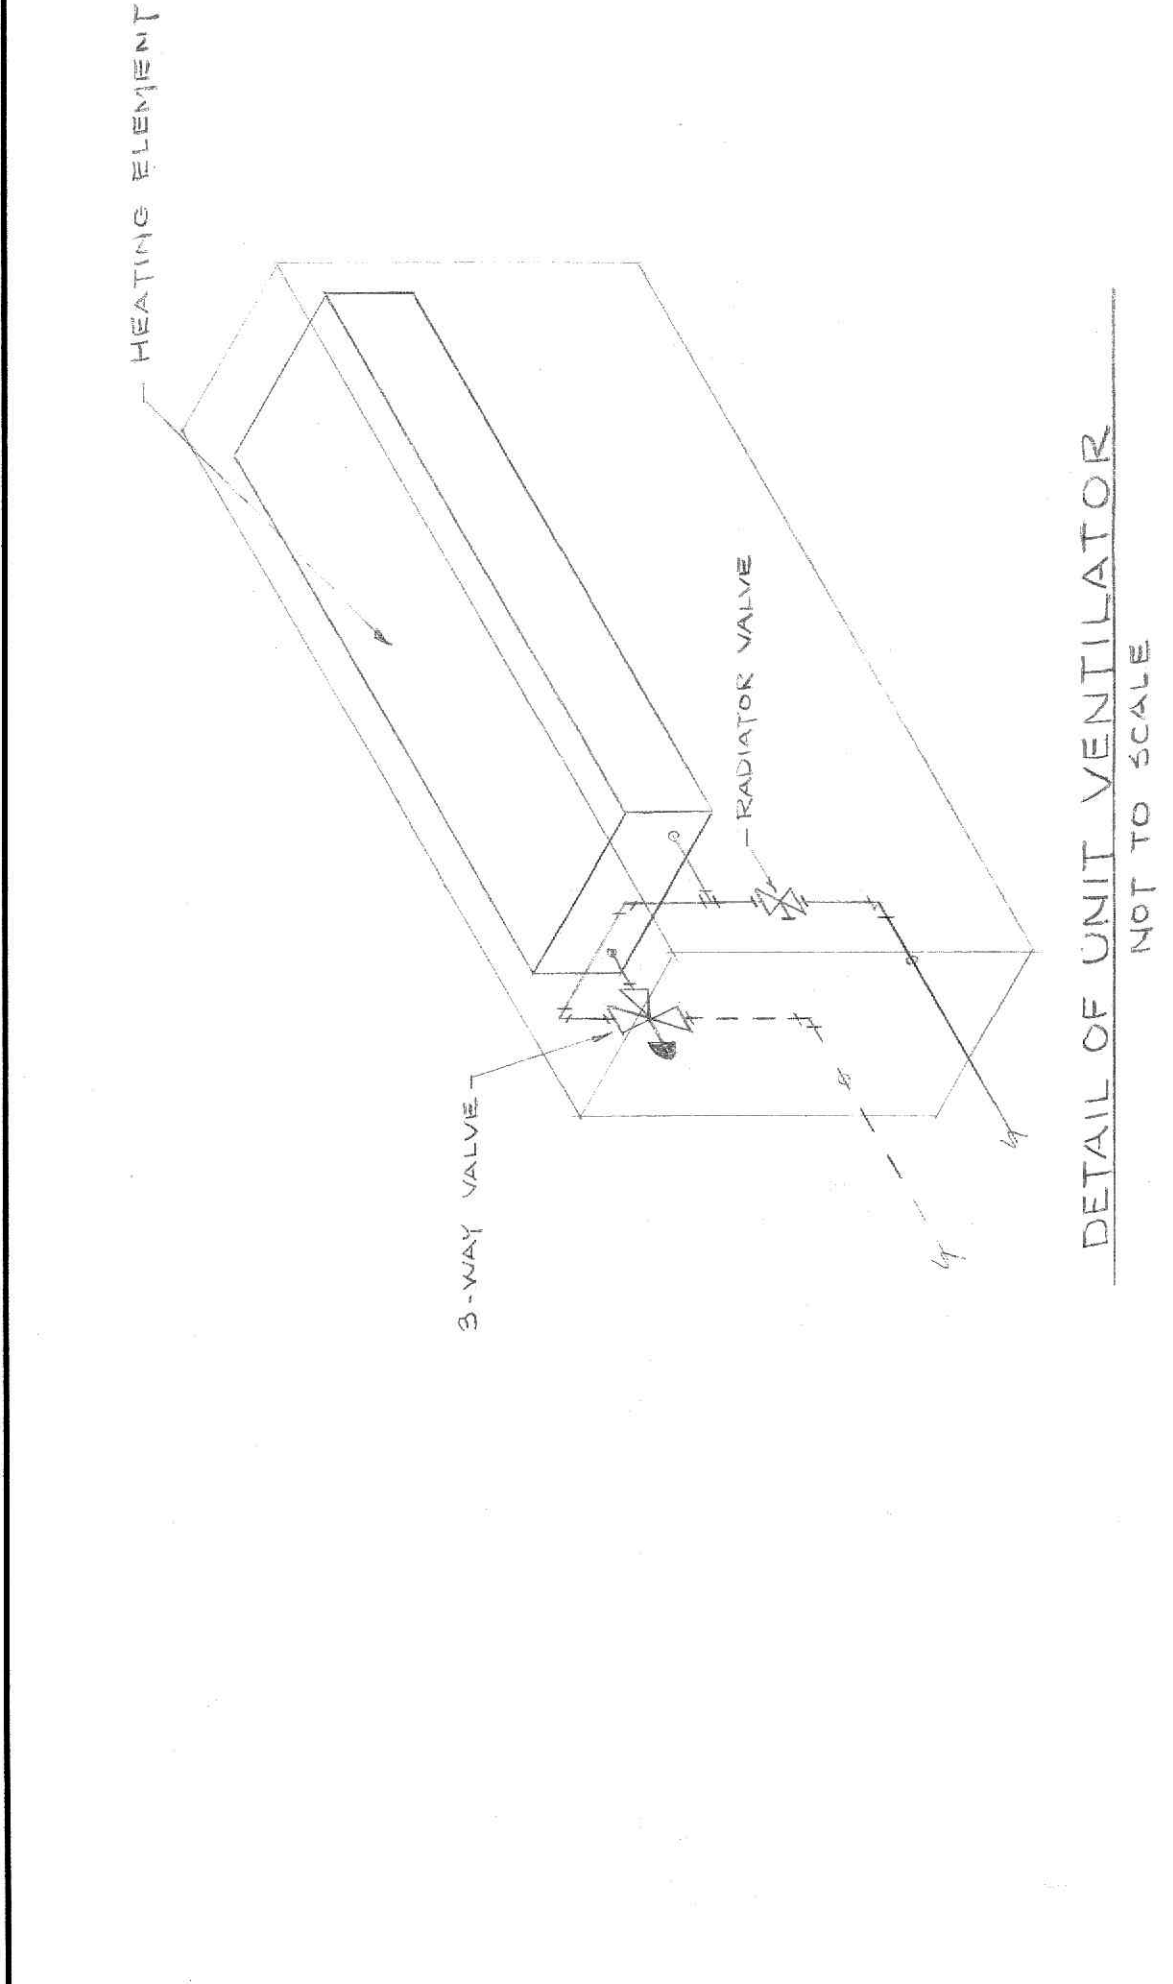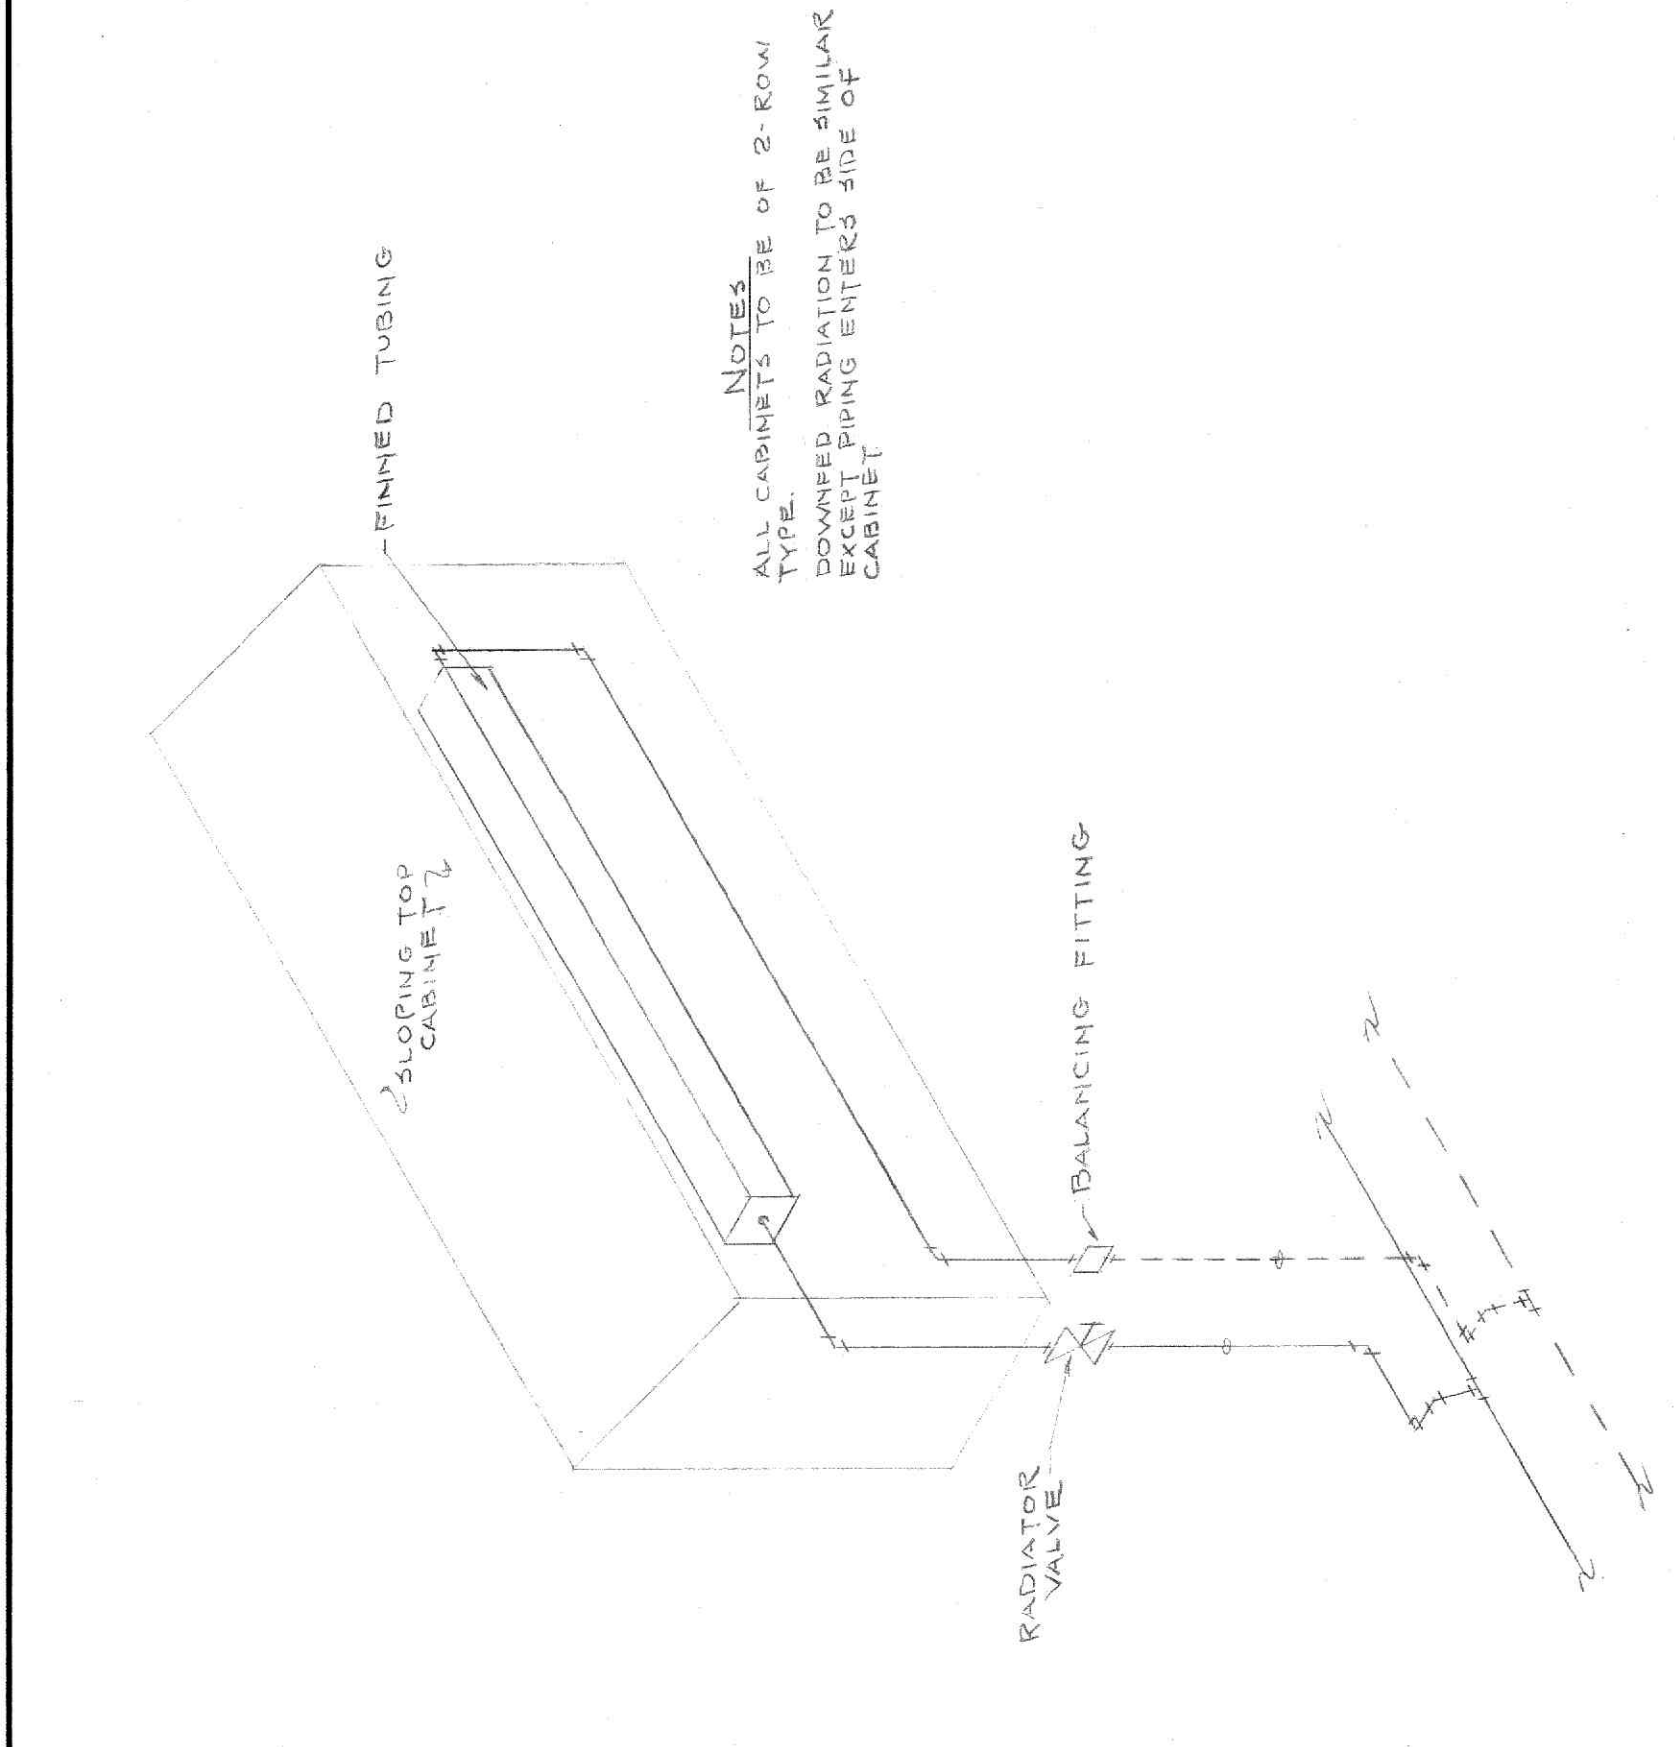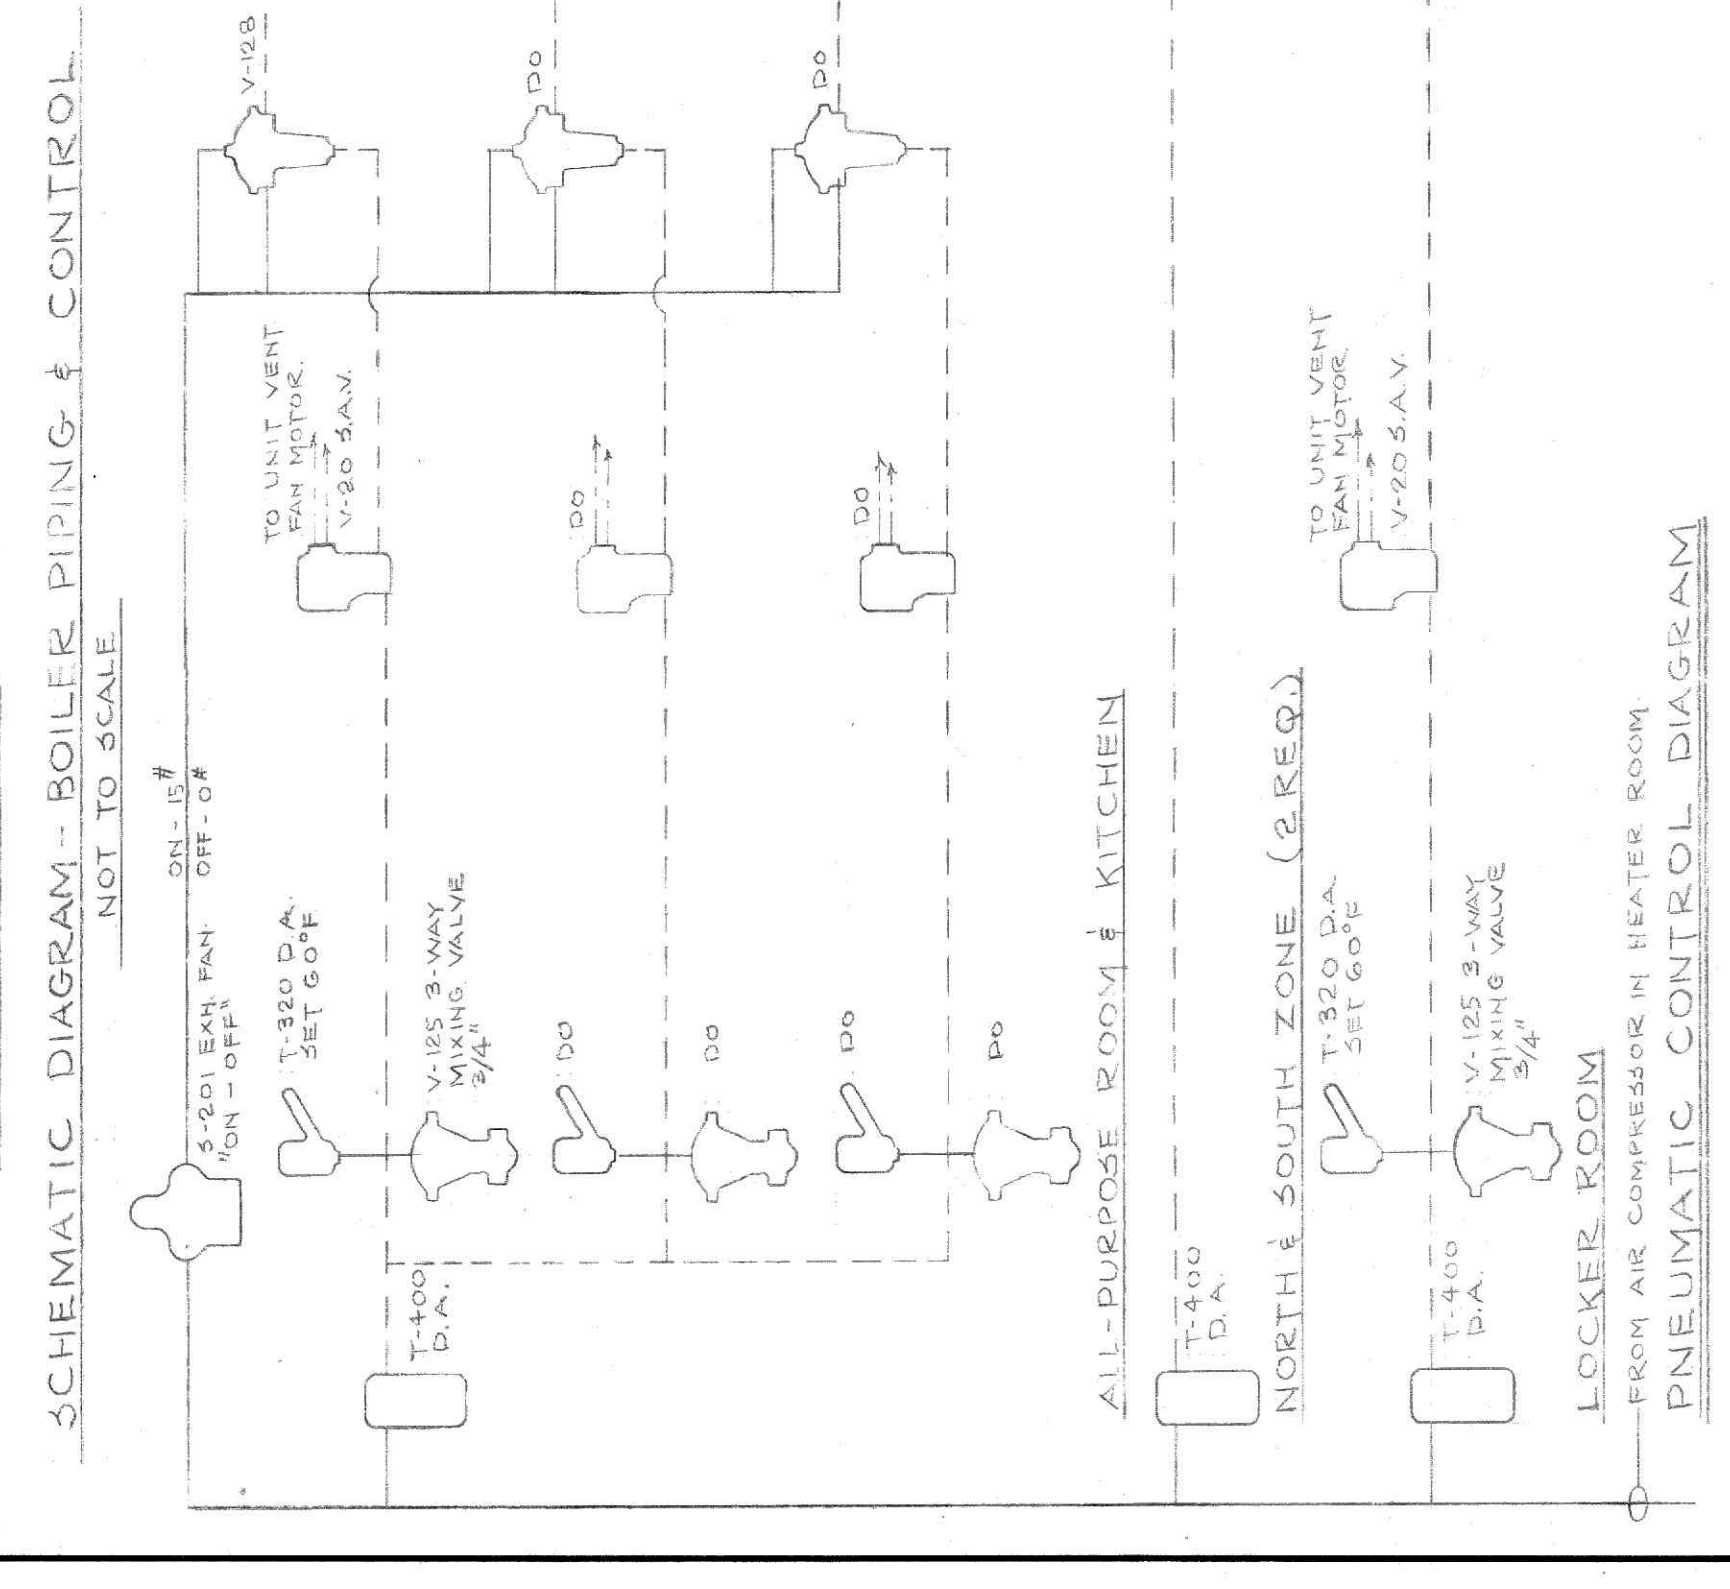


UNIT VENT. SCHEDULE			
UNIT NO.	CFM	% TOTAL S.A. MBH	TYPE
1	1000	100	FLOOR MTD 28" H.
2	DO	DO	DO
3	DO	DO	DO
4	500	50	DO

FAN SCHEDULE			
FAN NO.	SECT.	AREA	HP
F-1	KITCHEN	3000	1/8
F-2	LOCKER ROOM	450	1/8

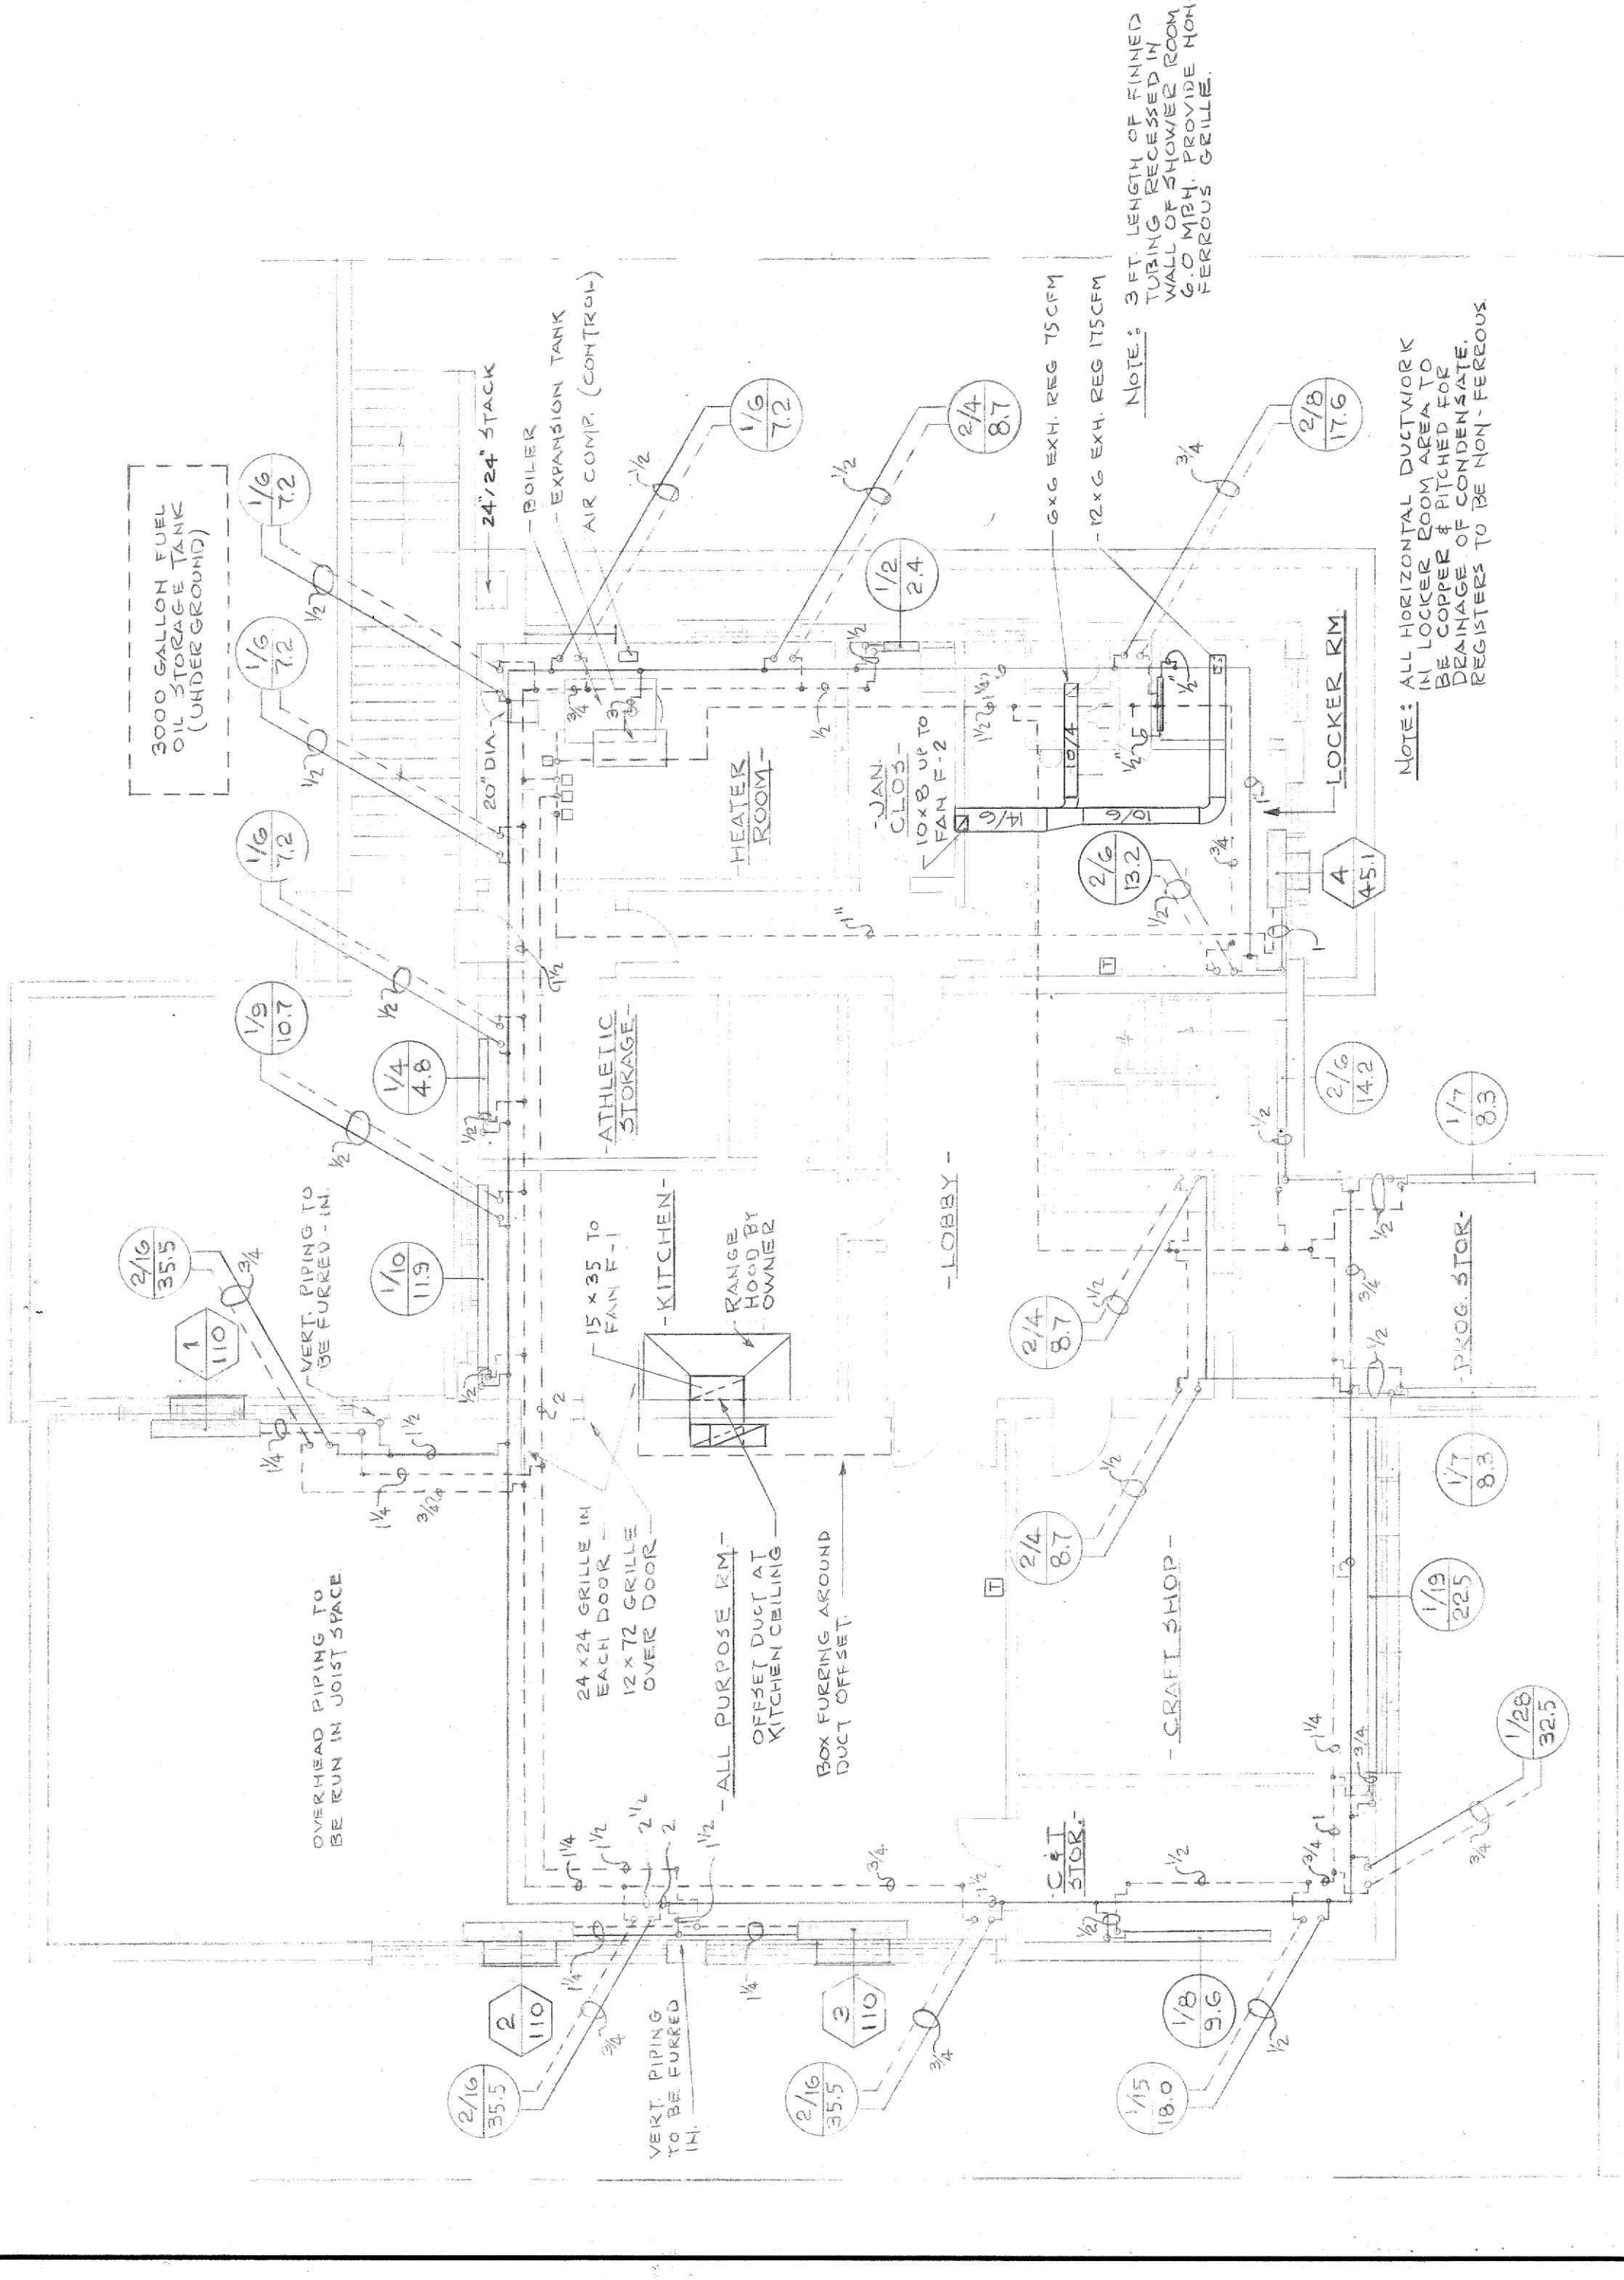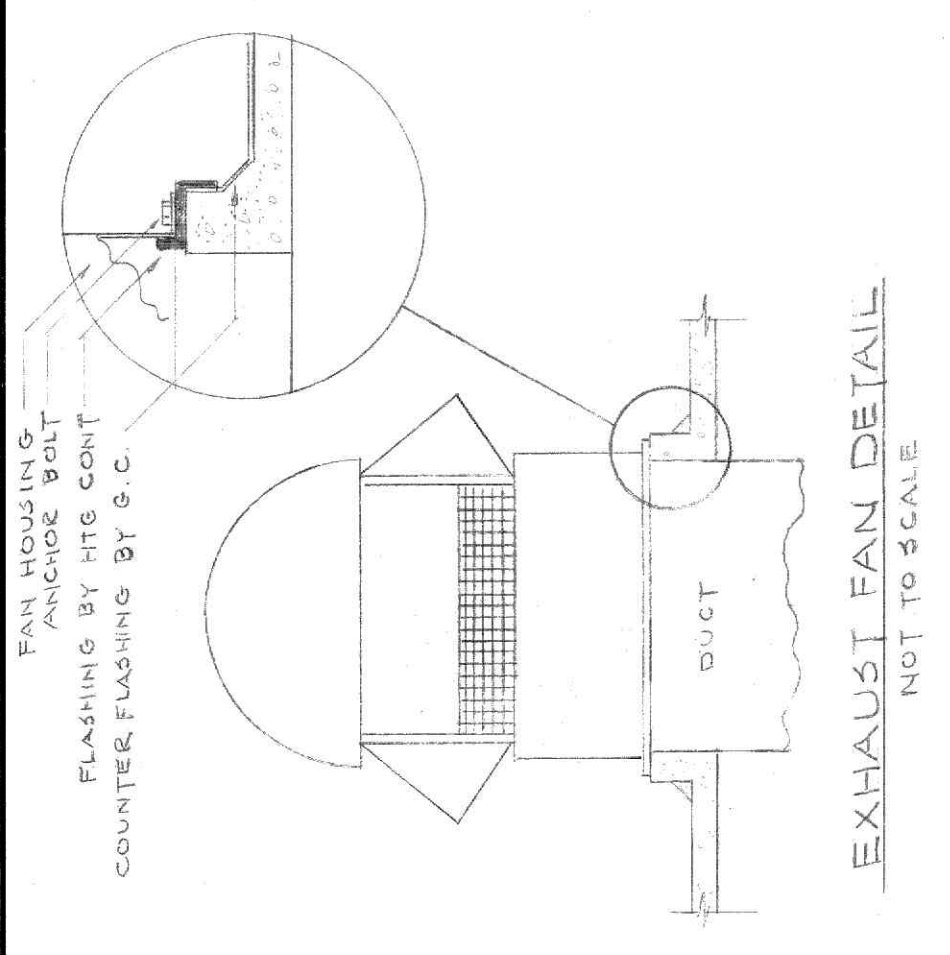

GROUND FLOOR SCALE 1/8"=1'-0"

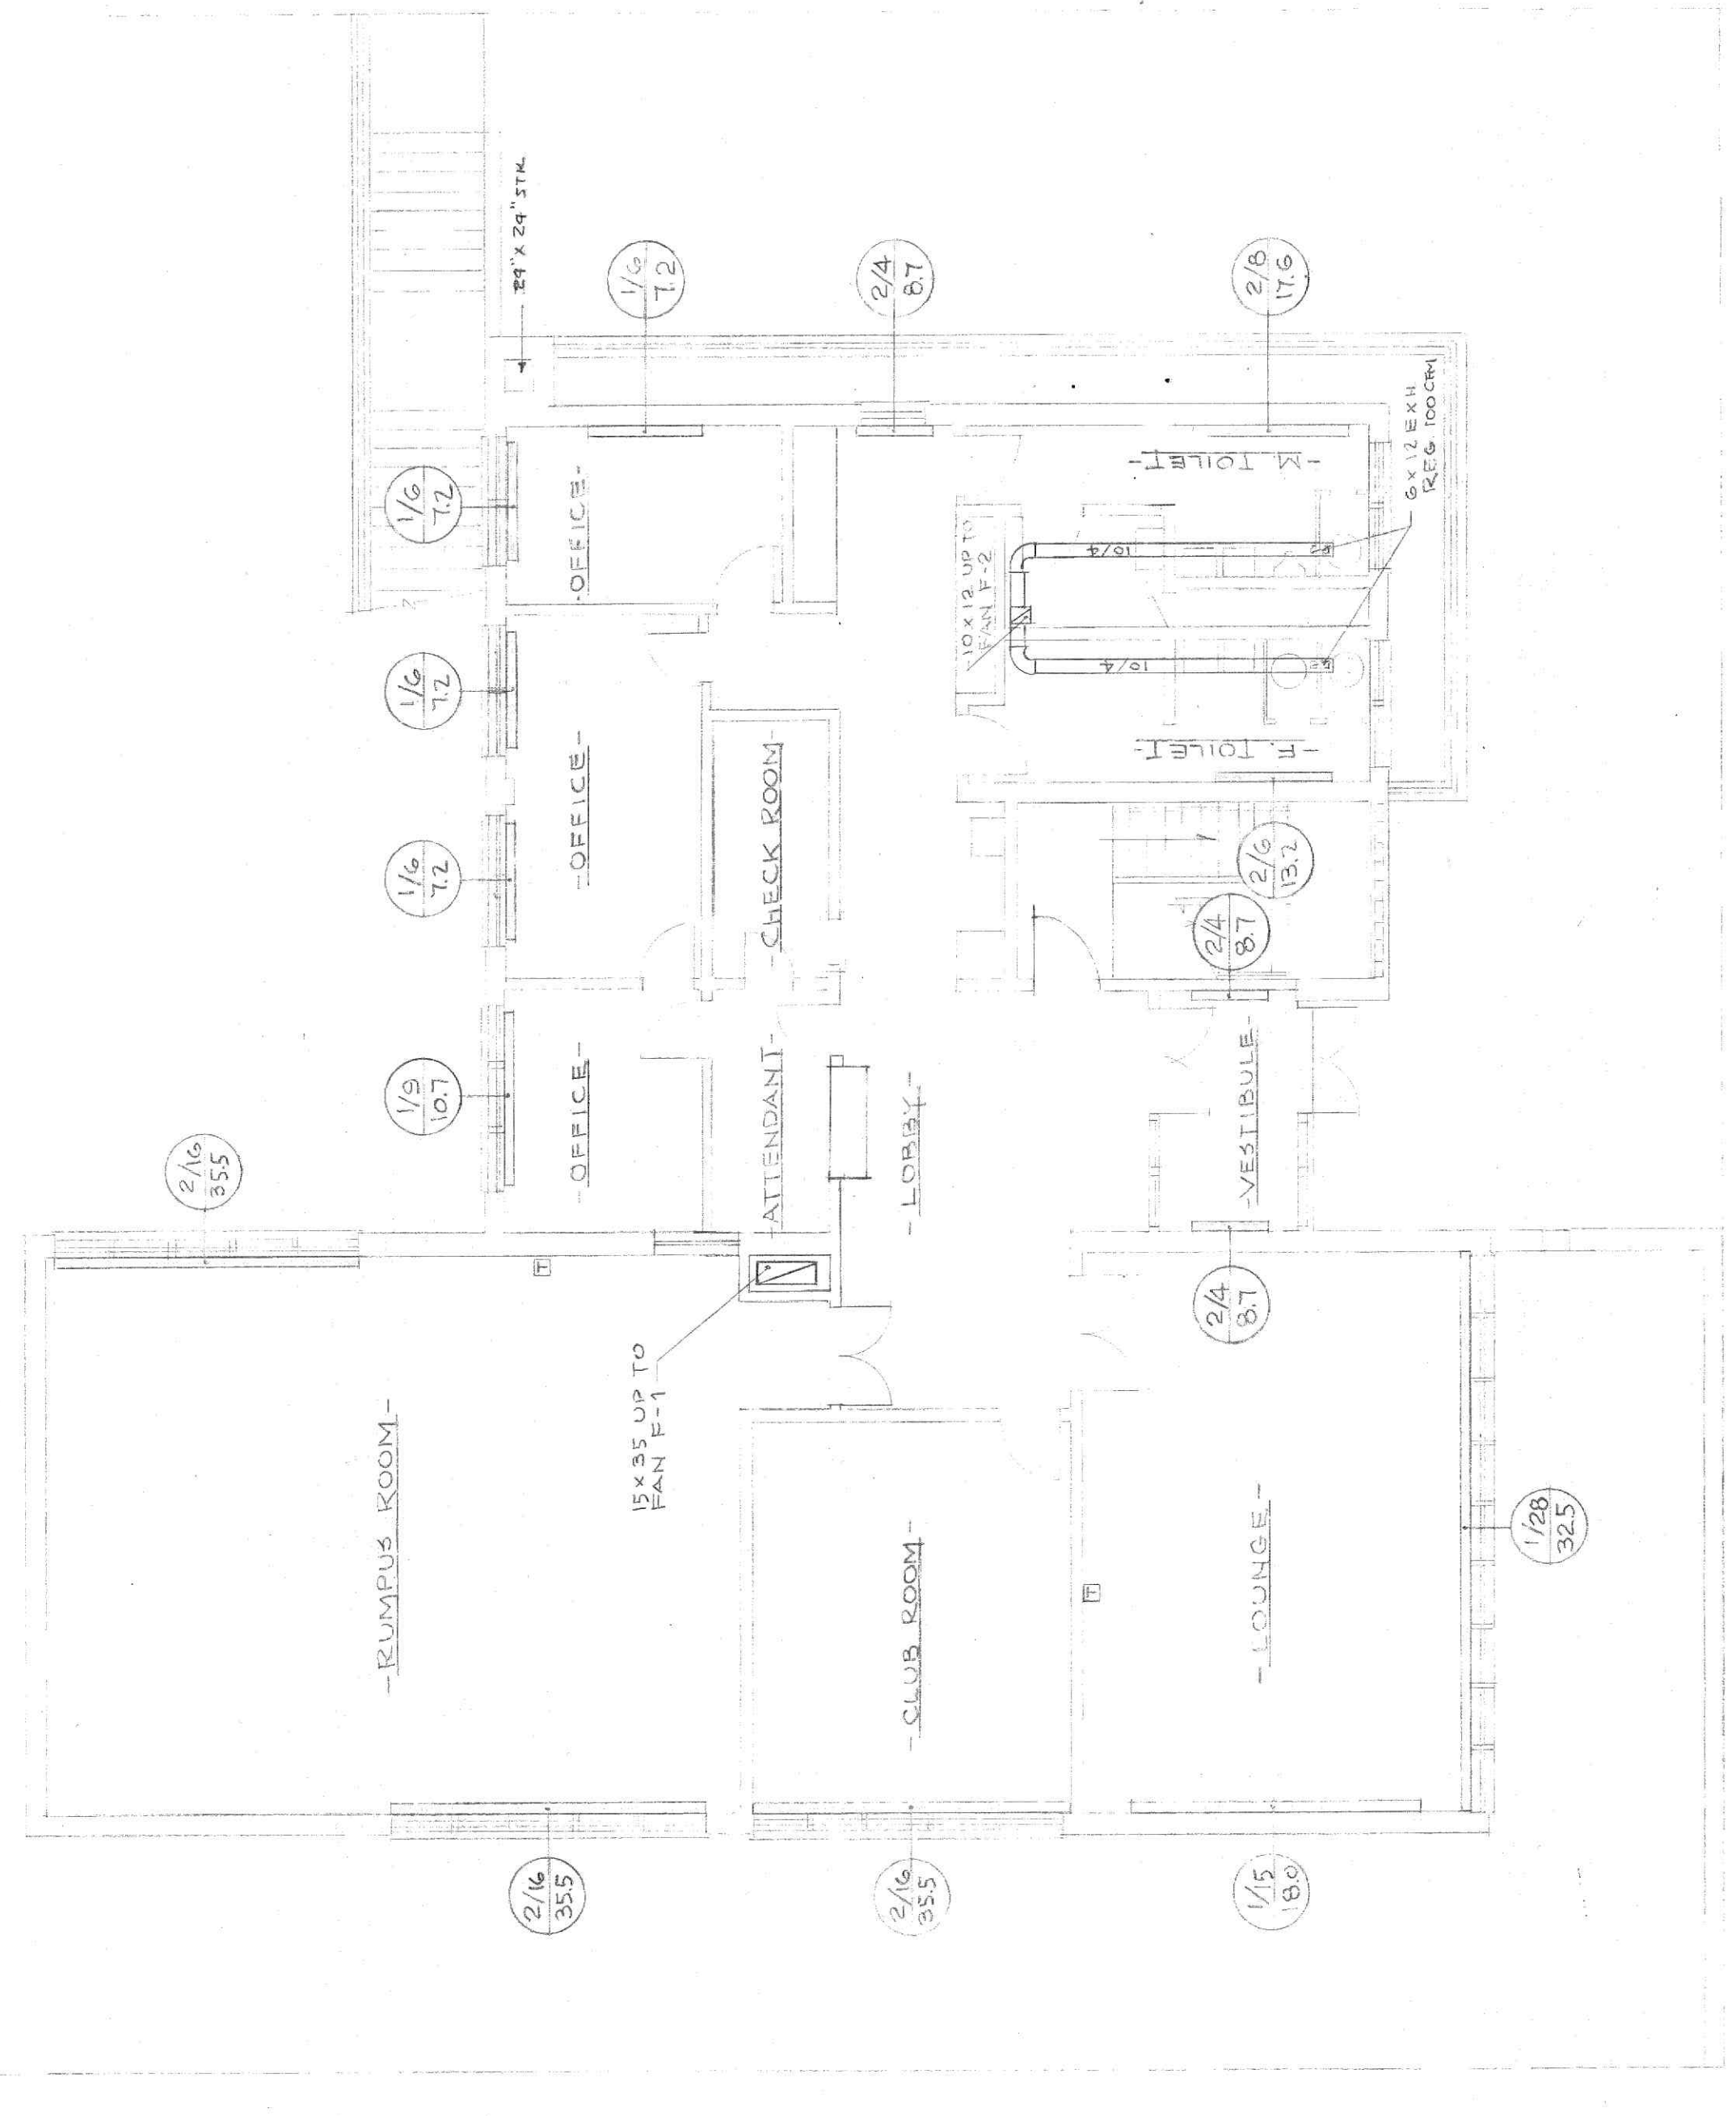

FIRST FLOOR SCALE 1/8"=1'-0"

**WATSON & HART**  
ENGINEERS  
GREENSBORO, NORTH CAROLINA  
COMM. NO. 588


**HUNTON BRANCH Y.M.C.A.**  
LYNCHBURG, VIRGINIA  
FOR YOUNG MEN'S CHRISTIAN ASSOCIATION  
LYNCHBURG, VIRGINIA

**PENLETON S. CLARK, ARCHITECT**  
LYNCHBURG, VIRGINIA






HEATING & VENTILATING  
HV-1

NO. OF BOYS 20  
NO. OF MEN 10  
NO. OF WOMEN 10  
NO. OF CHILDREN 10  
NO. OF TOTAL 50

DATE 2/22/22  
DRAWN BY K. STONE  
CHECKED BY W. K. STONE  
AUG 1924 AS NOTED IN N.W. CASE.


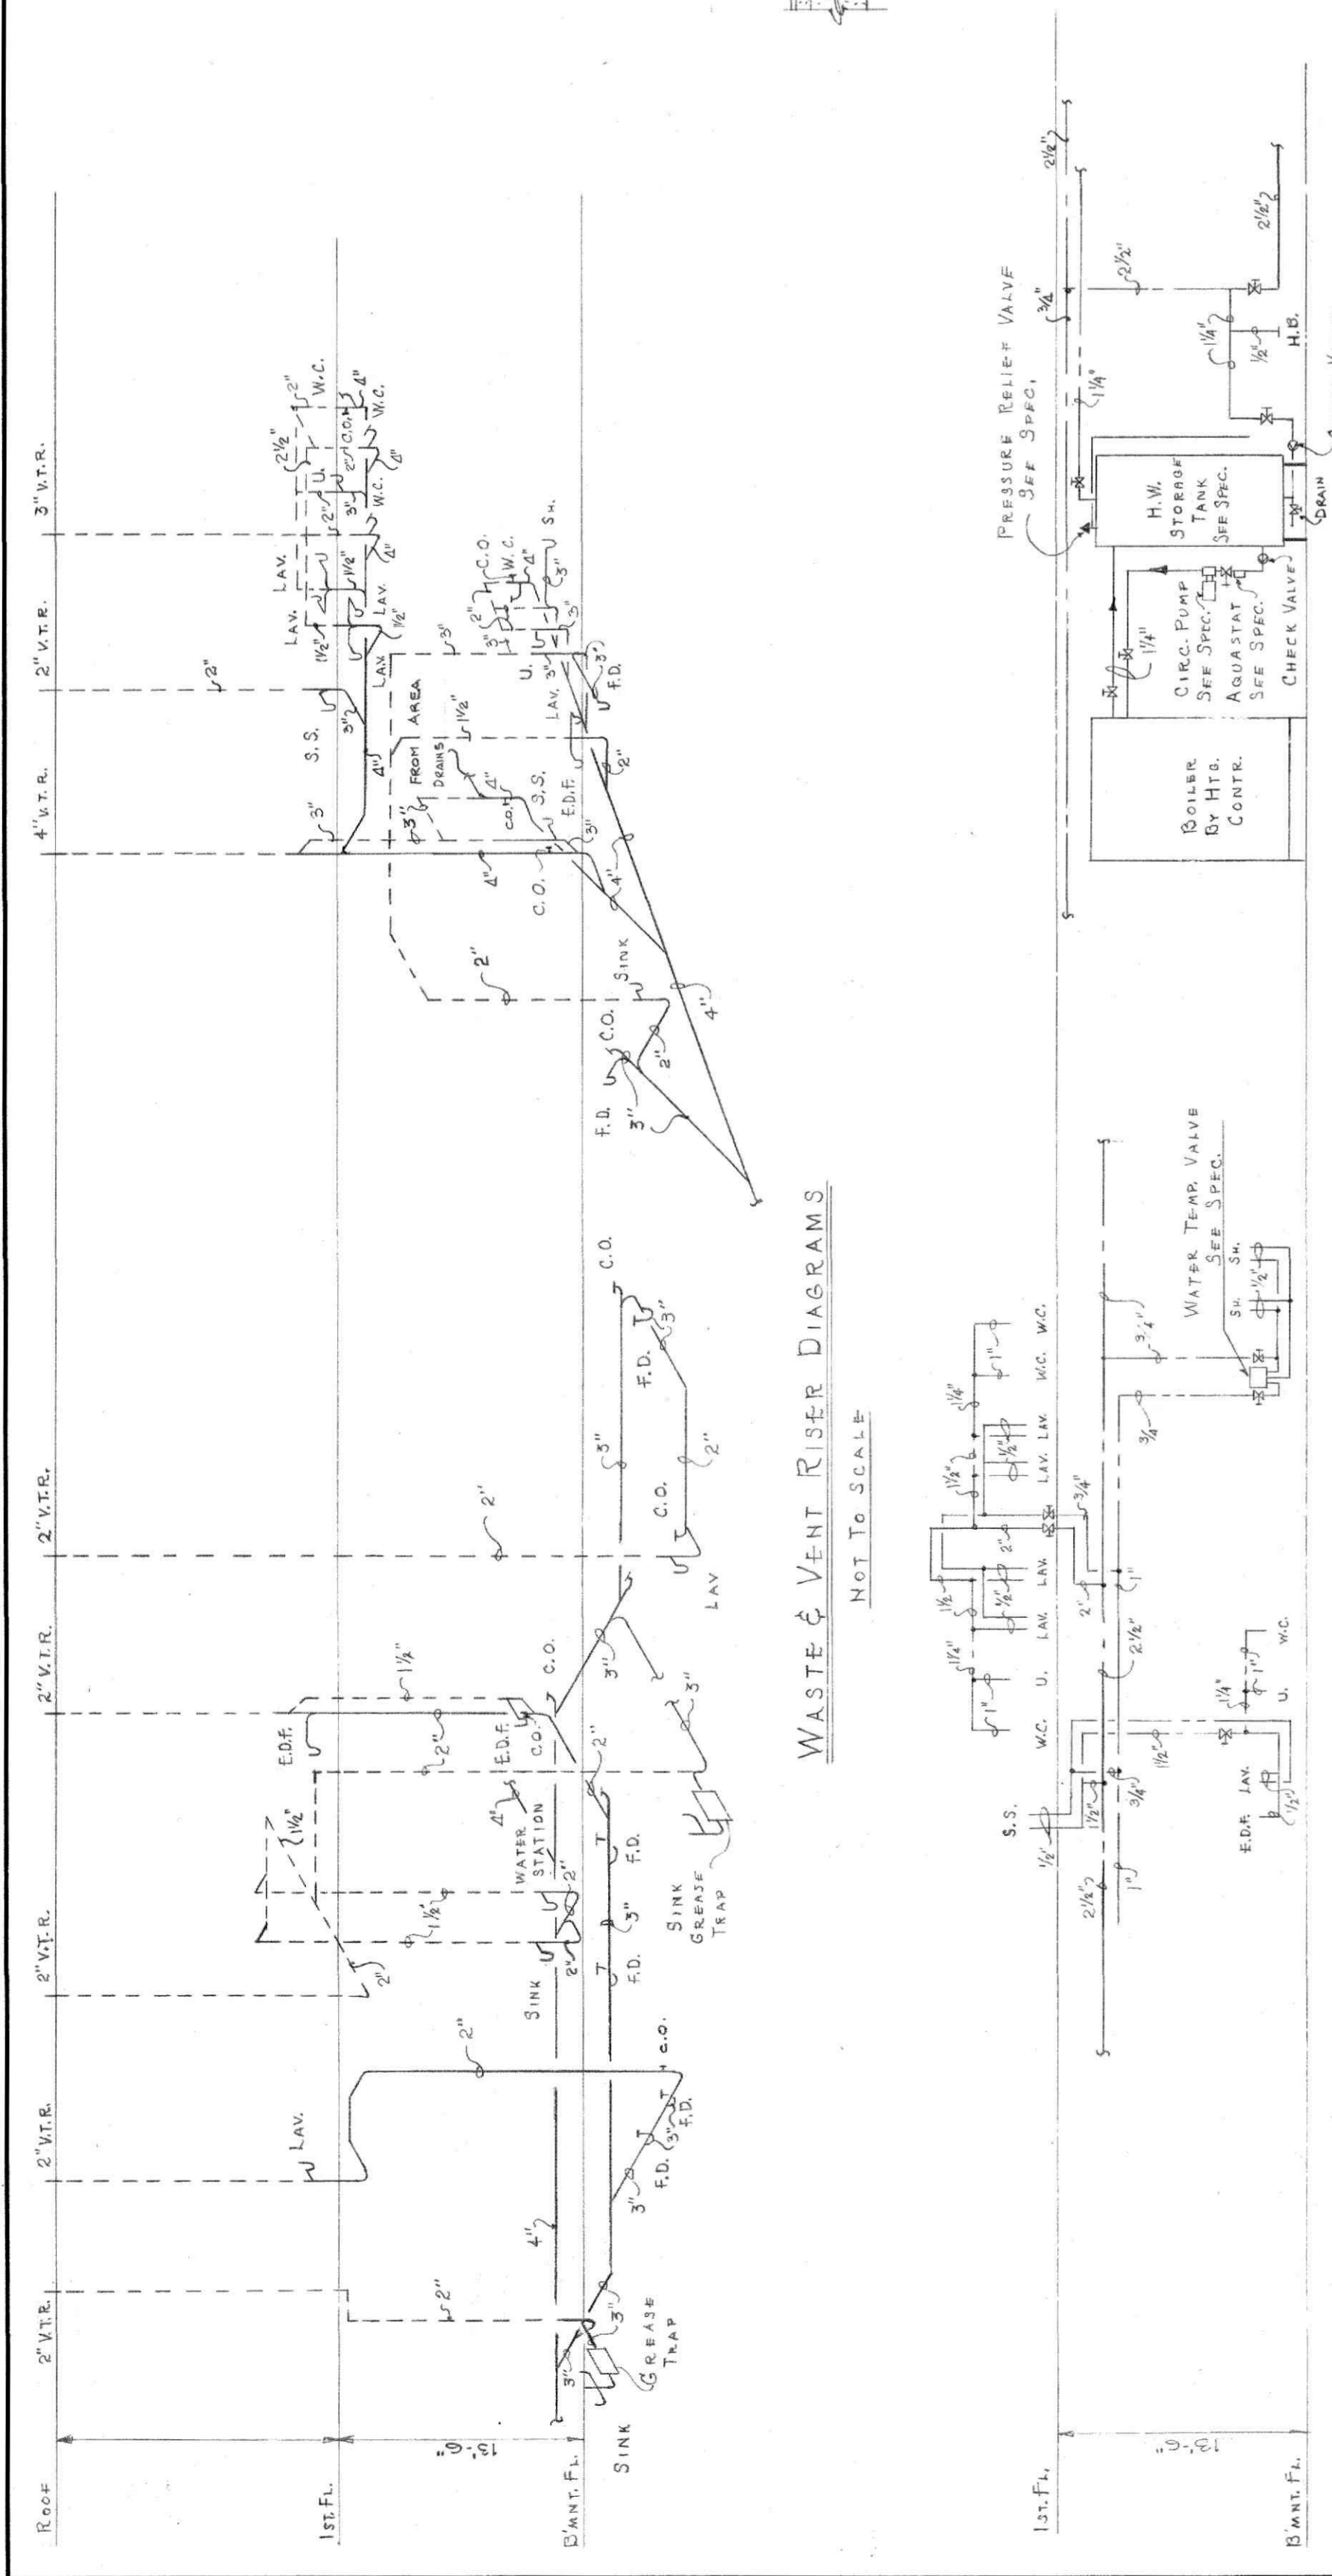


**WATER RISER DIAGRAMS**  
NOT TO SCALE

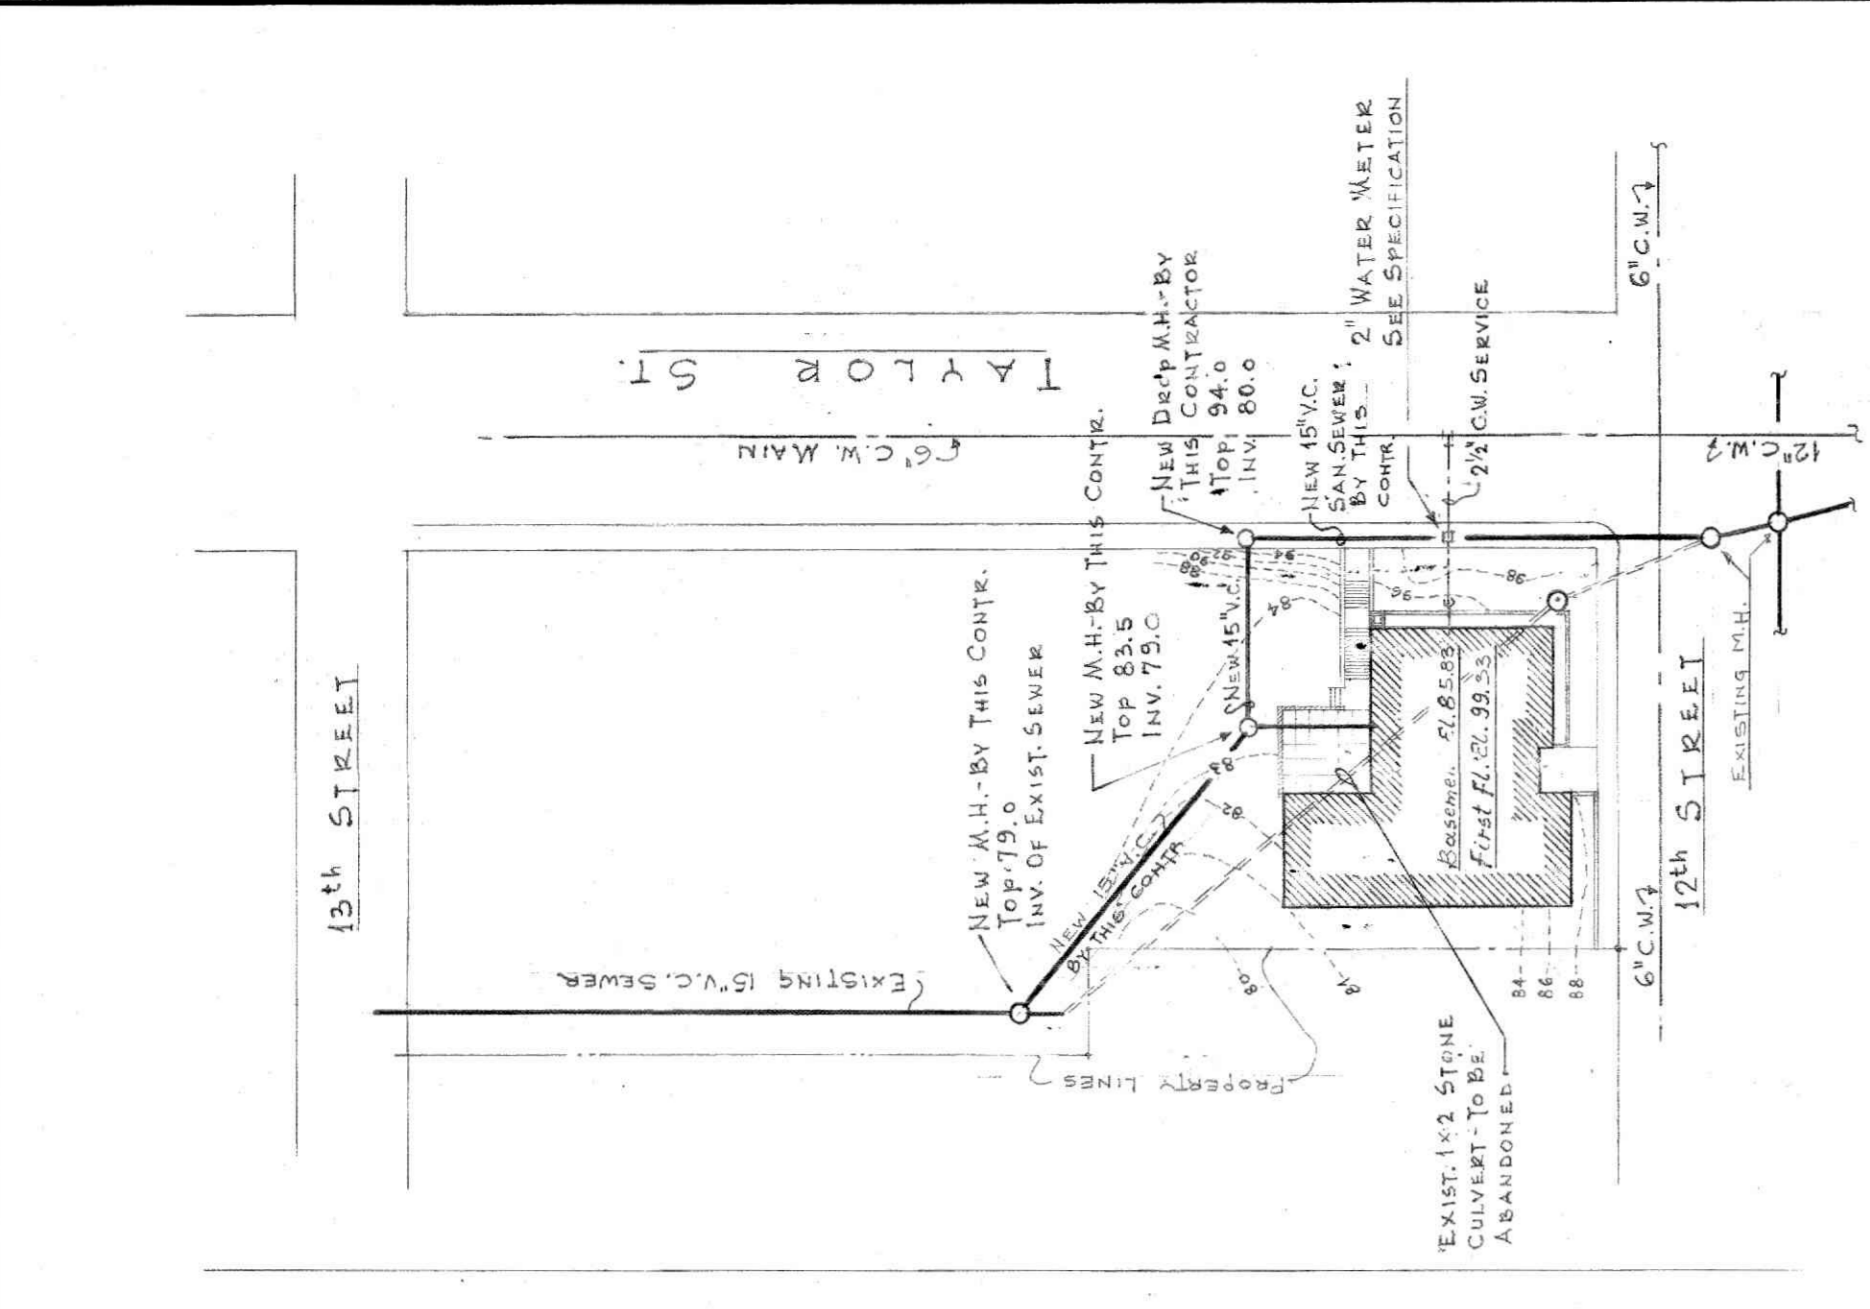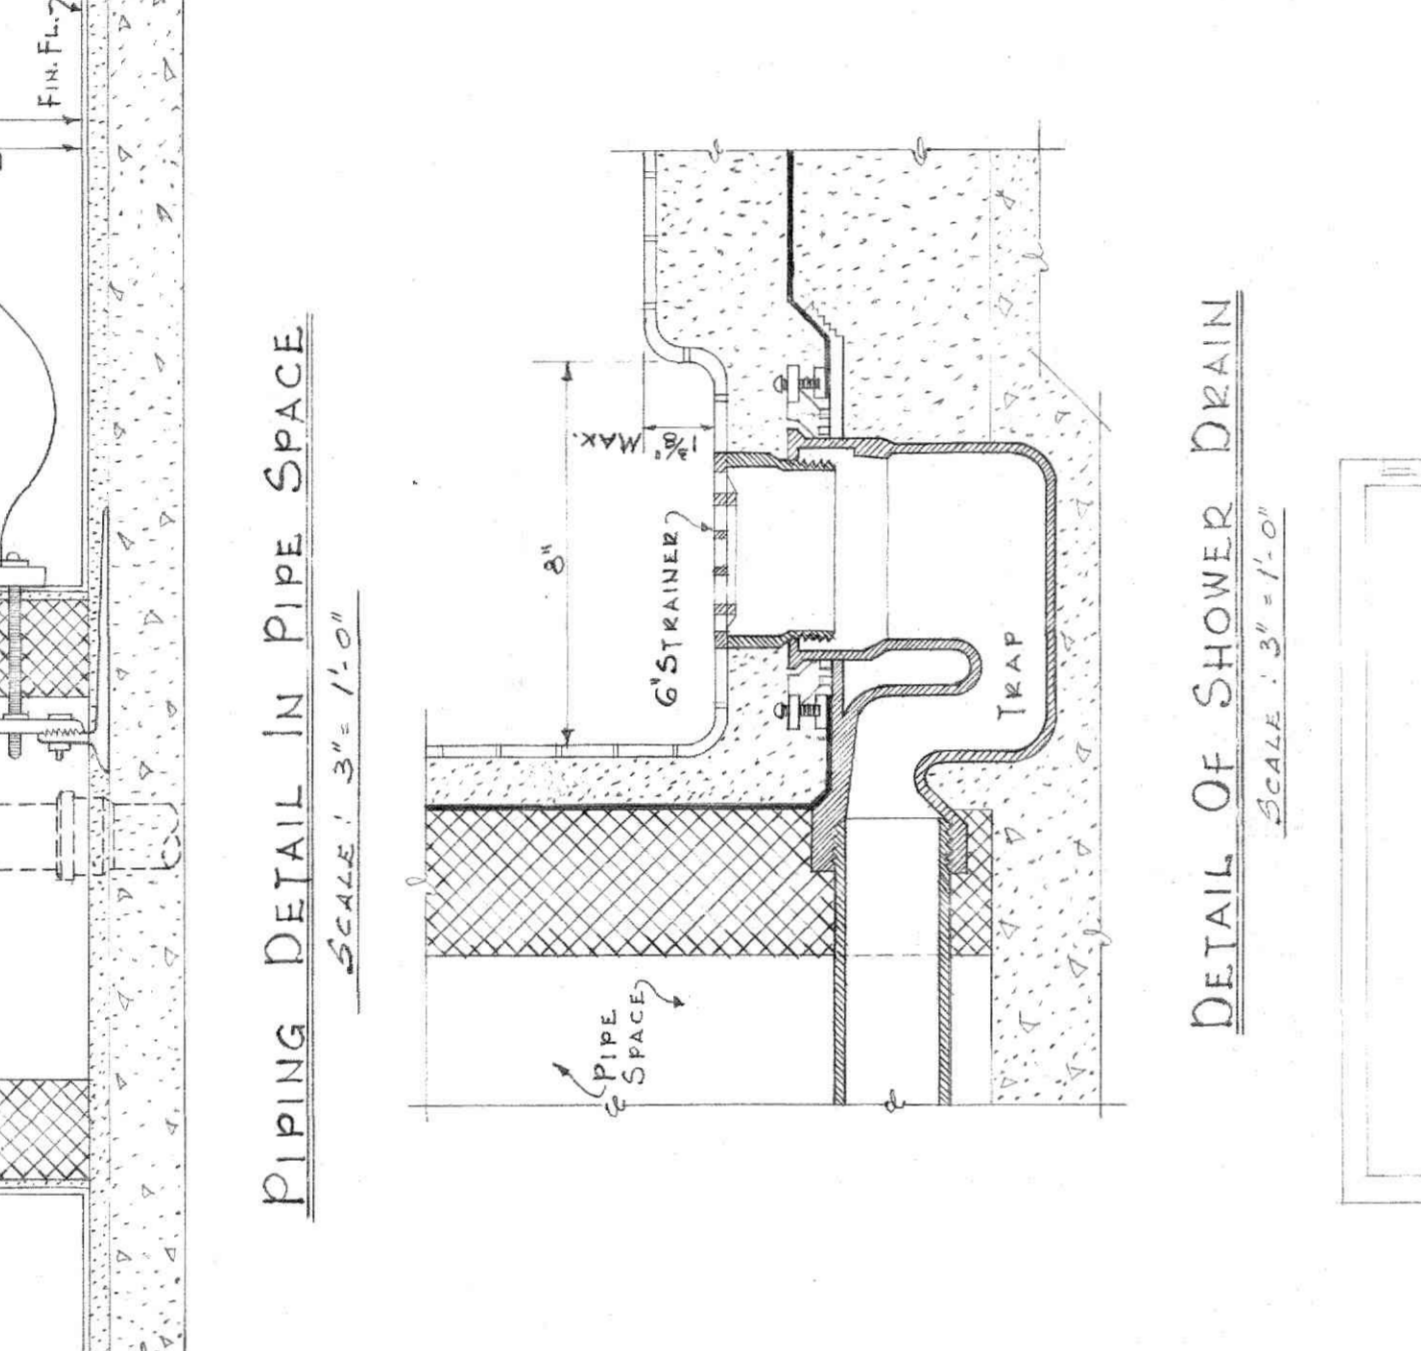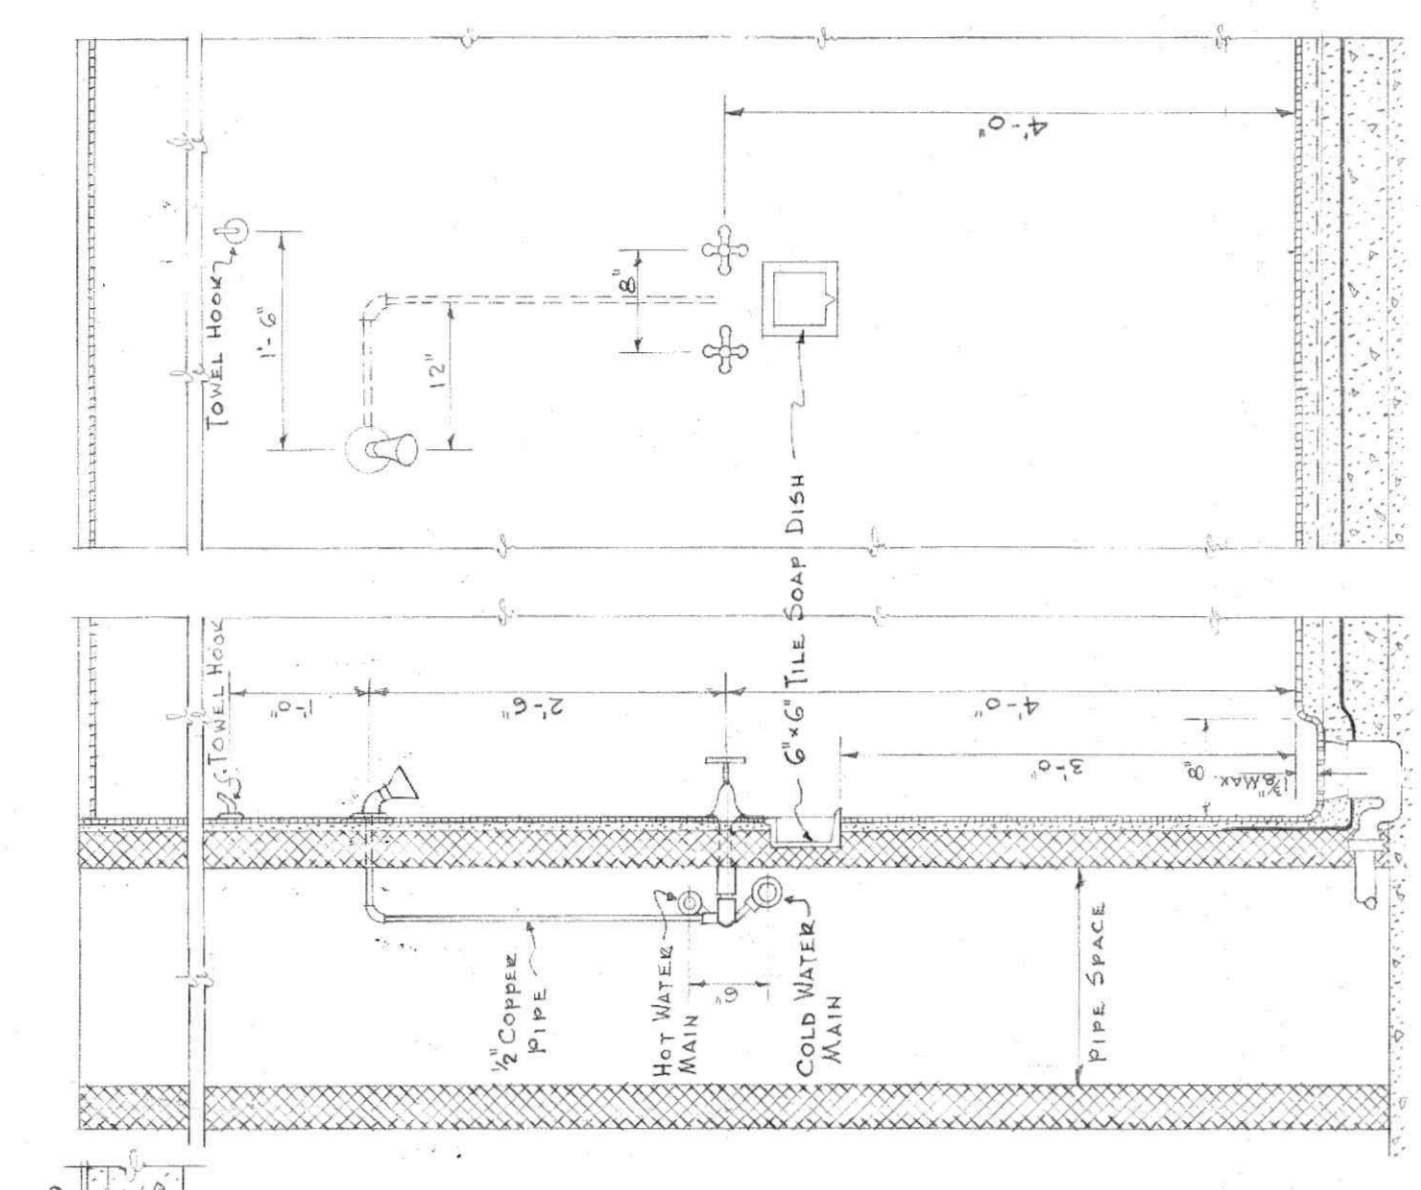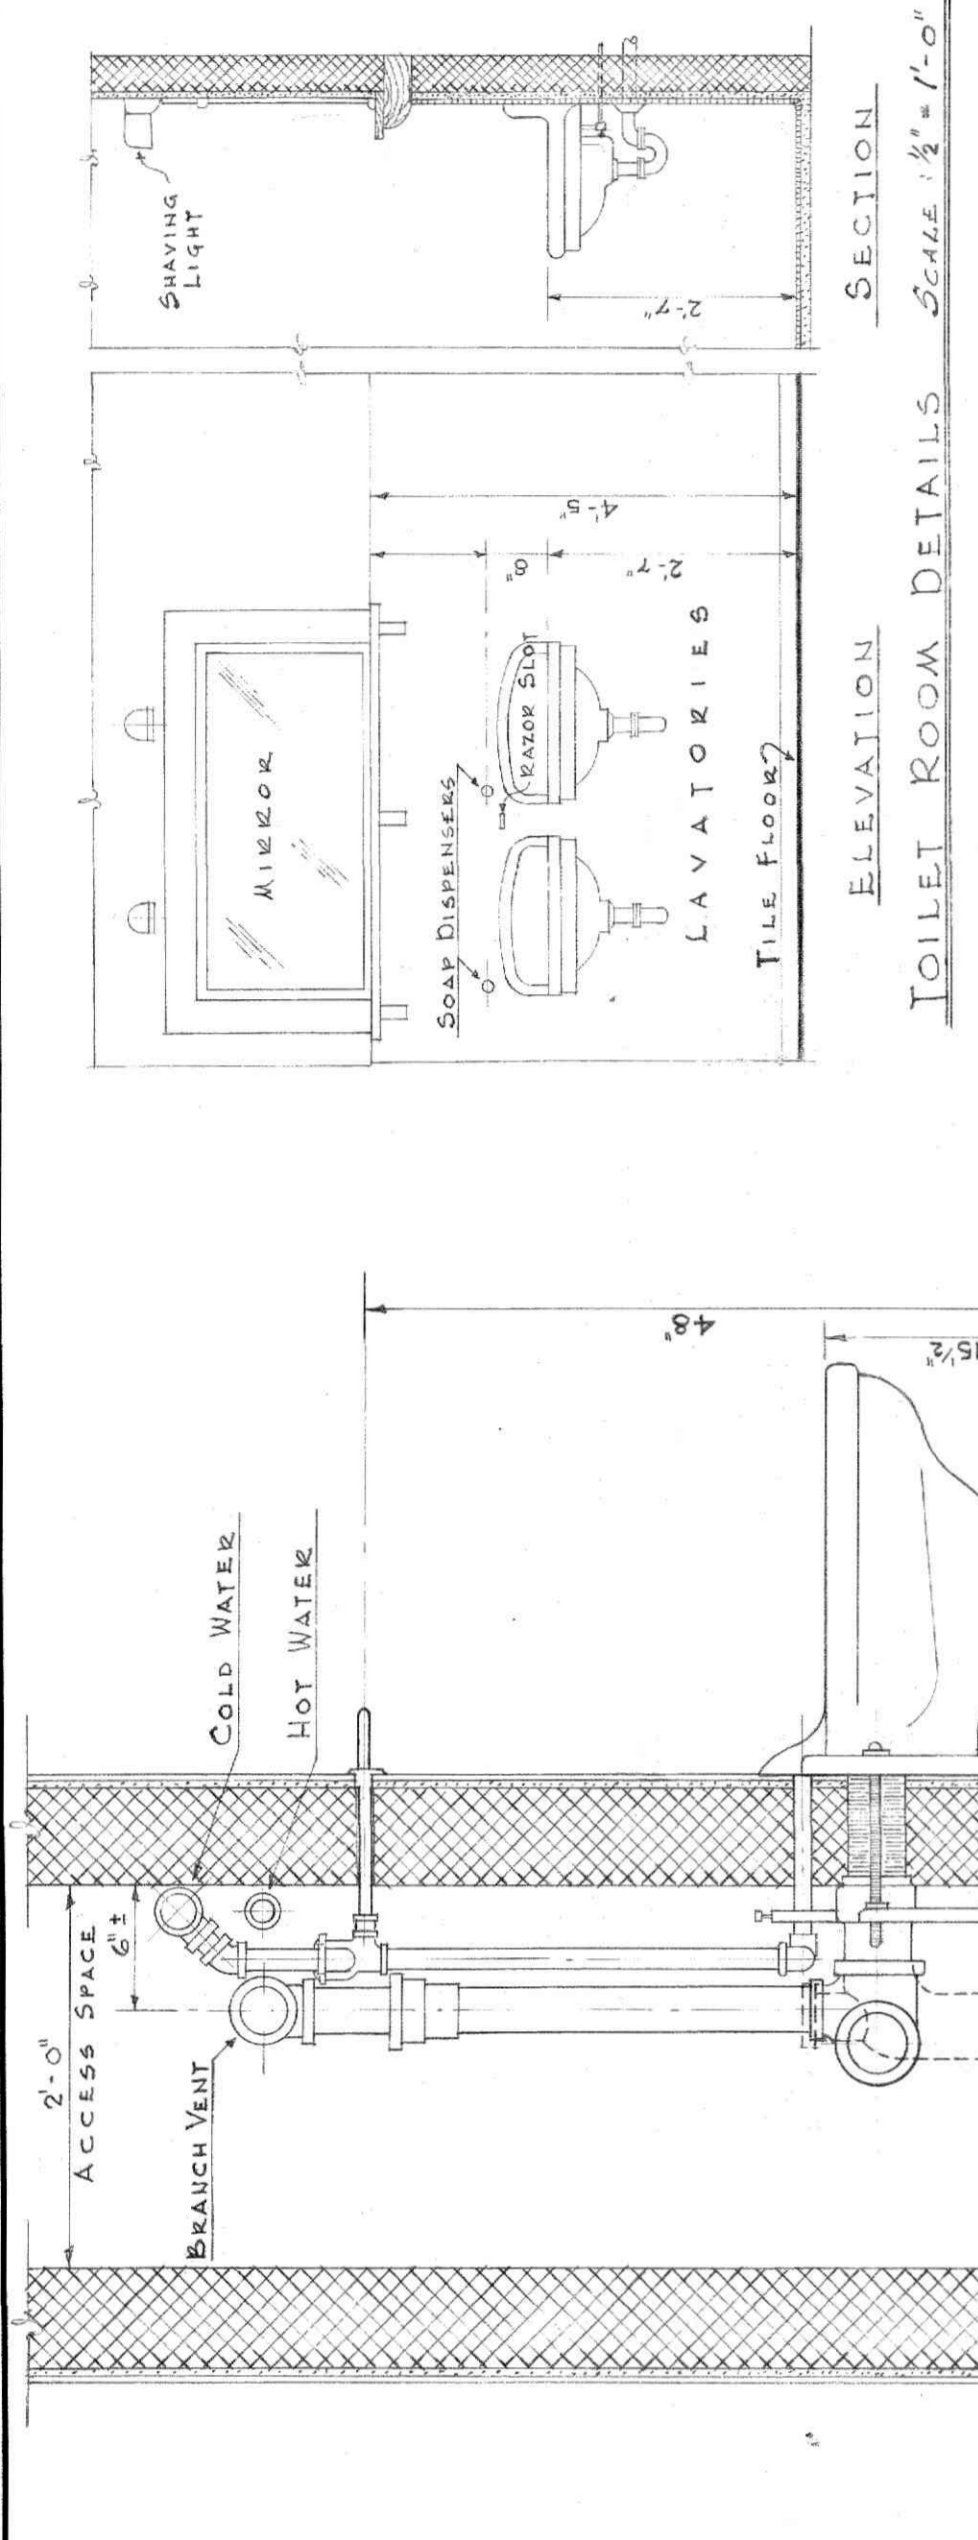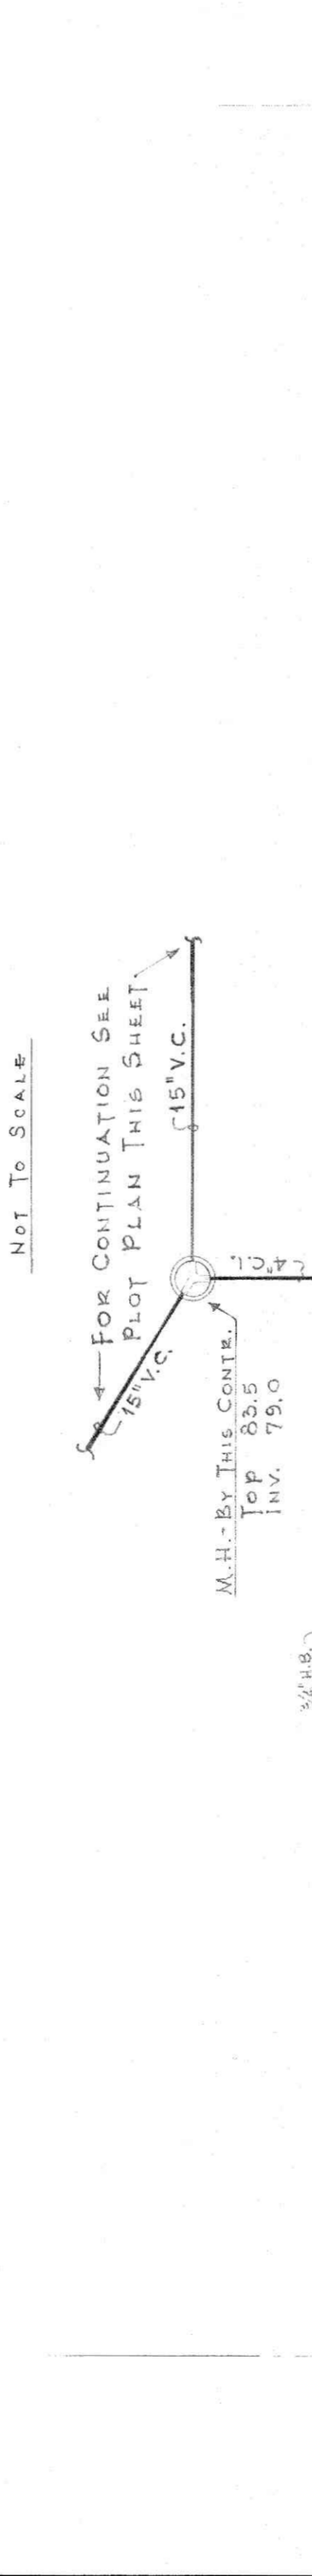

**PLUMBING ABBREVIATIONS & SYMBOLS**

W.C.	WATER CLOSET
U.	URINAL
LAV.	LAVATORY
M.H.	MANHOLE
S.S.	SERVICE SINK
S.H.	SHOWER
E.D.F.	ELECTRIC DRINKING FOUNTAIN
F.D.	FLOOR DRAIN
A.D.	AREA DRAIN
H.B.	HOSE BIBB
V.C.	VITRIFIED CLAY PIPE
C.I.	CAST IRON
C.O.	CLEANOUT
V.T.R.	VENT THRU ROOF
C.W.	COLD WATER
H.W.	HOT WATER
G.V.	GATE VALVE
C.V.	GLOBE VALVE
C.C.V.	CHECK VALVE
W.S.	WASTE SANITARY
V.S.	VENT SANITARY

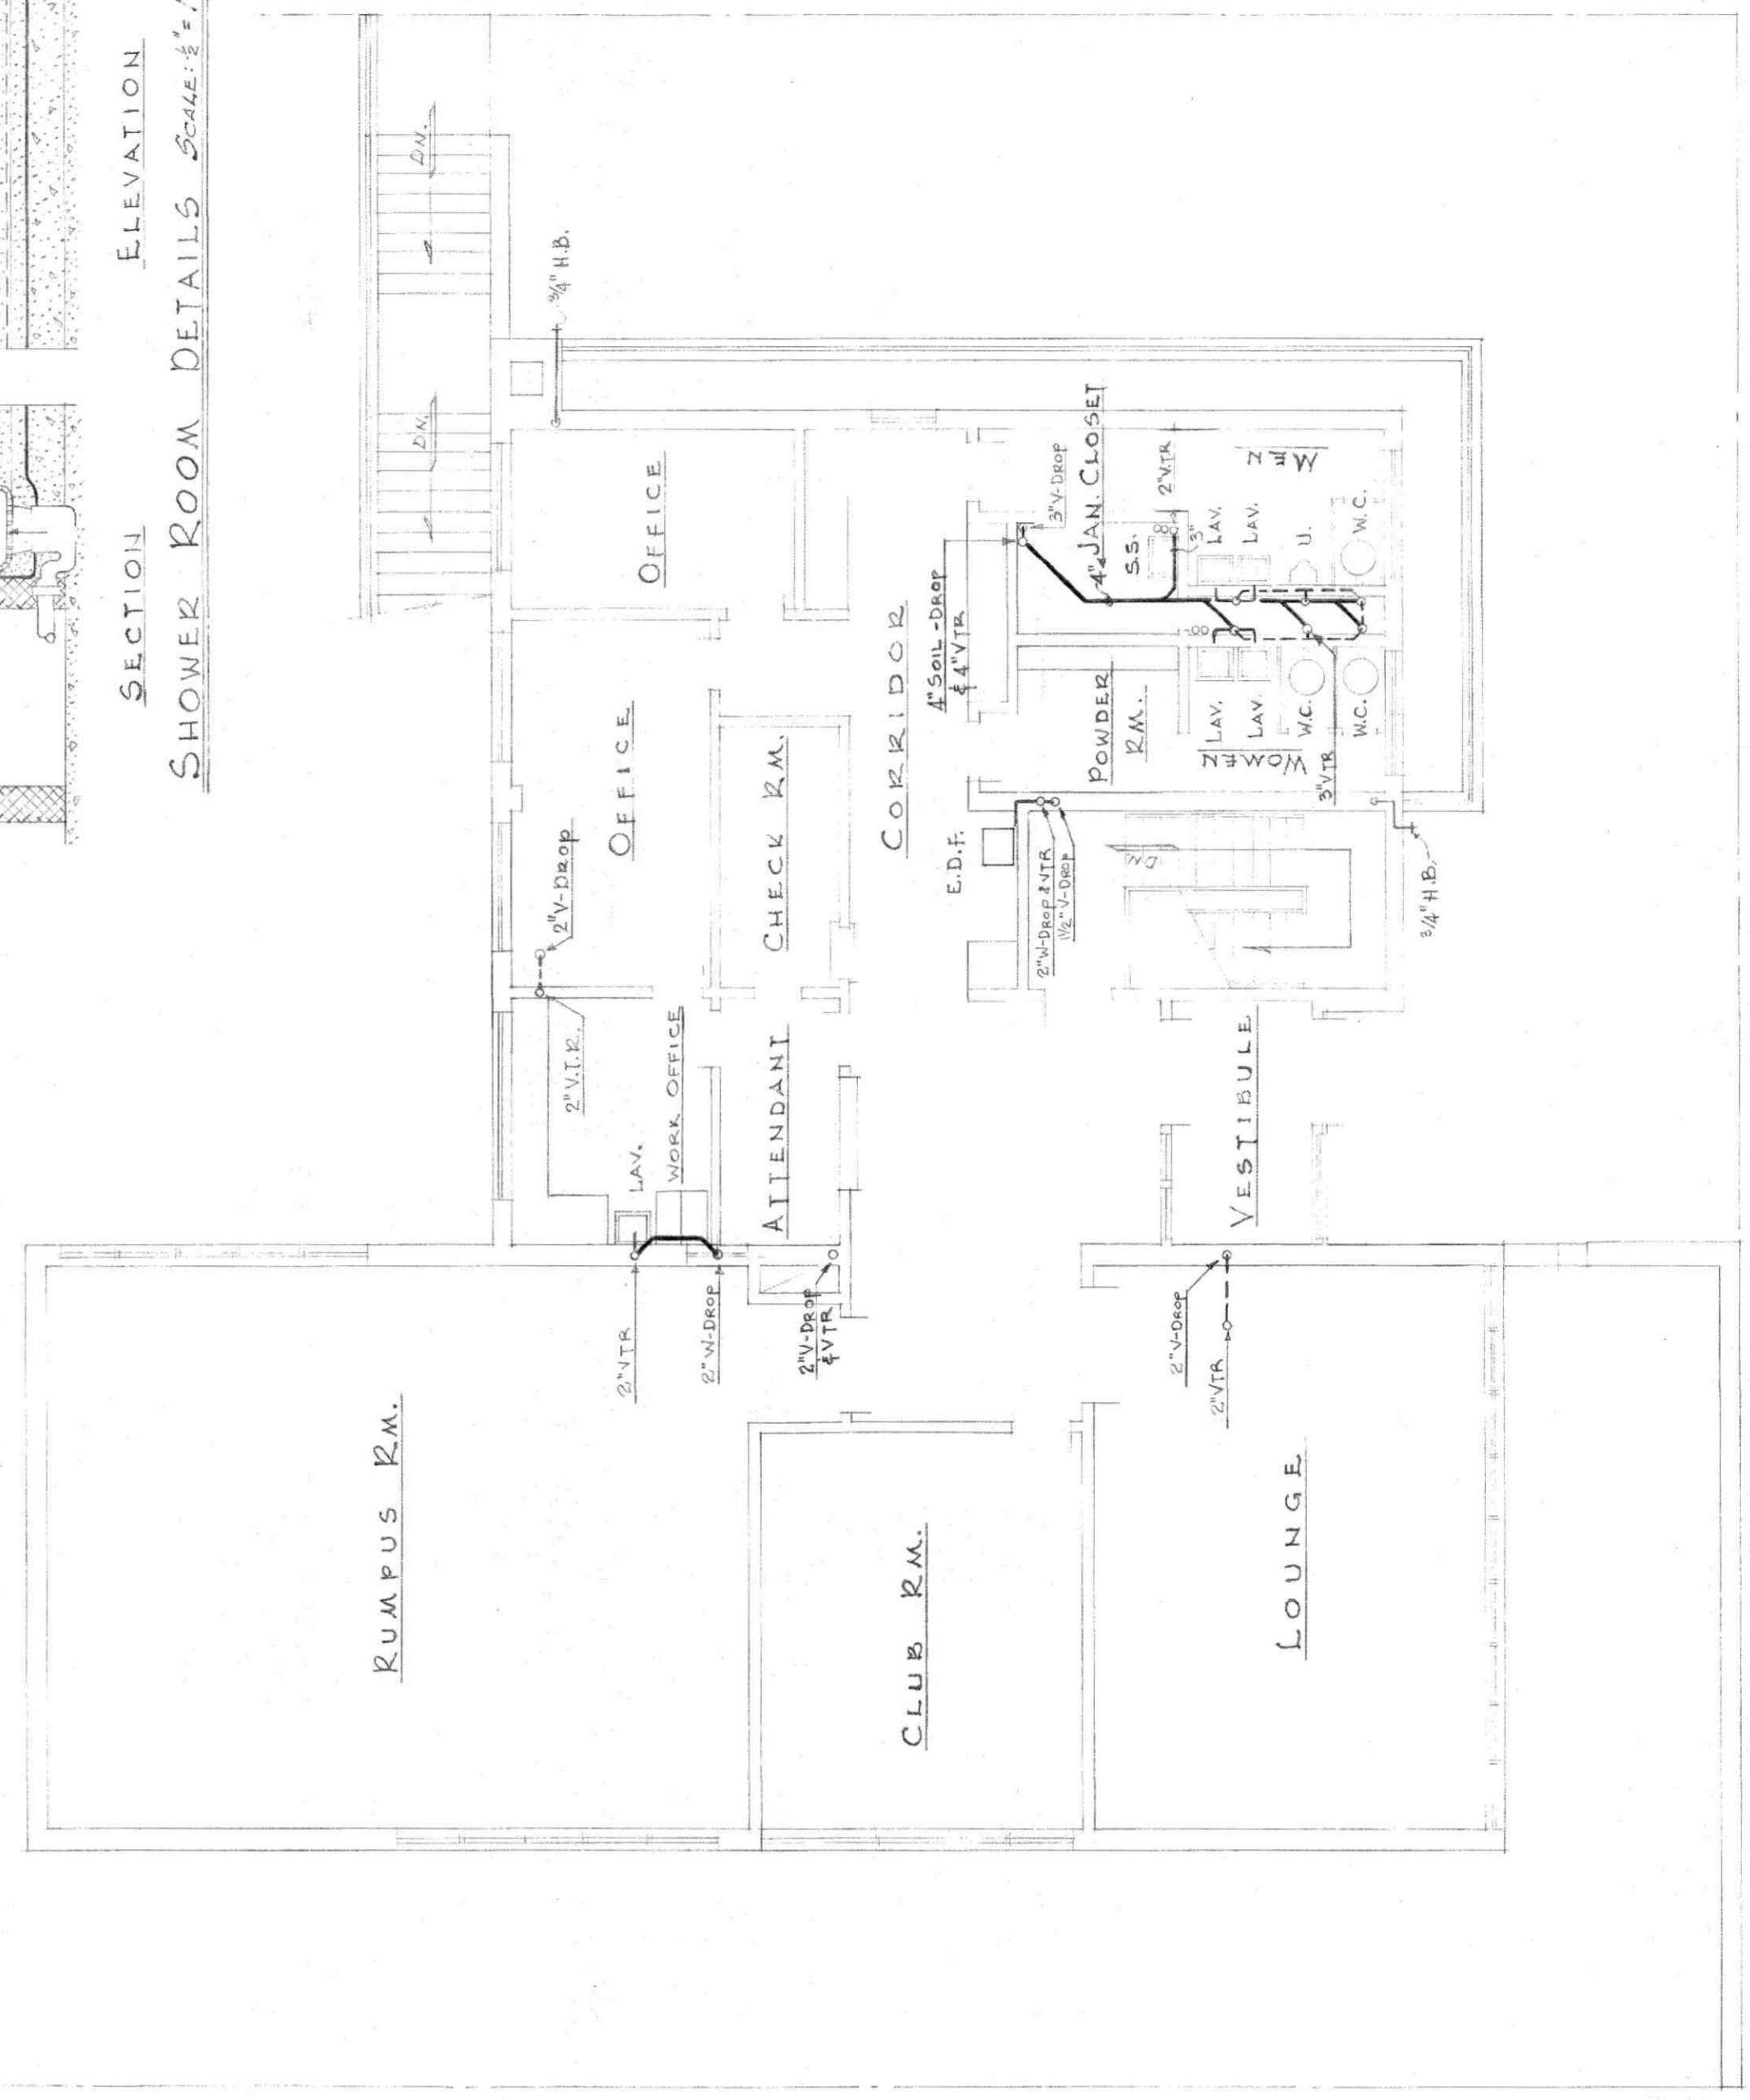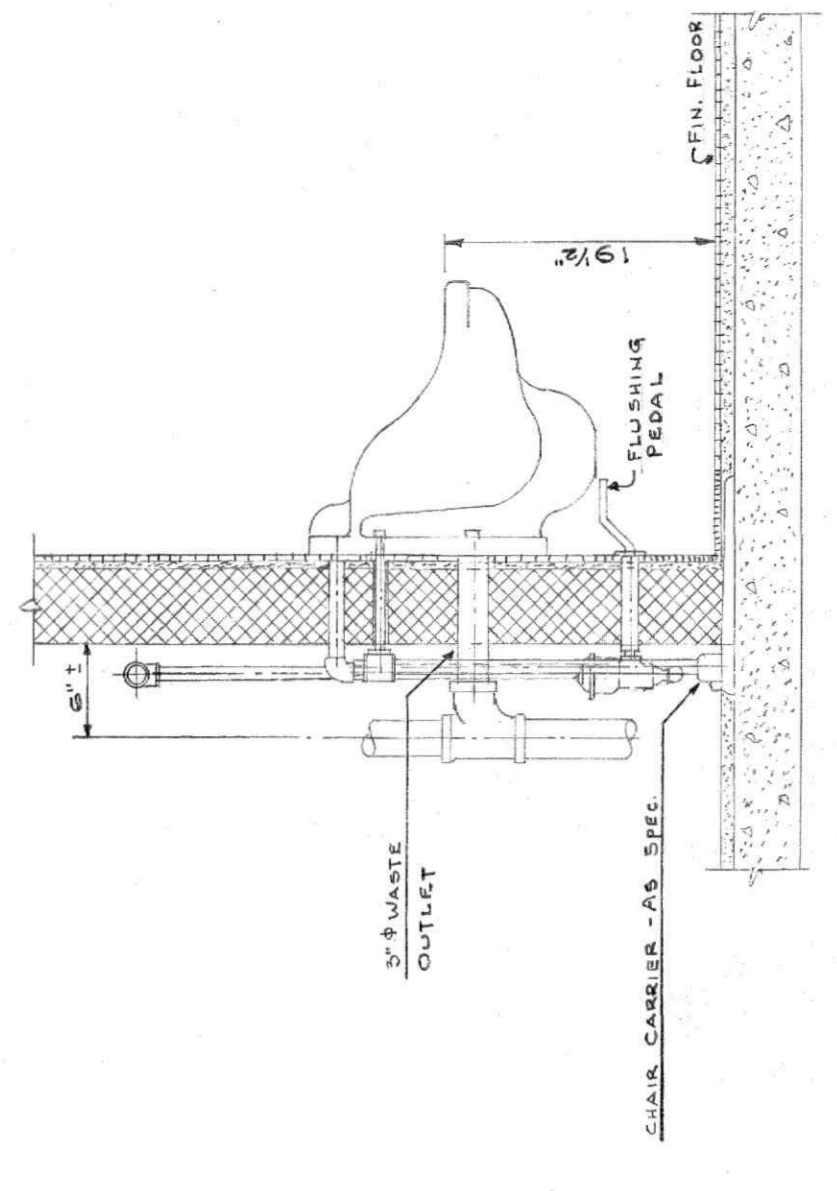

**FIRST FLOOR PLAN**  
Scale: 1/8" = 1'-0"

**URINAL INSTALLATION DETAIL**  
Not To Scale

**GENERAL NOTES**

1. IN GENERAL, WATER & VENT PIPING IS SHOWN OVERHEAD, UNLESS OTHERWISE NOTED.
2. IN GENERAL, SOIL & WASTE PIPING IS TO BE RUN UNDER RESPECTIVE FLOOR SLABS.
3. FLUSHMETERS SHALL NOT BE ON SHOWER PLUMBING LINES.

**GROUND FLOOR PLAN**  
Scale: 1/8" = 1'-0"

**WATSON & HART**  
ENGINEERS  
GREENSBORO, NORTH CAROLINA  
COMM. NO. 588

**HUNTON BRANCH Y.M.C.A.**  
LYNCHBURG, VIRGINIA  
FOR YOUNG MEN'S CHRISTIAN ASSOCIATION  
LYNCHBURG, VIRGINIA

**PENLETON S. CLARK, ARCHITECT**  
LYNCHBURG, VIRGINIA

**PLUMBING**  
DRAWING NO. 2287225  
CHECKED BY B.S.J.S.  
AUG. 1954 AS NOTED B.S.J.S.  
B.S.

**P-1**