



**SECOND FLOOR PLAN**  
SCALE: 1/4" = 1'-0"

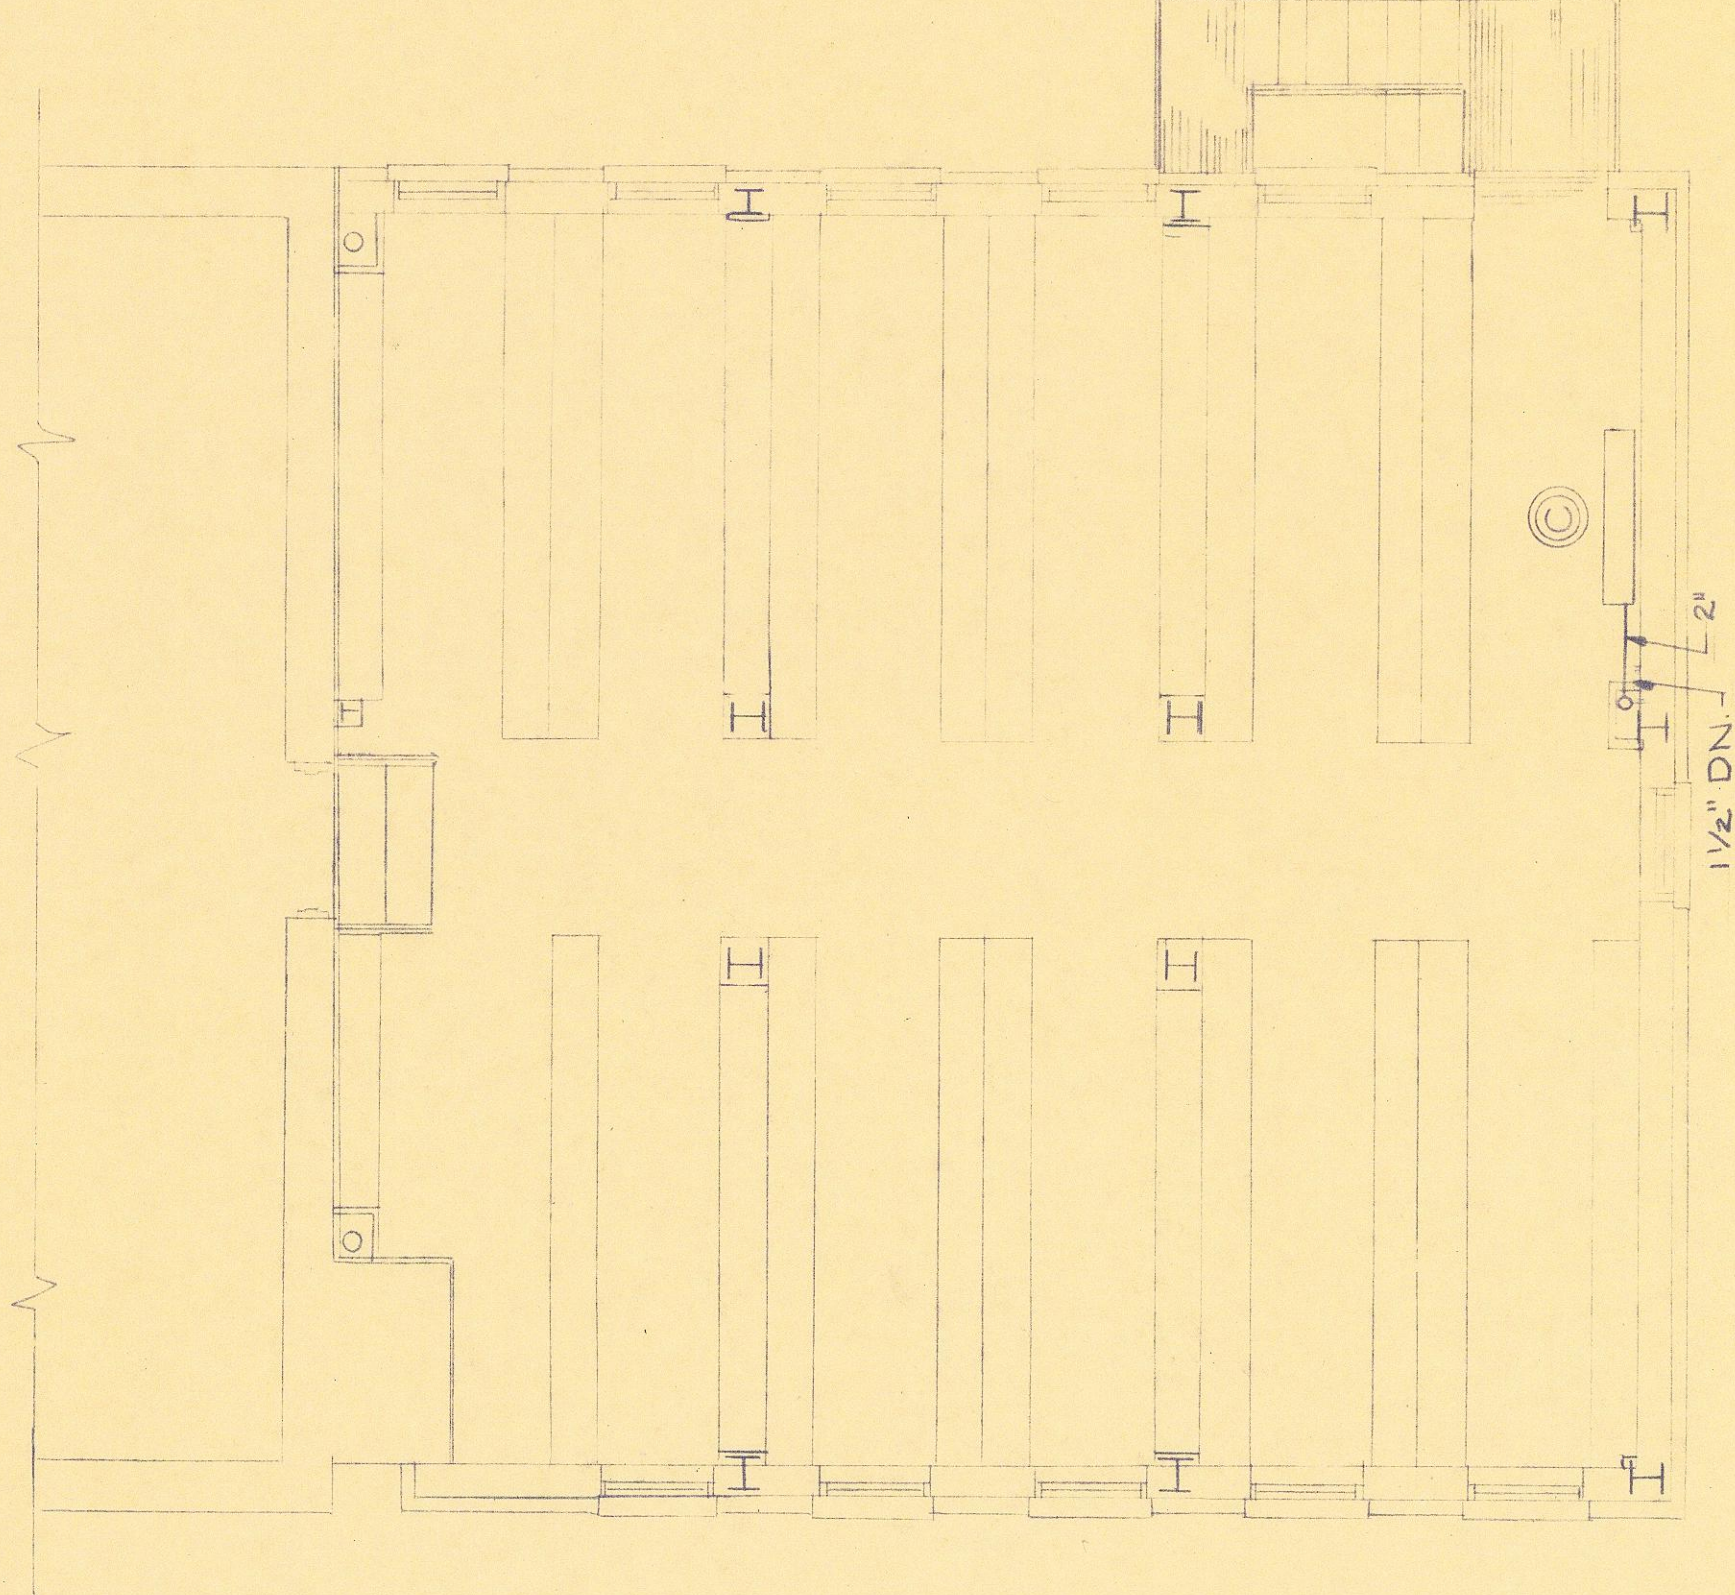

**THIRD FLOOR PLAN**  
SCALE: 1/4" = 1'-0"

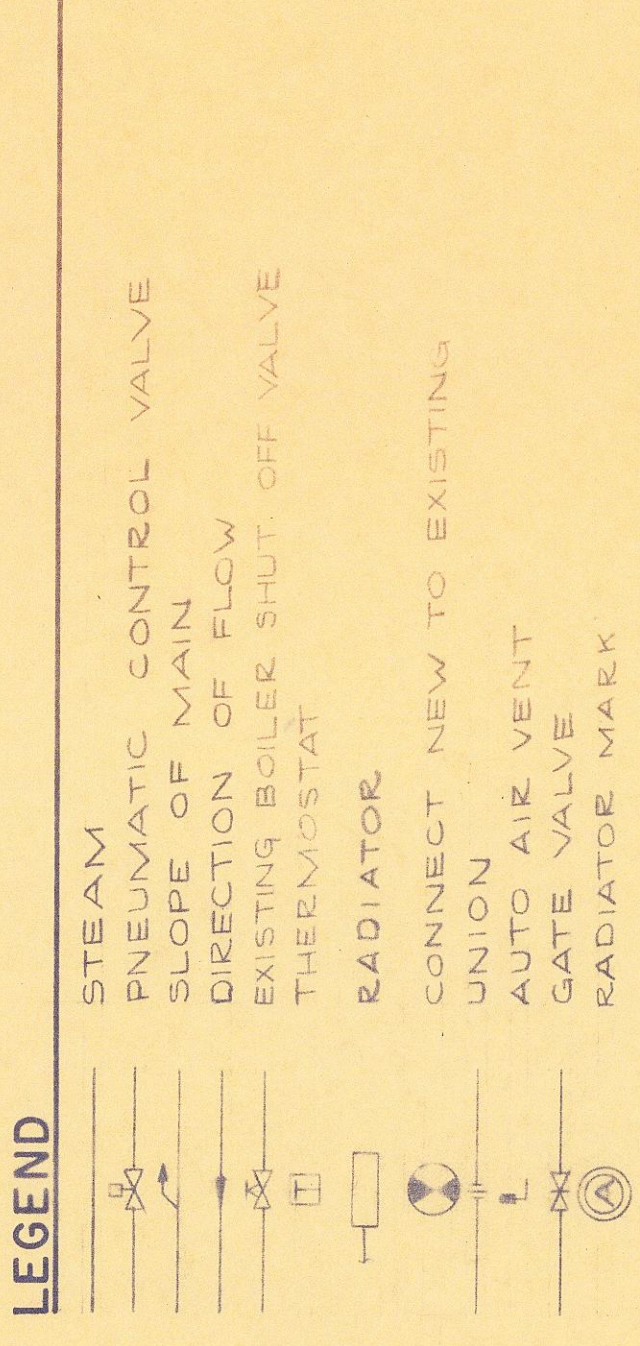


**NOTES**


1. PITCH OF MAINS SHALL NOT BE LESS THAN 1/4" IN 10 FT.

2. PITCH OF HORIZONTAL RADIATORS TO BE KEPT AS NOTED AND RADIATORS SHOULD NOT BE LESS THAN 1/2" PER FOOT.


RADIATOR SCHEDULE		
MARK	NO. OF SECTIONS	NO. OF TUBES SO. FT. RADIATION
A	2.8	103.6
B	2.4	88.8
C	3.0	111.0

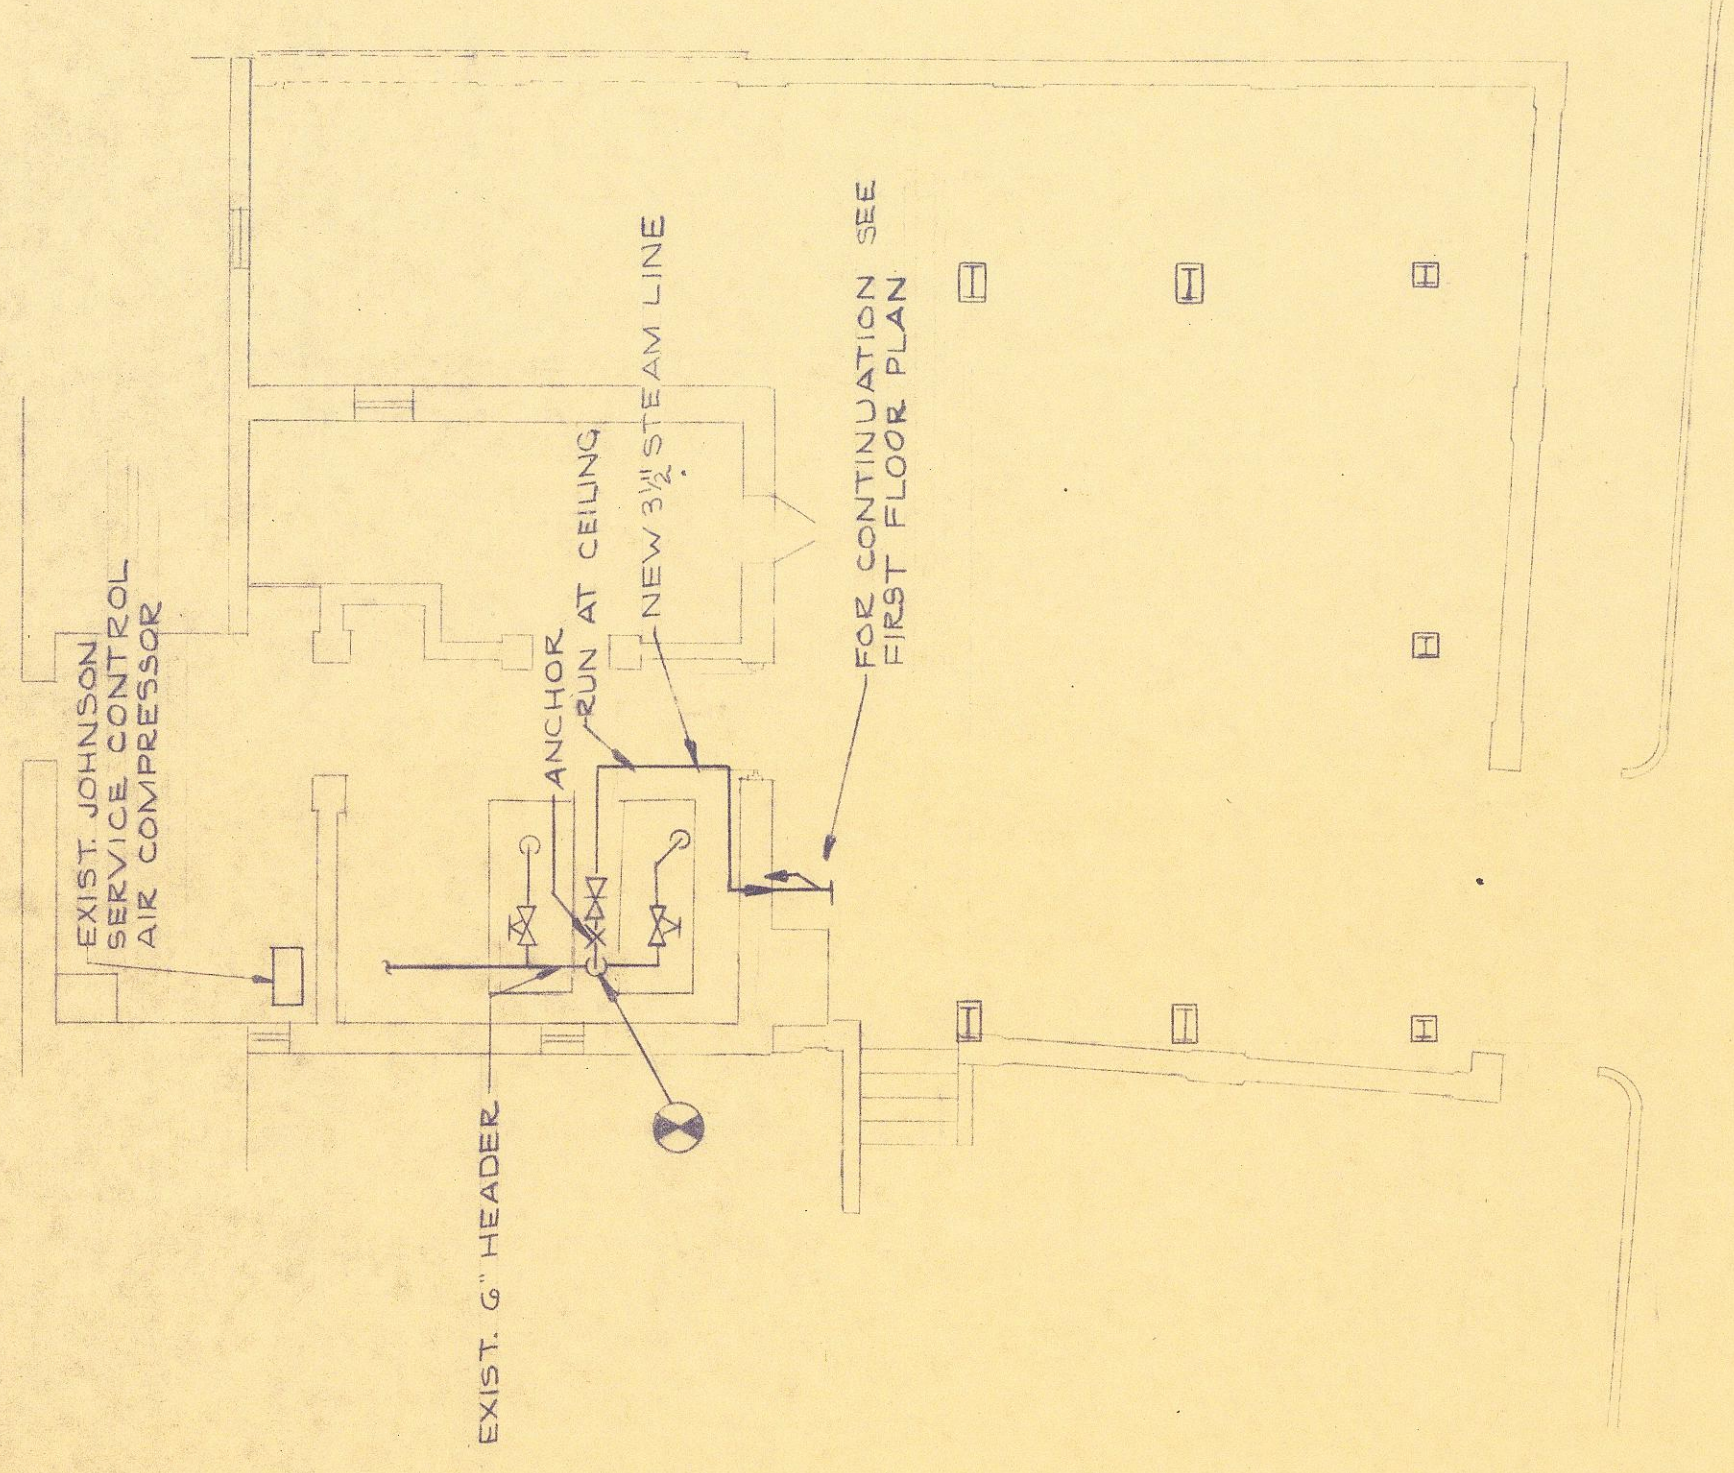


**COURT PLAN**  
SCALE: 1/8" = 1'-0"

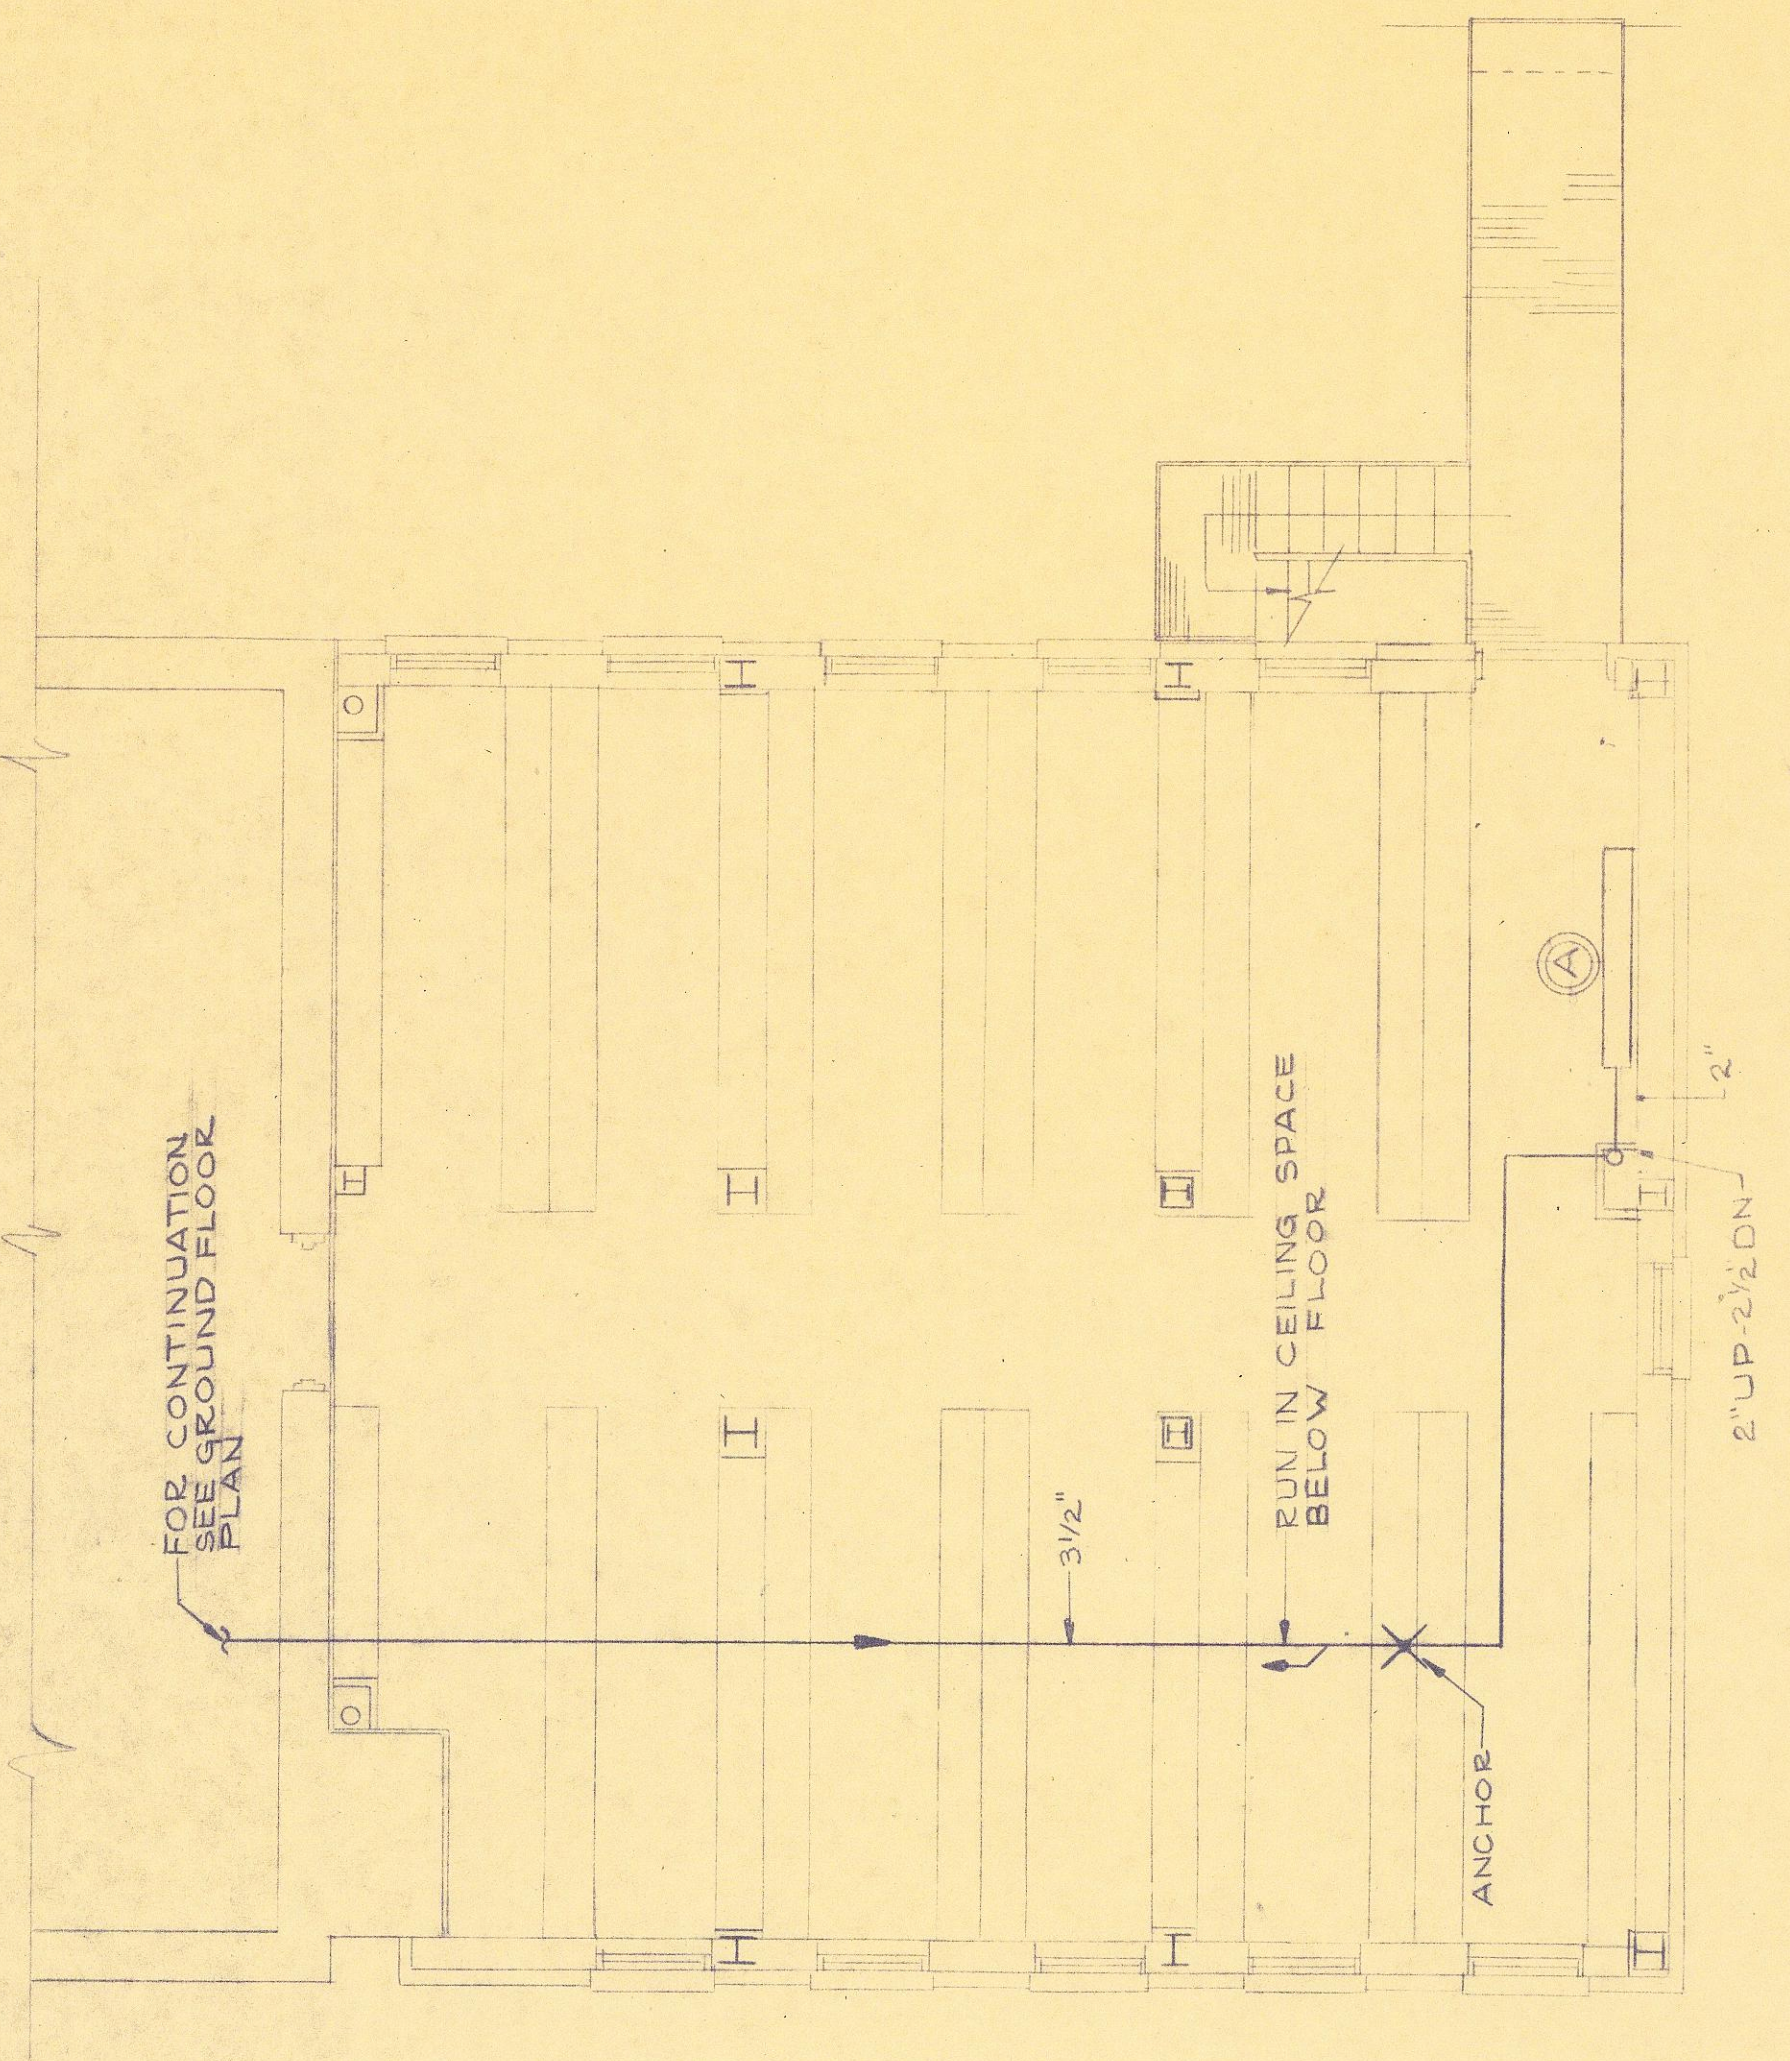

**FIRST FLOOR PLAN**  
SCALE: 1/4" = 1'-0"

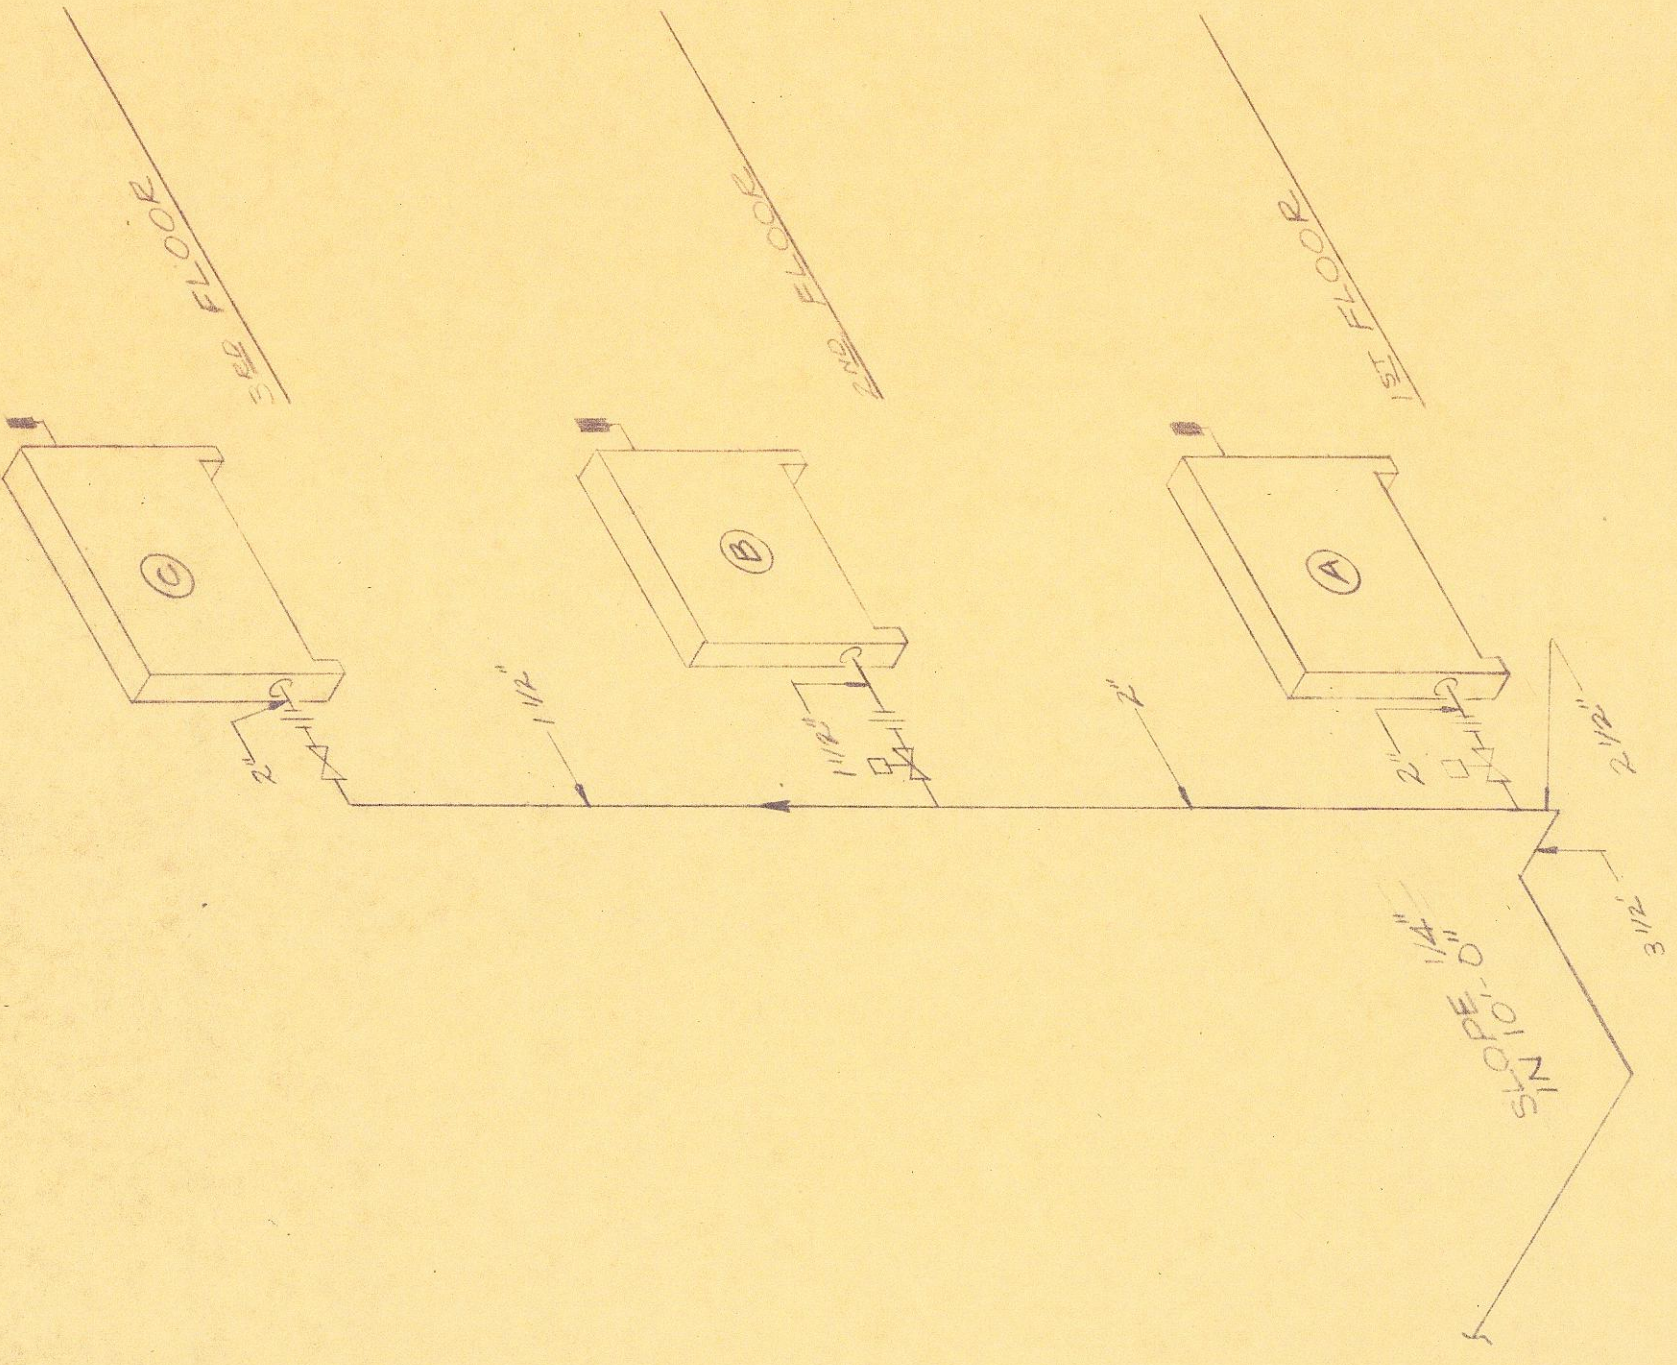

**RADIATOR CONNECTION DETAIL**  
NO. SCALE

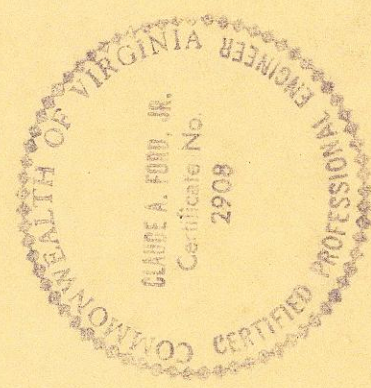

BOOK STACK ADDITION  
TO  
JONES MEMORIAL LIBRARY  
LYNCHBURG, VIRGINIA

CLARK, NEXSEN & OWEN - ARCHITECTS  
LYNCHBURG, VIRGINIA  
NORFOLK, VIRGINIA

PLANS & DETAIL  
DRAWN BY EES  
CHECKED THH  
DATE 18 AUG 67  
SCALE AS NOTED

DWG. NO. M-1